

OAK GROVE CT.

WRIGHT AVE.

LONGVIEW DRIVE

HEIDI DR.

HEIDI CT.

COLLEEN CT.

BERRY CT.

CREST AVE.

W. MAIN AVE.

CLAREMONT DR.

DEWITT AVE.

BONNIE VIEW CT.

TRUMP CT.

ELAINE CT.

MARCIA DR.

FLORENCE CT.

LINDO CT.

LINDO LN.

EL TORO CT.

EL TORO AV.


BRITTON SCHOOL

P.A. WALSH ELEMENTARY SCHOOL

PROJECT LOCATION

GALVAN PARK

YMCA


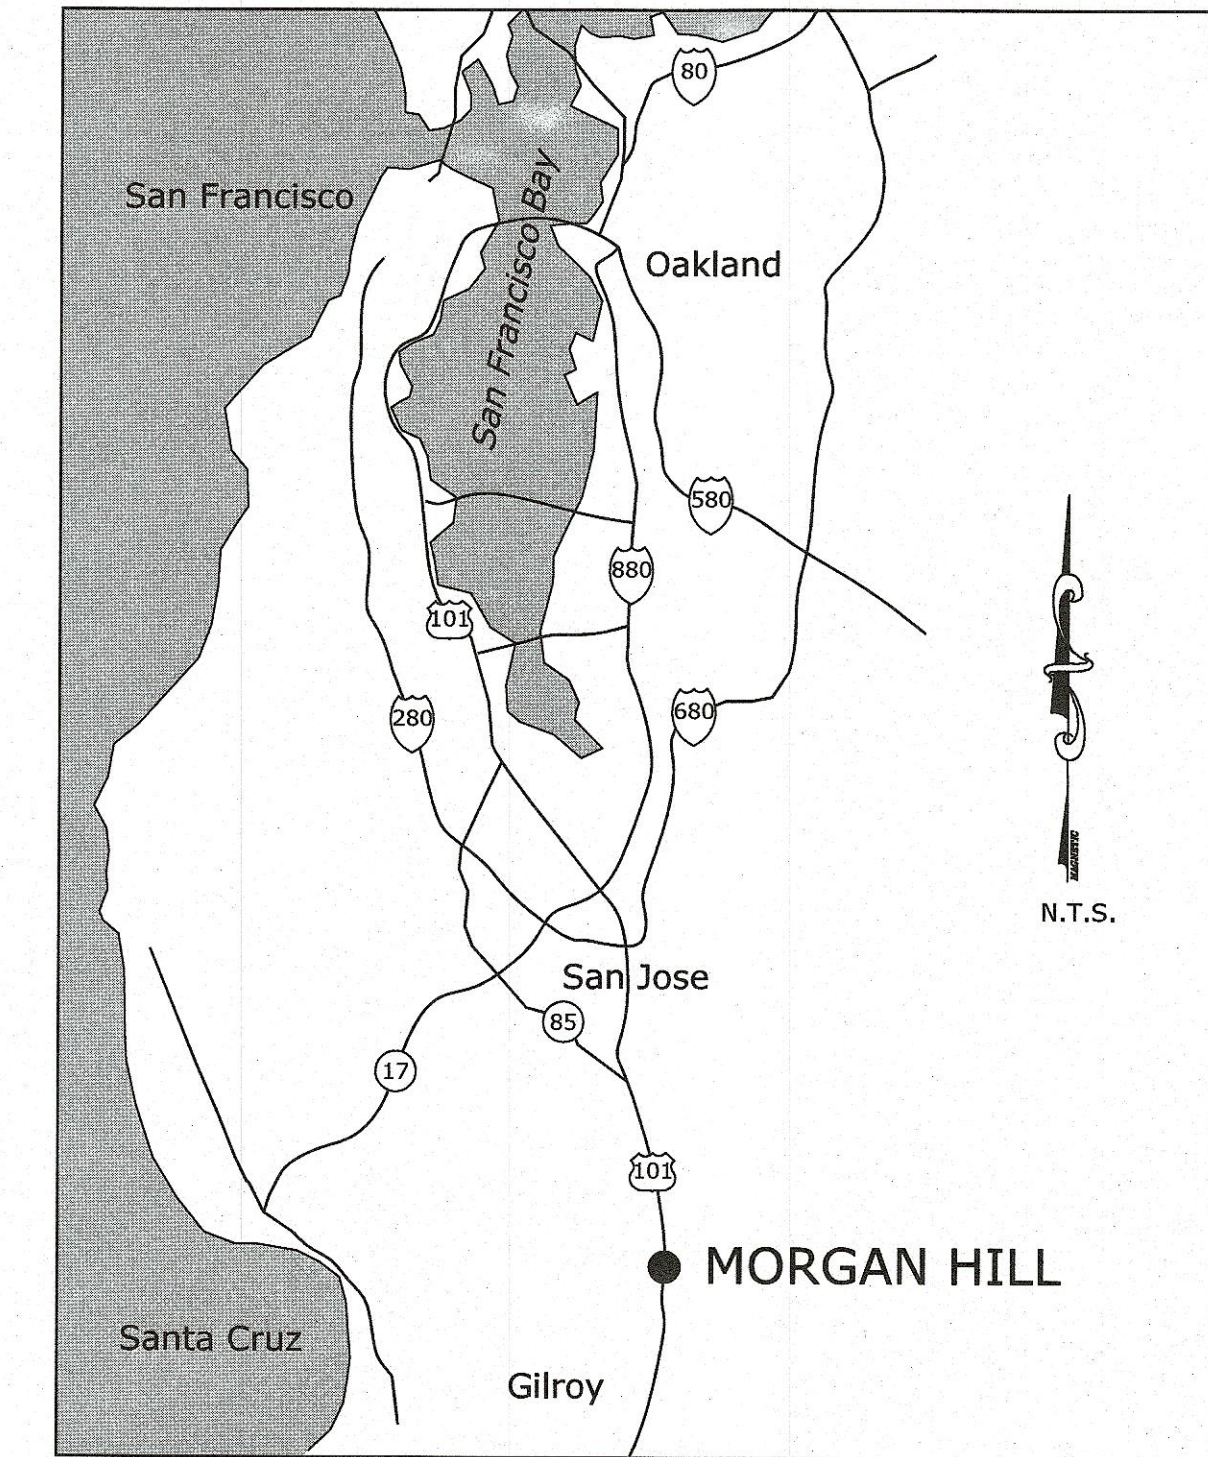


INDEX

SHEET #	DESCRIPTION
1	TITLE SHEET
2	SITE PLAN
G	JUPITER TWIN ACCESSIBLE TITLE SHEET
G1	FINISHES SCHEDULE
G2	STANDARD DETAILS
G3	FRONT PERSPECTIVE
G4	REAR PERSPECTIVE
B5	ELEVATIONS
B6	FLOOR PLAN
B7	SECTION A-A
B8	SECTION B-B
B9	SECTION C-C
B10	SECTION D-D
B11	SCHEMATIC SERVICES PLAN
B12	POWER - ONE LINE DIAGRAM
P13	JUPITER TWIN ACCESSIBLE WASTEWATER SYSTEM
P14	WATER SUPPLY DIAGRAM
P15	WATER SUPPLY VALVE TRAIN
G16	SIGN DOOR ASSEMBLY USA - ADA
G17	ACCESSIBLE RESTROOM DOOR SIGN
B18	FLOOR SLAB - PLAN & SECTION
B19	FLOOR SLAB - REINFORCING DETAIL
B20	FLOOR SLAB - FOUNDATION PLAN
S21	STEEL FRAME - B.O.M - FRONT
S22	STEEL FRAME - B.O.M - REAR
S23	STEEL FRAME - ELEVATIONS & PLAN
S24	STEEL FRAME - ELEVATIONS
S25	STEEL FRAME - ELEVATION & DETAILS
S26	STEEL FRAME - SWING DOOR OPTION
B27	AUXILIARY CONTROL BOX LAYOUT
B28	MAIN CONTROL BOX LAYOUT
B29	MAX LOAD TABLE
B30	ELECTRICAL PANEL SCHEDULE - TWIN BOX
B31	APRON DETAIL

DRAWN:	AEV	DESIGN:	YC	HOR:	N/A
CHECKED:	YC	VERT:			
APPROVED:			DATE:	11/2/22	
JOB NUMBER: SCOTT C. CREECH CITY ENGINEER PE 58879 EXP. 6/30/23					

[illegible]

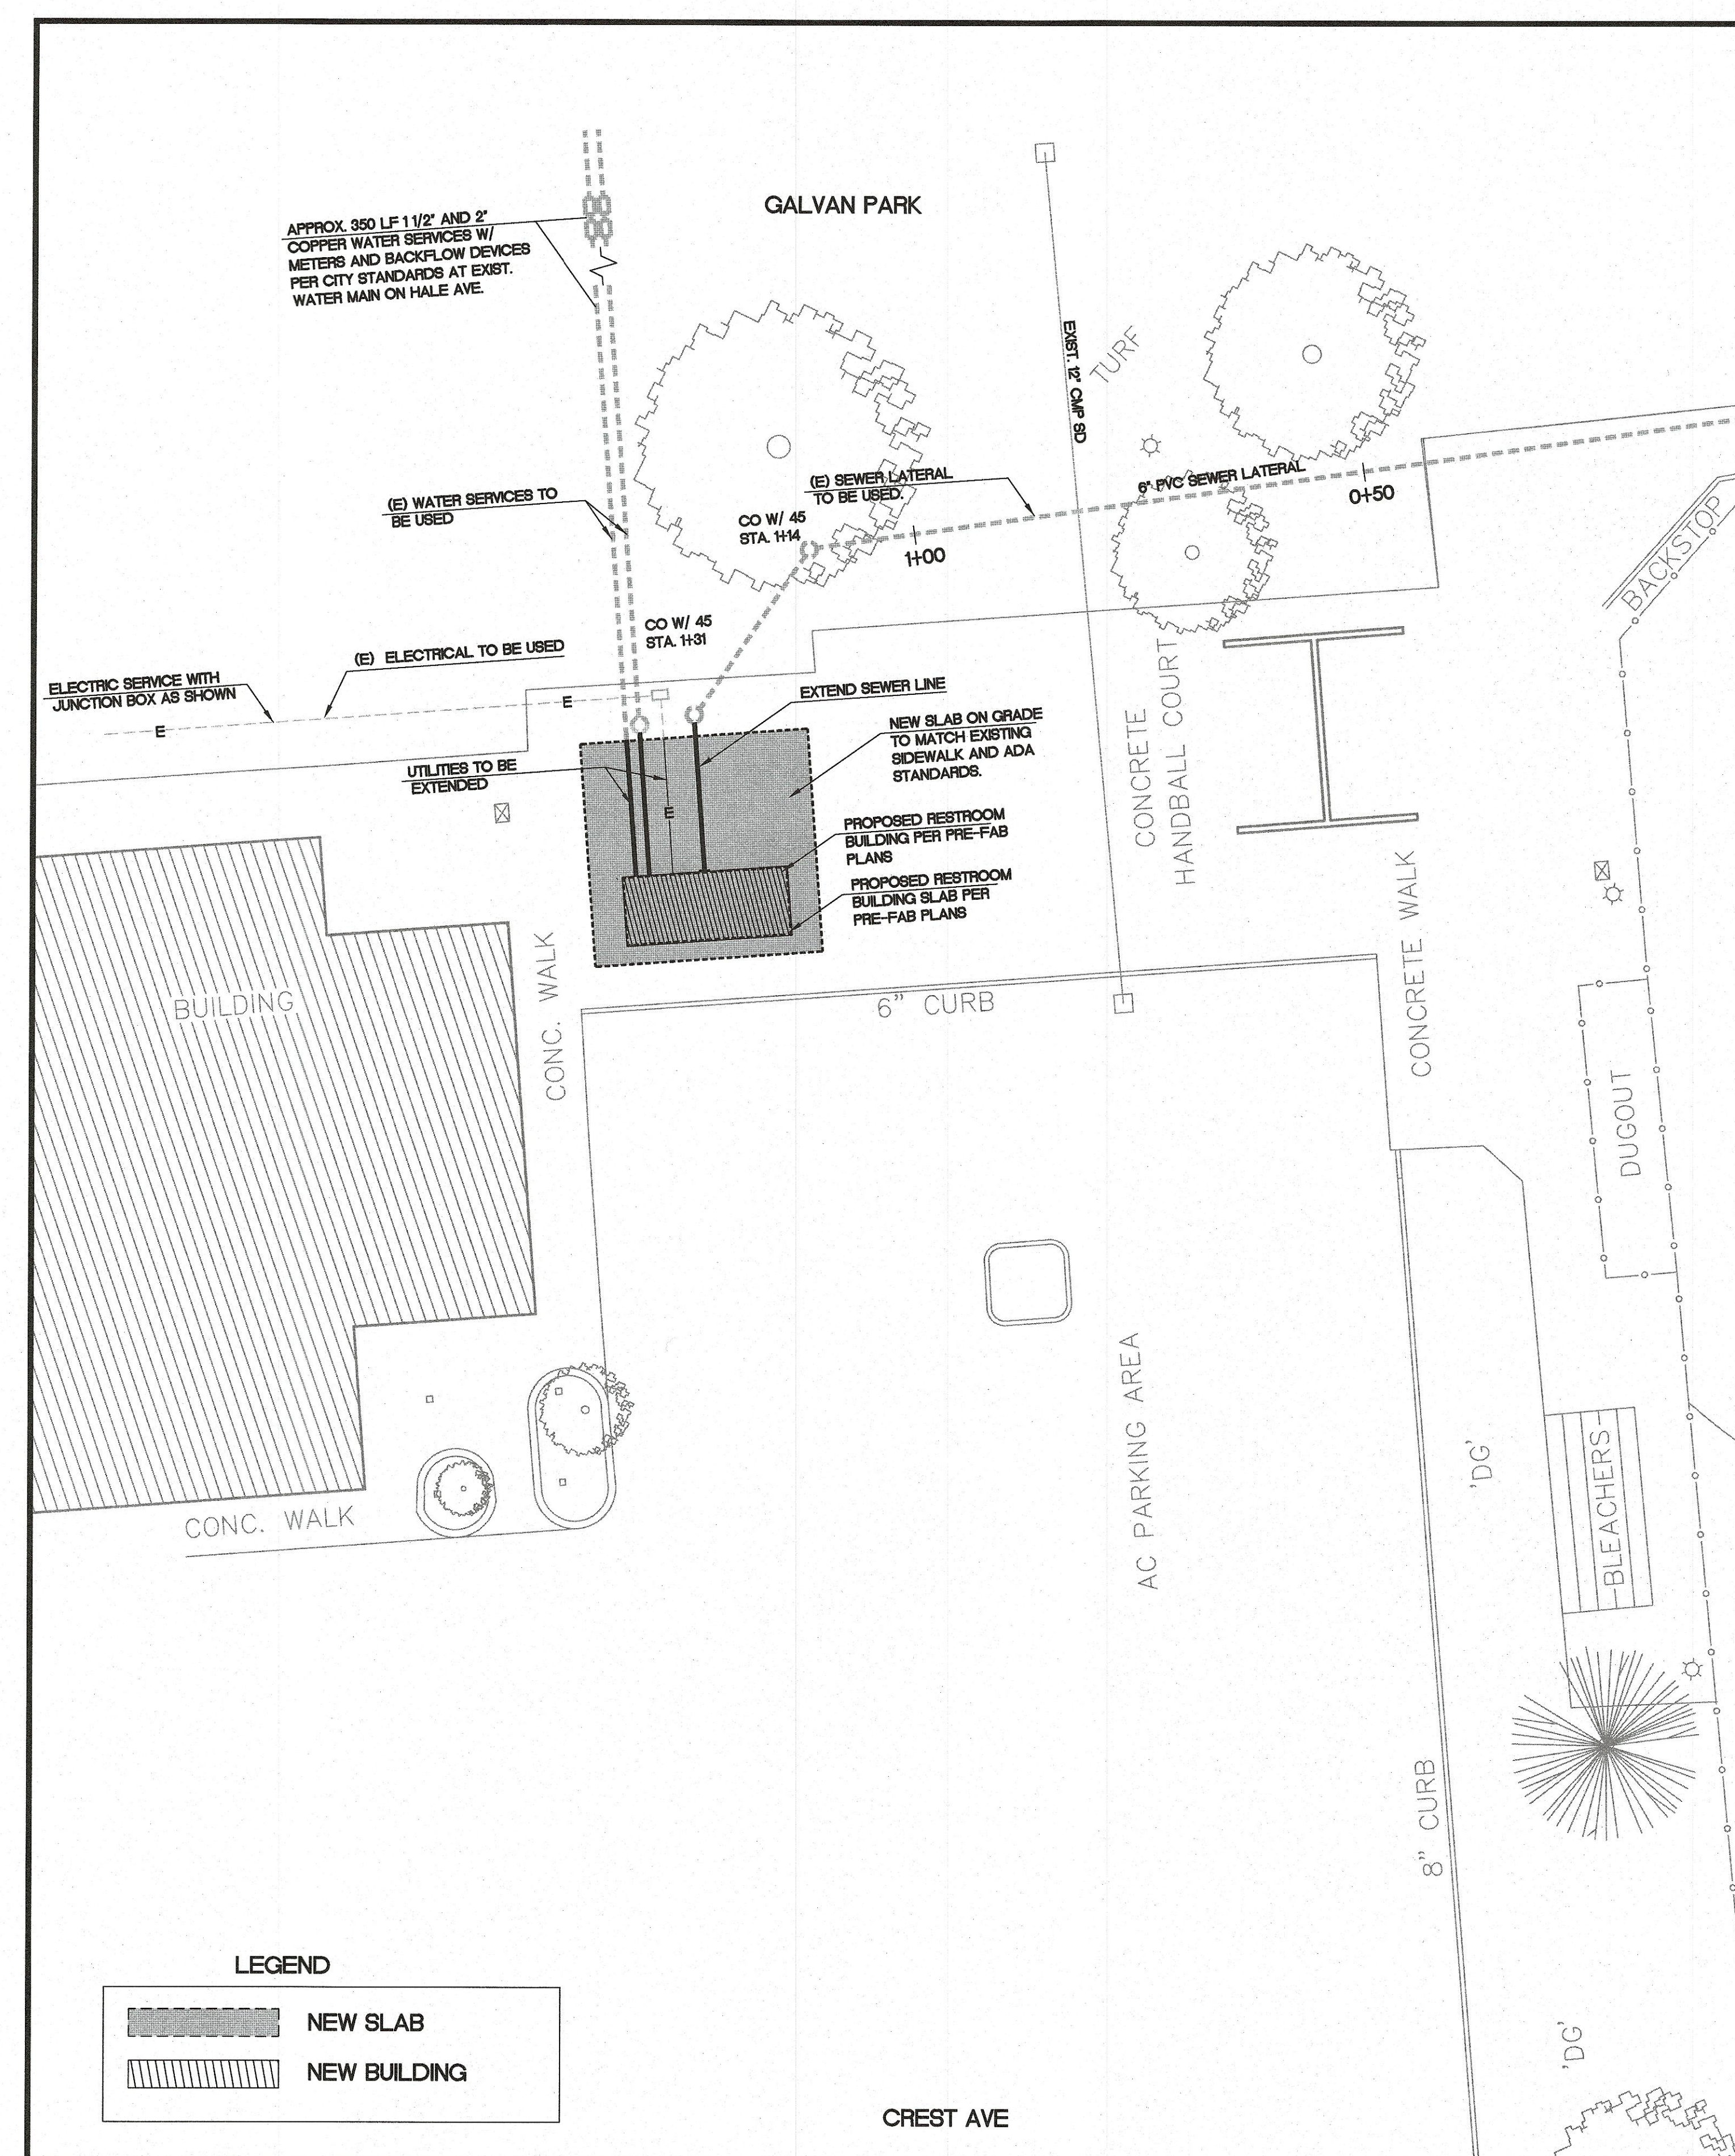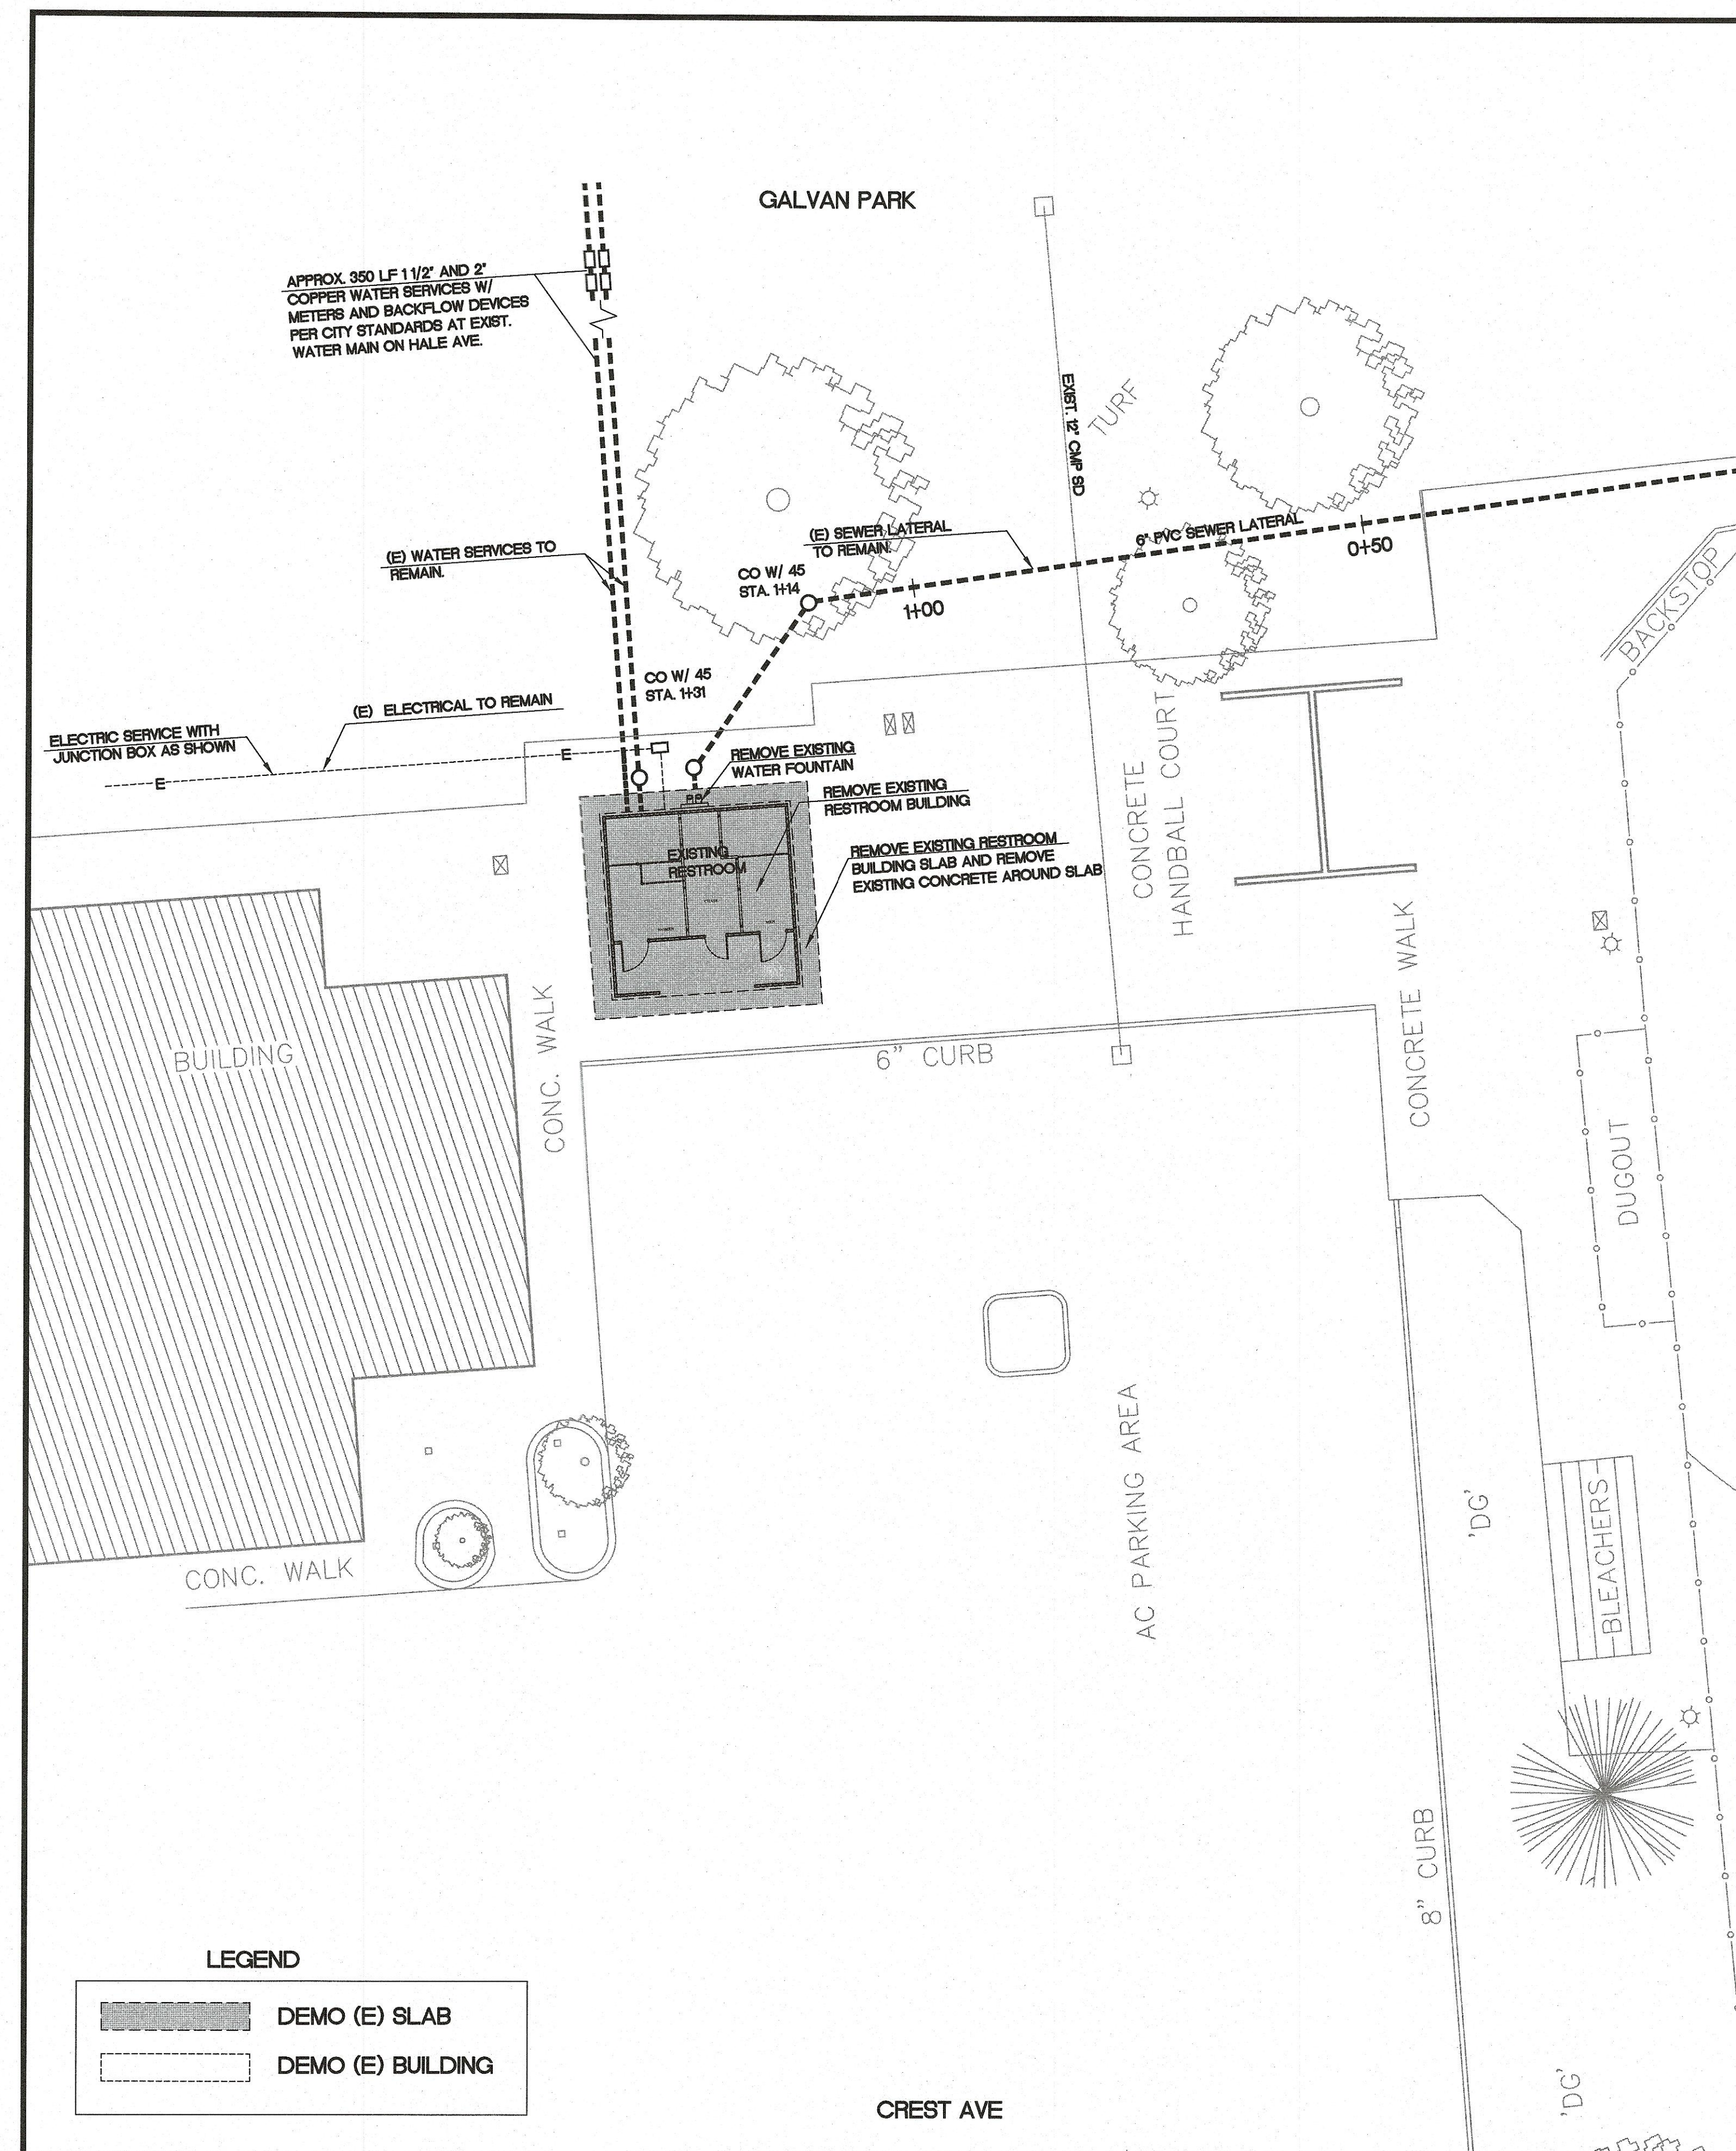

				WORK ACCEPTED:	INSPECTOR:	DRAWN: <i>AEV</i>	DESIGN: <i>YC</i>	HOR: <i>N/A</i>
						CHECKED: <i>YC</i>		VERT: <i>N/A</i>
						APPROVED: <i>J.L.</i>	DATE: <i>11/2/22</i>	JOB NUMBER:
NO.	DESCRIPTION	DATE	BY	BY:	DATE:			
PATH					Revisions	SCOTT C. CREER-CITY ENGINEER PE 58579 EXP. 6/30/23		

JUPITER TWIN ACCESSIBLE USA

EXELOO JUPITER TWIN ACCESSIBLE - DRAWING SCHEDULE

SHEET #	DESCRIPTION	REVISION
G1	FINISHES SCHEDULE	1-H
G2	STANDARD DETAILS	N/A
G3	FRONT PERSPECTIVE	N/A
G4	REAR PERSPECTIVE	1-H
B5	ELEVATIONS	1-H
B6	FLOOR PLAN	1-H
B7	SECTION A-A	1-H
B8	SECTION B-B	1-H
B9	SECTION C-C	1-H
B10	SECTION D-D	1-H
B11	SCHEMATIC SERVICES PLAN	1-H
B12	POWER - ONE LINE DIAGRAM	1-H
P13	JUPITER TWIN ACCESSIBLE WASTEWATER SYSTEM	1-C
P14	WATER SUPPLY DIAGRAM	1-H
P15	WATER SUPPLY VALVE TRAIN	1-A
G16	SIGN DOOR ASSEMBLY USA - ADA	1-A
G17	ACCESSIBLE RESTROOM DOOR SIGN	1-A
B18	FLOOR SLAB - PLAN & SECTION	1-A
B19	FLOOR SLAB - REINFORCING DETAIL	1-A
B20	FLOOR SLAB - FOUNDATION PLAN	1-O
S21	STEEL FRAME - B.O.M - FRONT	1-H
S22	STEEL FRAME - B.O.M - REAR	1-H
S23	STEEL FRAME - ELEVATIONS & PLAN	1-H
S24	STEEL FRAME - ELEVATIONS	1-H
S25	STEEL FRAME - ELEVATION & DETAILS	1-H
S26	STEEL FRAME - SWING DOOR OPTION	1-H
B27	AUXILIARY CONTROL BOX LAYOUT	1-H
B28	MAIN CONTROL BOX LAYOUT	1-H
B29	MAX LOAD TABLE	1-H
B30	ELECTRICAL PANEL SCHEDULE - TWIN BOX	1-H
B31	APRON DETAIL	1-H

THIS DRAWING SET COVERS:

1. JUPITER 22DD - AUTOMATIC TWIN ACCESSIBLE
2. JUPITER 32DD - SEMI-AUTOMATIC TWIN ACCESSIBLE
3. JUPITER 42/52DD - MANUAL TWIN ACCESSIBLE

REFER TO EXELOO QUALITY ASSURANCE MANUAL FOR FIT-OUT OPTIONS

WORK COMPLETED AT EXELOO FACTORY:

1. PRE-FABRICATED TOILET UNIT - CONCRETE SLAB, STEEL FRAME STRUCTURE, WALL CLADDING, INTERNAL WALLS, RESTROOM FITTINGS, ROOF & FLASHINGS (REMOVED FOR TRANSPORT)
2. PLUMBING & ELECTRICAL WORK

NOTES:

1. RESTROOM MANUFACTURER WILL DELIVER RESTROOM TO SITE AND CRANE ONTO GRADE BEAMS.
2. CONTRACTOR TO CONSTRUCT GRADE BEAMS AND BASE, EXTEND EXISTING UTILITIES AND PROVIDE FINAL CONNECTIONS (SANITARY SEWER, WATER AND ELECTRICAL).
3. CONTRACTOR TO INSTALL PREFABRICATED FOAM CORE ROOF PANELS AND FLASHING PER MANUFACTURER'S INSTRUCTIONS.
4. CONTRACTOR TO BE RESPONSIBLE FOR PROPER DISPOSAL OF ALL SPOILS AND SITE GENERAL RESTORATION AND CLEAN-UP (NOT INCLUDING TURF ESTABLISHMENT).
5. RESTROOM MANUFACTURER WILL TEST FINAL OPERATION OF FACILITY AND REMOTE COMMUNICATION

1. SOILS INFORMATION

A. NO SOILS REPORT PROVIDED. THE FOLLOWING IS AN ASSUMED VALUE:

1. DESIGN SOIL BEARING CAPACITY = 1500 psf
2. THE FOUNDATION IS DESIGNED PER IBC MINIMUM STANDARDS.

B. WITHOUT A SOILS REPORT THOM HUME CONSULTING ENGINEERS CANNOT BE RESPONSIBLE FOR FOUNDATION SETTLEMENTS OR MOVEMENTS.

C. MAINTAIN BOTTOM OF FOOTING SUCH THAT THE HORIZONTAL DISTANCE TO DAYLIGHT IS 40'-0" AND PER SEC 1808.7.2 OF CURRENT CBC EDITION.

2. FOUNDATION INFORMATION

A. CONCRETE:

- A.A. MAXIMUM 28-DAY STRENGTH OF 3,000 psi
- A.B. MAXIMUM WATER TO CEMENT RATIO OF 0.57
- A.C. MAXIMUM AGGREGATE SIZE OF 1"
- A.D. SLUMP OF 4" ±1"
- A.E. NO SPECIAL INSPECTION REQUIRED

B. REINFORCING:

- B.A. ALL REINFORCING SHALL BE ASTM A-615 GRADE 60
- B.B. CLEAR COVER TO ALL REBAR SHALL BE 3"

0000 CODES AND REFERENCES

ALL GENERAL STRUCTURAL NOTES AND SPECIFICATIONS REFLECT THE PROVISIONS OF THE:

- 2019 CBC (CALIFORNIA BUILDING CODE)
- ACI 318-14 (CONCRETE)
- AISC 360-16/AISC-16/AISC 358-16 (STEEL)

SEISMIC:	
Design Procedure: Equivalent Lateral Force Analysis	
Importance	:1
Risk Category	:2
Occupancy Category	:II
S _s	:2.72
S _i	:1.0
S _{ds}	:2.00
S _{d1}	:1.1
Site Class	:D
Seismic Design Cat.	:E
Seismic Force Sys	:OMF
Base Shear	:3.75k
C _s	:0.571
R	:3.5
Analysis Procedure	:LIN. STATIC

WIND:	
Basic Wind Speed:	115 mph
Wind Exposure:	C
Internal Pressure Coefficient:	±0.18
Risk Category	II

PROJECT DATA:

ADDRESS: **STATEWIDE APPROVAL**

CODES & STANDARDS:

2019 CALIFORNIA BUILDING CODE (BASED ON THE 2018 IBC)
2019 CALIFORNIA MECHANICAL CODE (BASED ON THE 2018 UMC)
2019 CALIFORNIA PLUMBING CODE (BASED ON THE 2018 UPC)
2019 CALIFORNIA ELECTRICAL CODE (BASED ON THE 2017 NEC)
2019 CALIFORNIA GREEN BUILDING STANDARD CODE (CGBSC)
2019 CALIFORNIA ENERGY CODE

BUILDING INFO:

BLDG USE: PUBLIC RESTROOM
BLDG OCCUP: B
OCCUPANT LOAD: 1/PER STALL
CONSTRUCTION TYPE: (IBC 602) TYPE V-B
BLDG AREA: 135 SF (TABLE 506.2 ALLOWED 9,000 SF)
BLDG HTG: 9'-0" SINGLE STORY
EXITS REQD: 1/STALL
EXITS PROVIDE: 1/STALL
FIRE SUPPRESSION: NON-SPRINKLERED

APPLICABLE LOADS:

ROOF LIVE LOAD: 20
DEAD LOAD: 10
SNOW LOAD: 20

FLOOR LOAD: 40

WIND SPEED: 115
EXPOSURE: C
SEISMIC DESIGN CATEGORY: E
RISK CATEGORY: 2

BLDG HVAC: N/A

NOTE:


1. THIS IS A NON-CONDITIONED BUILDING
2. THIS BUILDING HAS NOT BEEN DESIGNED FOR WILDFIRE LOCATIONS (WUI)
3. SNOW LOADING NOT CONSIDERED IN THIS DESIGN

exelOO®		New Zealand	Australia	USA	
		26 Paramount Dve Henderson 0610 PO Box 33-256 Takapuna, Auckland T: +64-9-838-8912 F: +64-9-838-8913	Unit 18, 62-66 Newton Rd Wetherill Park PO Box 12 Liverpool NSW 1871 T: +61-2-975-3444 F: +61-2-1-800-105-504	954 Toro St San Luis Obispo CA 93401 PO Box 13310 San Luis Obispo CA 93406 T: (800) 676-5290 or 1-800-303-3506	
Description: JUPITER TWIN ACCESSIBLE USA		Proj: 	Units: in	Rev. 1-H	Rev Date: 24/08/2022
Tolerance: +/-0.5		Scale: N.T.S.	Checked by:	Approved by:	
Material:	Finish: REF	Drawn by: JJG	Creation Date: 16/04/2012	Sheet No. G	Drawing No: ASJUP22DD-US1BON
DO NOT SCALE - IF IN DOUBT ASK		SPECIFICATION SUBJECT TO CHANGE WITHOUT NOTICE			


10	9	8	7	6	5	4	3	2	1	
J	EXELOO FINISHES SCHEDULE									J
STRUCTURAL										
#	ITEM	SUPPLIER	DETAIL	SPECIFICATION						
1	Floor	Stresscrete	Steel Reinforced concrete	Slab thickness 6 5/16"/5 1/8" steel reinforced concrete						
2	Walls	Galvanised steel frame	Electro Plated Duragalv	3/16" & 1/8" thick electroplated galvanised steel						
3	Roof Frame	Galvanised steel frame	Electro Plated Duragalv	3/16" & 1/8" thick electroplated galvanised steel						
EXTERIOR LININGS										
#	ITEM	SUPPLIER	DETAIL	SPECIFICATION						
4	Wall Cladding	Fibre Cement Solutions Ltd	Eterpan MD Fibre cement sheet	1/2" & 11/16" Fibre cement laminated sheet						
5	Roof	MetalCraft	MetecnoSpan (PIR)	3-1/8" panel M 4880 Approved Class 1 - Unlimited Height. FM 4881 Approved Class 1 - Unlimited Height. FM 4471 Approved Class 1 -External roof and wall endurance standard.						
6	Gutter & Flashings	Steel & Tube	Coloursteel	10 -15 years warranty under right maintenance plan						
7	Vent Pipes	Ferguson	Schedule 40 Pipe & Fittings	4" Schedule 40 pipe and fittings for drain waste and vent applications						
8	Doors	Cavity Sliders	Stainless steel T316 Brushed	Stainless steel sheet skin with alloy interior						
9	Paint	Altex	Epoxy 2 part paint	5 - 10 years warranty under the right maintenance plan						
10	Grills	Exeloo	Solid grills cut and folded by Exeloo	T316 Stainless Steel Brused #4						
INTERIOR LININGS										
#	ITEM	SUPPLIER	DETAIL	SPECIFICATION						
11	Wall Cladding	Fibre Cement Solutions Ltd	Eterpan MD Fibre cement sheet	1/2" & 11/16" Fibre cement laminated sheet						
12	Floor Finish	Cutting Edge Tiling	Brasil Nero Charcoal	Ceramic Non Slip tiles 17 11/16" x 17 11/16"						
14	Wall linings - Toilet/Shower	Cutting Edge Tiling	Sanctuary Cool White	Ceramic tiles 11 13/16" x 23 5/8"						
ELECTRICAL FITTINGS										
#	ITEM	SUPPLIER	DETAIL	SPECIFICATION						
16	Control Box	PLC Power	PLC Control Box	Proface LT3300-T						
PLUMBING FITTINGS										
#	ITEM	SUPPLIER	DETAIL	SPECIFICATION						
19	Toilet pans	Stoddart	Stainless steel	23 5/8" - 27 9/16" stainless pans.						
20	Zurn Valve	MacDonald Industries	Flushing system	1.28gal (4.8L) max. per flush						
21	Water supply system	Mico	Stainless steel crimp ring plumbing system	RIIFO Rifeng Pex Pipe & MLP (multilayer pipes) – DZR Universal Fittings						
22	Waste water system (DWV)	Ferguson	Schedule 40 Pipe and Fittings	1-1/2" to 4" Schedule 40 pipe and fittings for drain waste and vent applications						
23	WS 400	Duraclenz	Stainless Steel recessed unit	Soap, Water & hand dryer built in wash station, Lavatory Faucet 0.5gpm (max.) @ 60psi (1.9L/m @ 414kPa)						
24	Flush Valve Water Solenoid	SMC	SIRAI L177B04	PS = 30 bar						
HARDWARE										
#	ITEM	SUPPLIER	DETAIL	SPECIFICATION						
25	Door hardware	Legge	Legge 800 Series	Forged Brass and 10 year warranty						
26	Grab rails	Superquip	Stainless Steel	1 1/4" knurled stainless grab rails						
SEATING & TABLES										
#	ITEM	SUPPLIER	DETAIL	SPECIFICATION						
27	Baby Change table	Duraclenz	Stainless Steel & fibreglass inserts	Weight limit 187lbs						
ACCESSORIES										
#	ITEM	SUPPLIER	DETAIL	SPECIFICATION						
30	Floor Dry Fans	Fantech	CEG MN80C2 - 0MLT	1.5kw 230V						
31	Extract Fans	Fantech	Fantech FR150 USA	120V CFM 263						
32	Exterior Lights	Dualcom Technology Ltd	Battenpro-300-12V LED SMD2835	1000Lm 10W IP65						
33	Interior Lights	Dualcom Technology Ltd	Battenpro-600-12V LED SMD2835	2000Lm 20W IP65						
34	Speakers	VEXX	For music & instruction	5" speaker						
35	Security System	Intergrated Consulting	Dahua Starlight pinhole camera	2MP HDCVI covert camera with 3.6mm lens						
36	Paper Dispenser	Duraclenz	Stainless Steel EMD8200RH	Dual roll holder						
37	Nappy / Sani chute	Duraclenz	Hinged flap chute	Stainless Steel T304 Brushed						

STANDARD DETAILS


PLUMBING FIXTURES

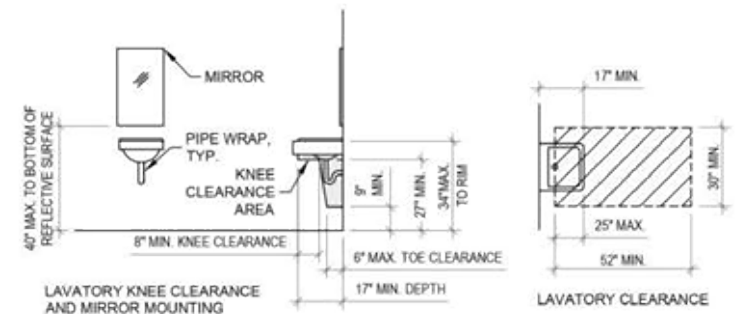


CLEARANCE AT LAVATORIES AND SINKS ANSI FIGURE C606.2(a) AND FIGURE 306.2

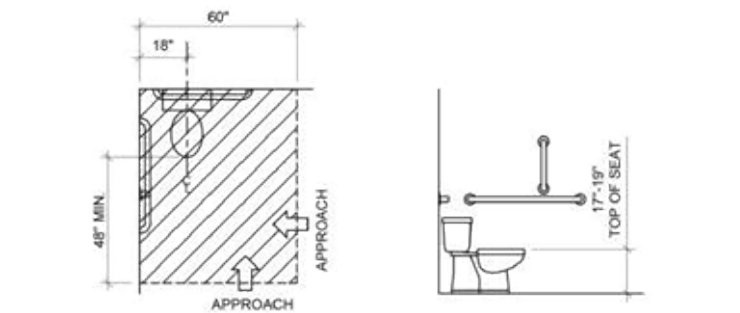

CLEARANCE AT WATER CLOSETS AND HEIGHT ANSI FIGURE 604.3 AND FIGURE 604.4

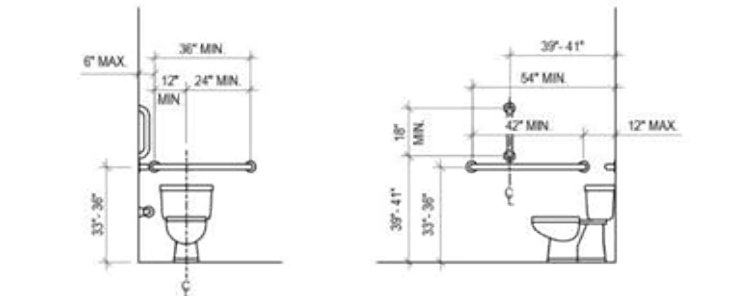

GRAB BARS AT WATER CLOSETS ANSI FIGURE 604.5.1 AND FIGURE 604.5.2

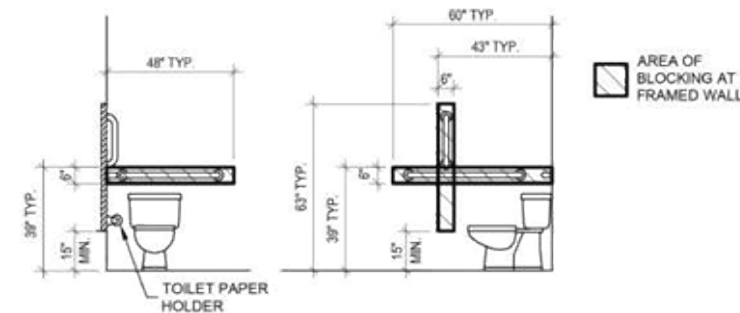


BLOCKING AT WATER CLOSET GRAB BARS






TOILET PAPER DISPENSER OUTLET LOCATION FIGURE 604.7

WALL MOUNTED DEVICES AND APPLIANCES

NOTE:
1. WALL MOUNTED DEVICES SHALL NOT EXTEND MORE THAN 4" BEYOND WALL SURFACE WHEN LOCATED BELOW 6'-8"

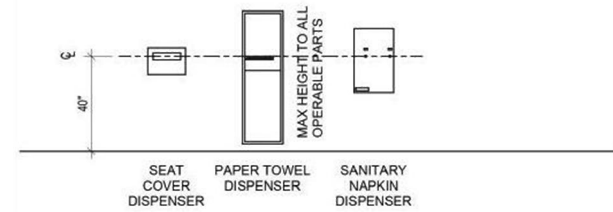


DOORS

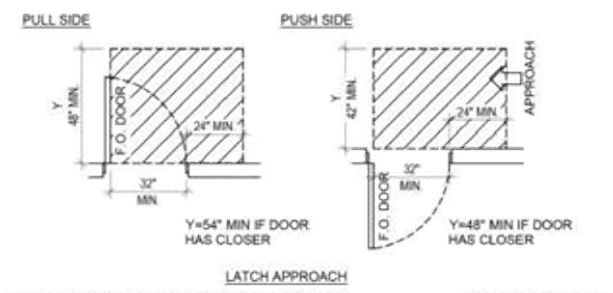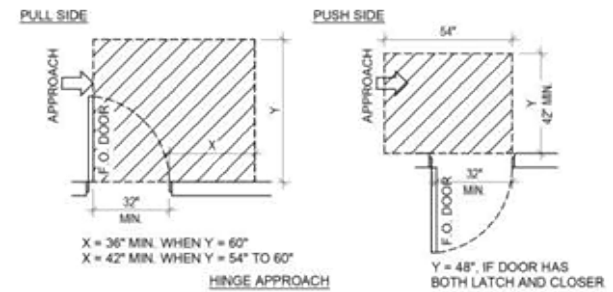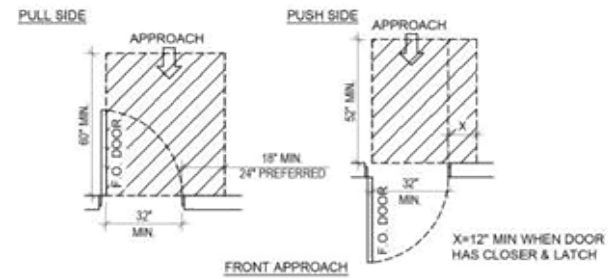


MANEUVERING CLEARANCES AT SWINGING DOORS ANSI SECTION 404.2.3


CLEARANCES

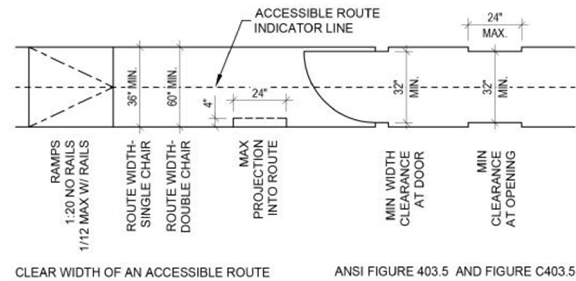


CLEAR WIDTH OF AN ACCESSIBLE ROUTE ANSI FIGURE 403.5 AND FIGURE C403.5

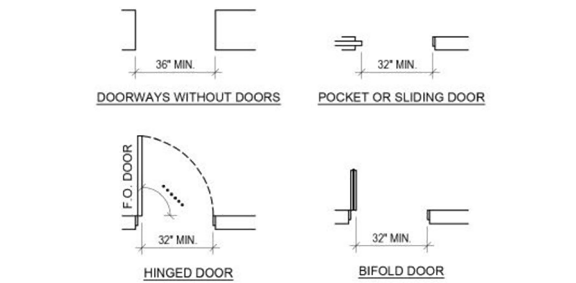



CLEAR WIDTH OF DOORWAYS ANSI FIGURE 404.2.2

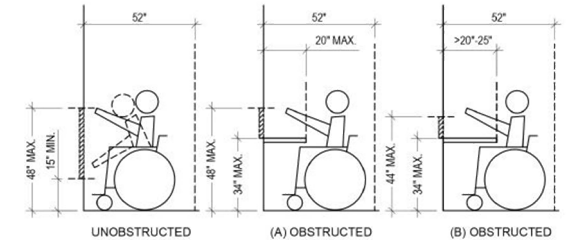


FORWARD REACH REQUIREMENTS ANSI FIGURE 308.2.1 AND FIGURE 308.2.2

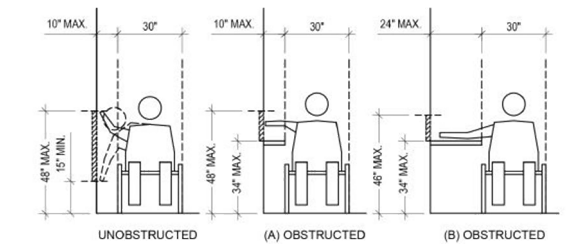

SIDE REACH REQUIREMENTS ANSI FIGURE 308.3.1 AND FIGURE 308.3.2

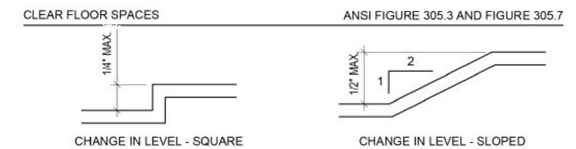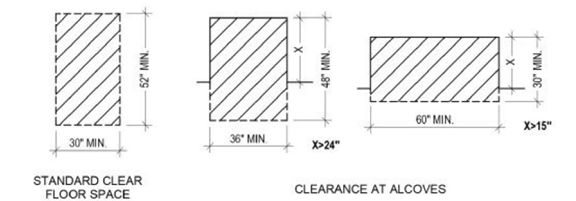

LEVEL CHANGE ON ACCESSIBLE ROUTE ANSI FIGURE 303.2 AND FIGURE 303.3

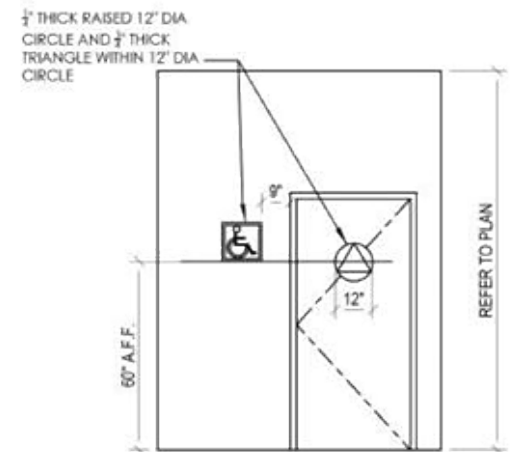

1. PROVIDE GEOMETRIC SYMBOLS ON RESTROOM
COLOR AND CONTRAST SHALL BE IDENTIFIED FROM
THE COLOR AND CONTRAST OF THE DOOR.
2. ALSO PROVIDE SIGNAGE WITH RAISED LETTERING
AND BRAILLE
LOCATED ON THE WALL ADJACENT TO THE STRIKE
THE RESTROOM.
DOOR SIGNAGE ELEVATION

exelOO

New Zealand
26 Paramount Dve Henderson 0610
PO Box 33-256 Takapuna, Auckland
T: +64-9-838-8912 F: +64-9-838-8913

Australia
Unit 18, 62-66 Newton Rd Wetherill Park
PO Box 12 Liverpool NSW 1871
T: +61-2-975-3444 F: +61-2-1-800-105-504

USA
954 Toro St San Luis Obispo CA 93401
PO Box 13310 San Luis Obispo CA 93406
T: (800) 676-5290 or 1-800-303-3506

Description:
JUPITER TWIN ACCESSIBLE USA

Material:
REF

Finish:
REF

Proj:

Tolerance:
+/-0.5

Scale:
N.T.S.

Drawn by:
JJG

Creation Date:
16/04/2012

Units:
in

Checked by:

Sheet No:
G 2

Drawing No:
ASJUP22DD-US1BON

Rev:
1-H

Rev Date:
24/08/2022

DO NOT SCALE - IF IN DOUBT ASK

SPECIFICATION SUBJECT TO CHANGE WITHOUT NOTICE





REAR PERSPECTIVE



New Zealand
26 Paramount Dve Henderson 0610
PO Box 33-256 Takapuna, Auckland
T: +64-9-838-8912 F: +64-9-838-8913


Australia
Unit 18, 62-66 Newton Rd Wetherill Park
PO Box 12 Liverpool NSW 1871
T: +61-2-975-3444 F: +61-2-1-800-105-504


USA
954 Toro St San Luis Obispo CA 93401
PO Box 13310 San Luis Obispo CA 93406
T: (800) 676-5290 or 1-800-303-3506

Description: JUPITER TWIN ACCESSIBLE USA		Proj: 		Units: in	Rev. 1-H	Rev Date. 24/08/2022
Tolerance: +/-0.5		Scale: N.T.S.		Checked by:	Approved by:	
Material:	Finish: REF	Drawn by: JJG	Creation Date: 16/04/2012	Sheet No. G 4	Drawing No: ASJUP22DD-US1BON	

DO NOT SCALE - IF IN DOUBT ASK

SPECIFICATION SUBJECT TO CHANGE WITHOUT NOTICE

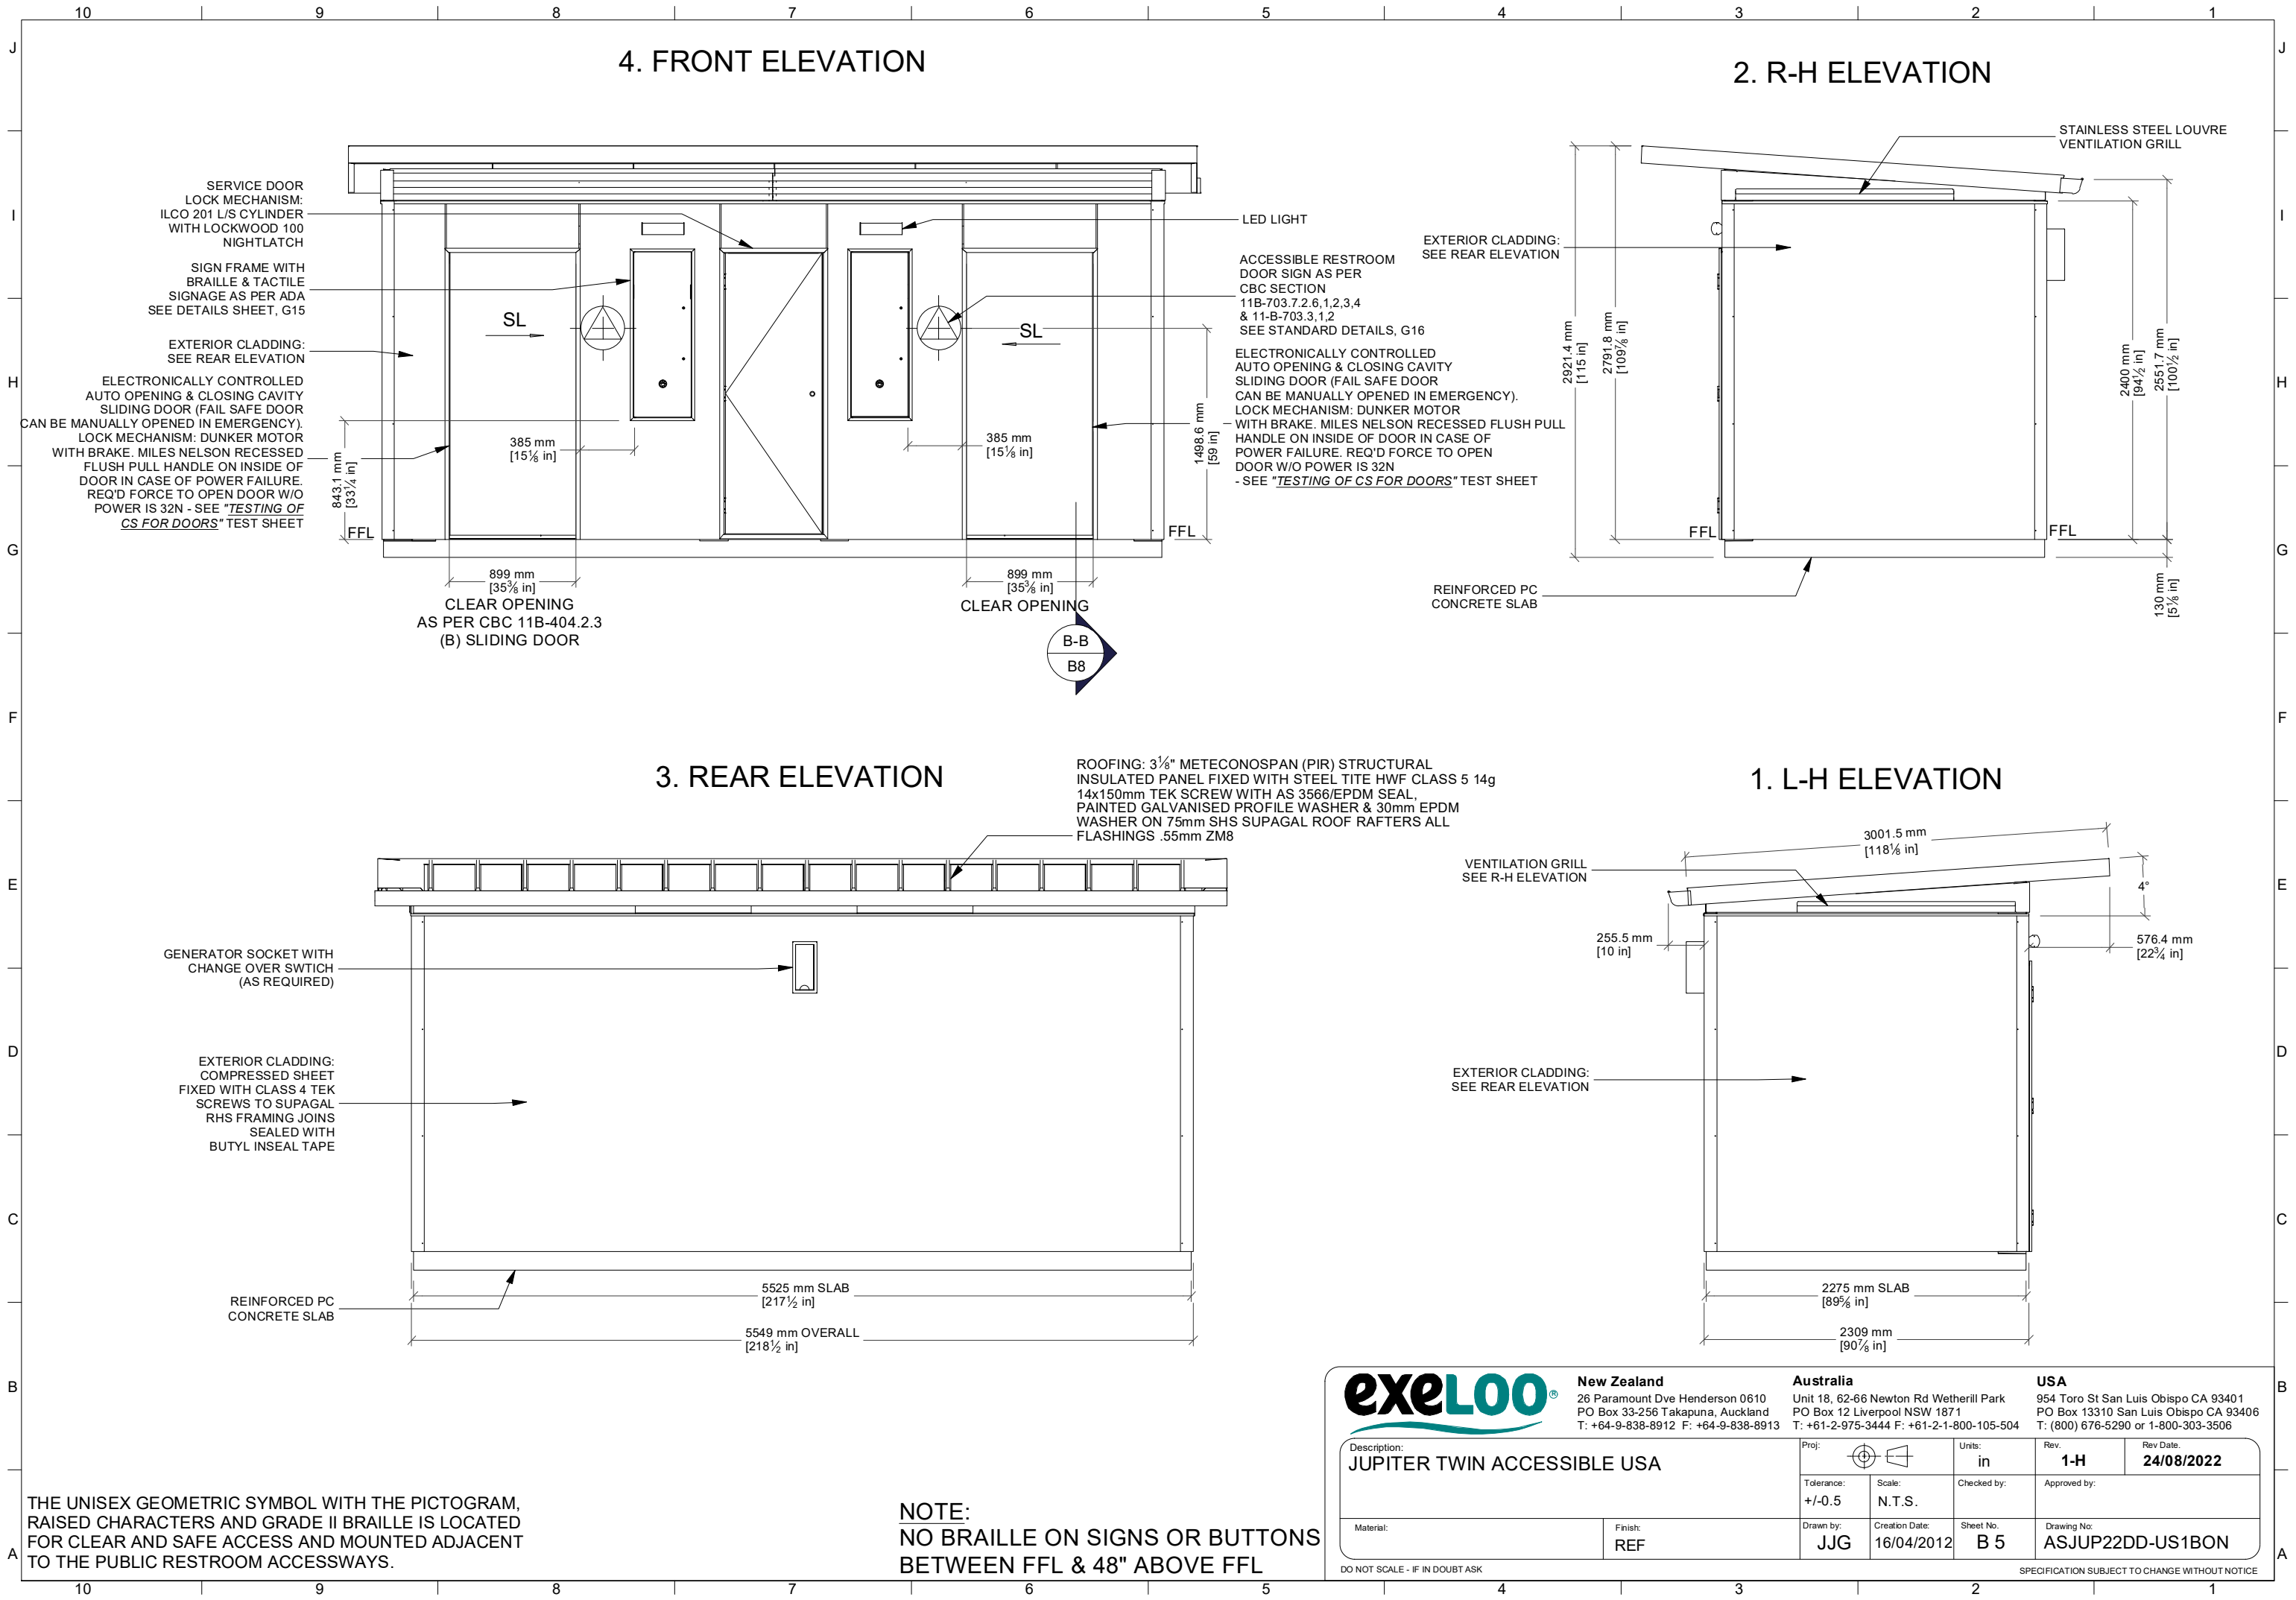

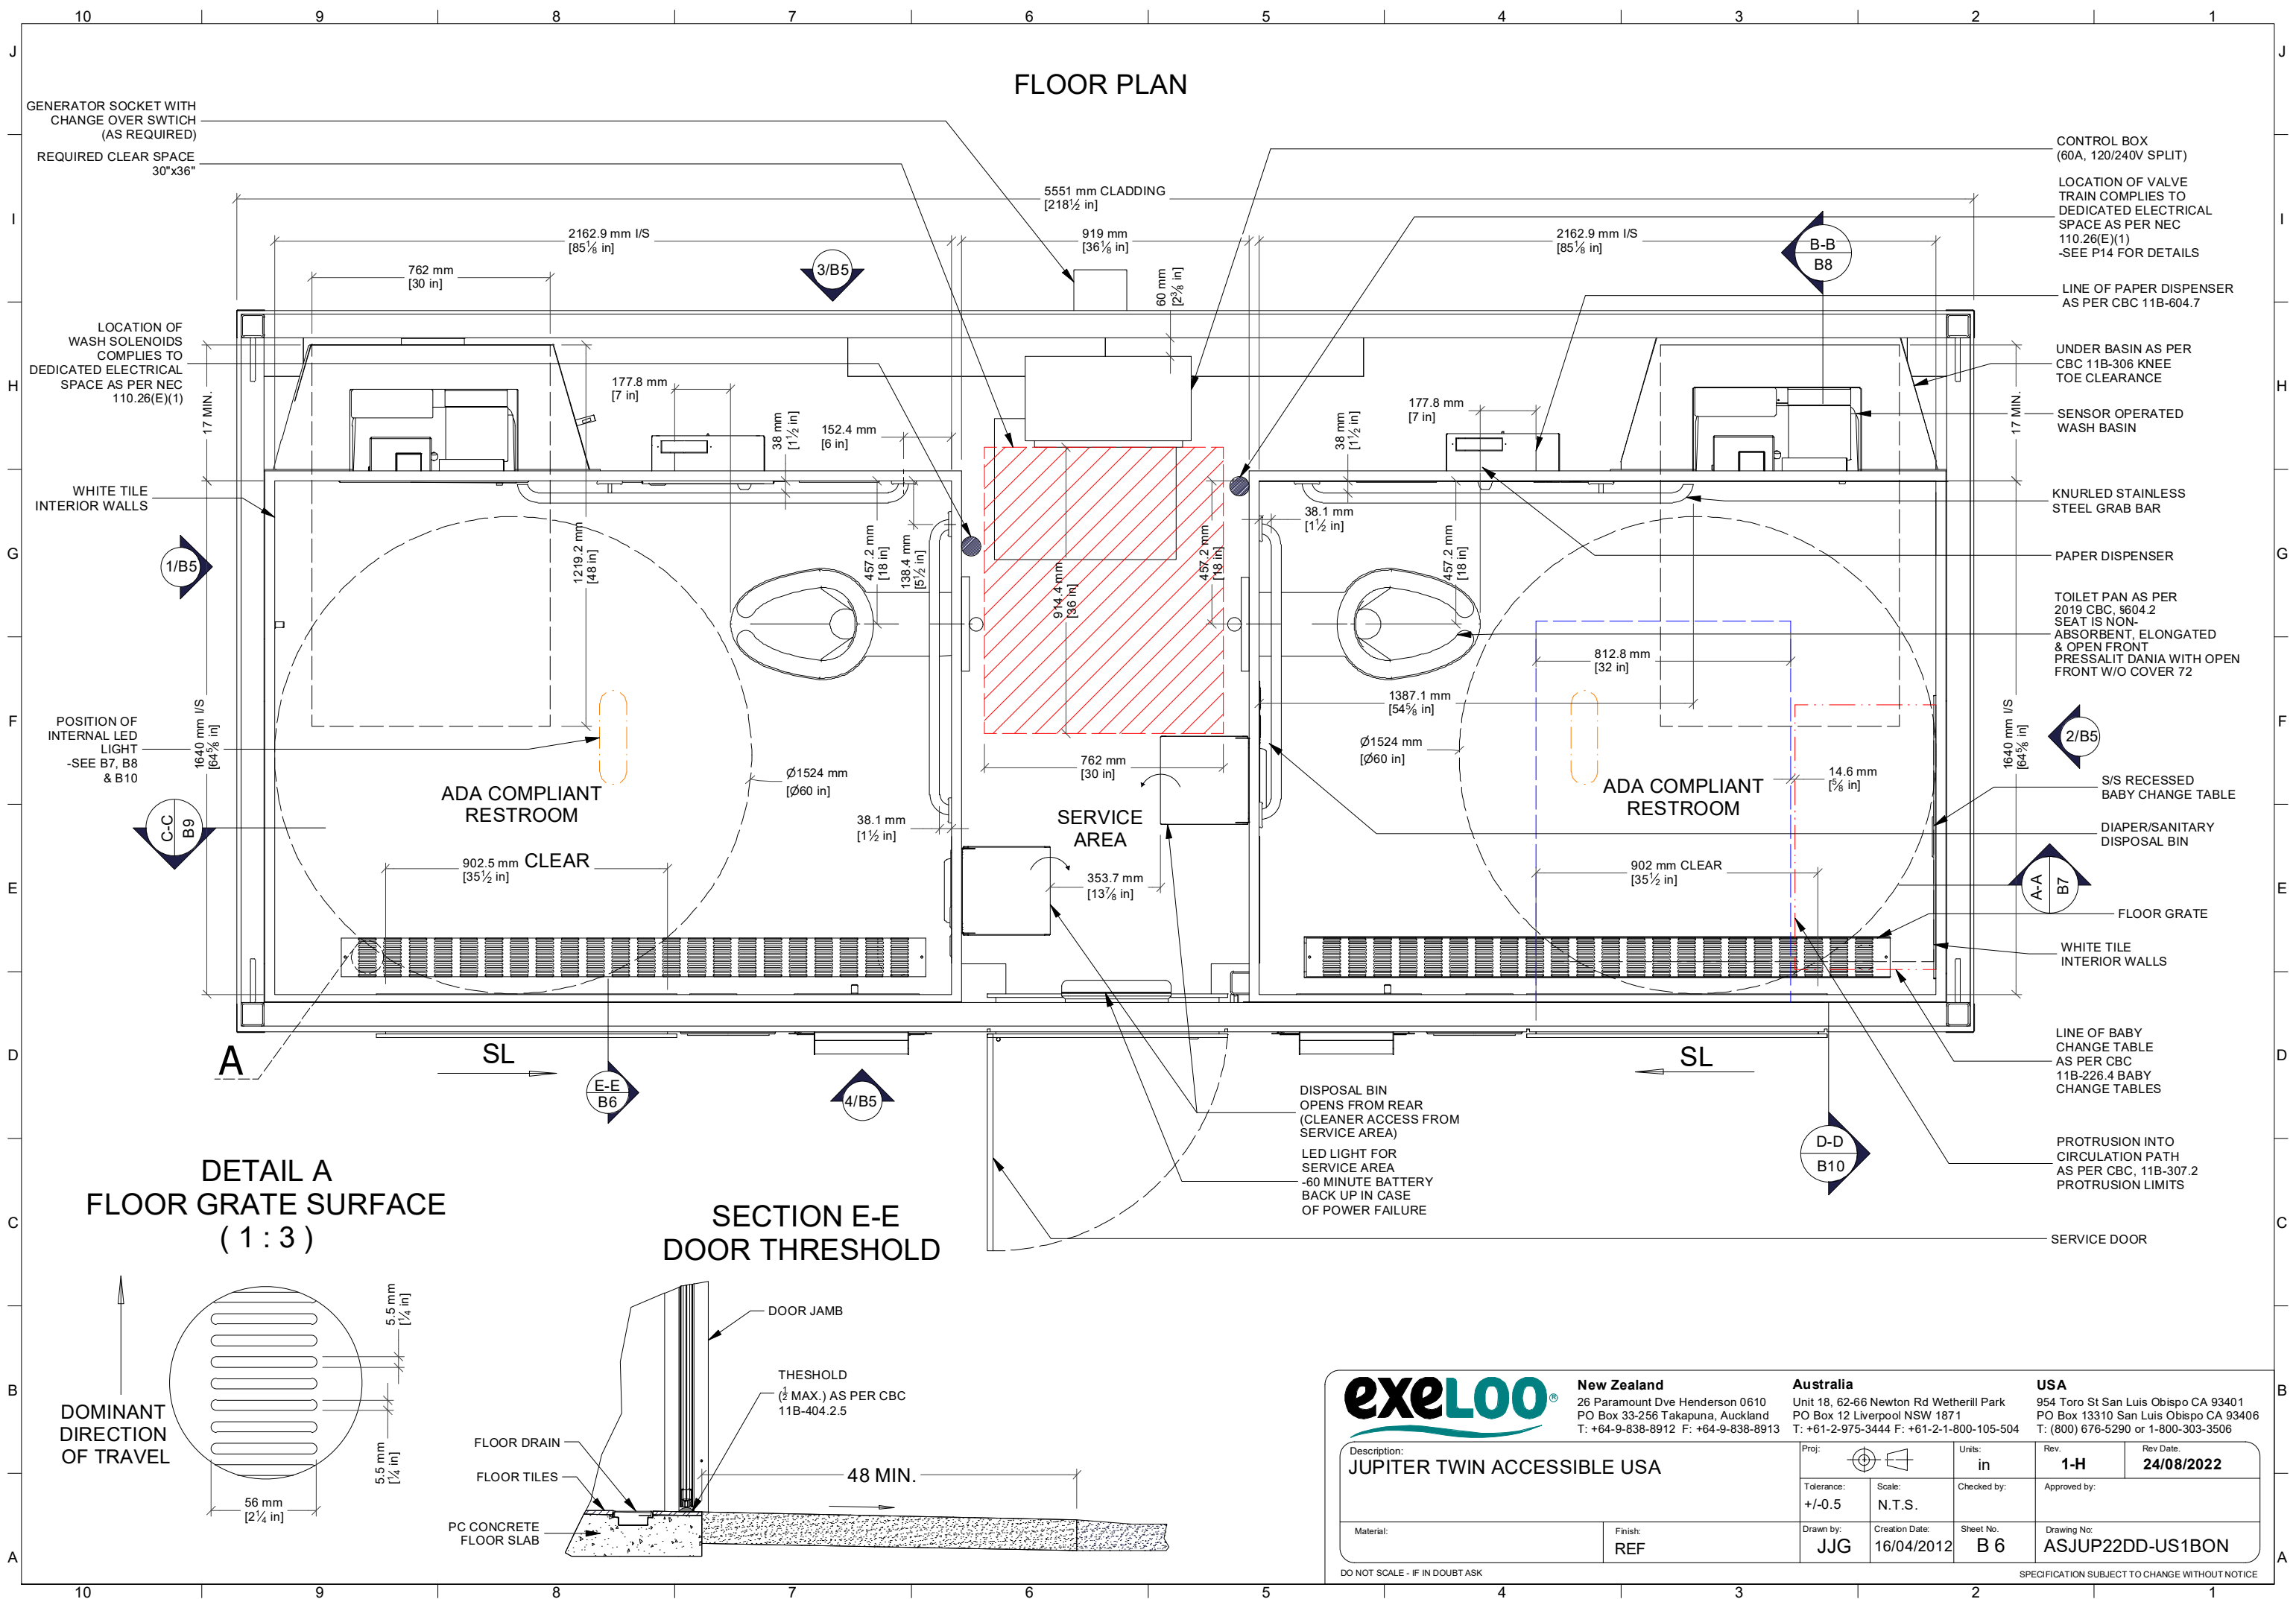

FLOOR PLAN

DETAIL A
FLOOR GRATE SURFACE
(1 : 3)

SECTION E-E
DOOR THRESHOLD

exelOO
New Zealand
26 Paramount Dve Henderson 0610
PO Box 33-256 Takapuna, Auckland
T: +64-9-838-8912 F: +64-9-838-8913


Australia
Unit 18, 62-66 Newton Rd Wetherill Park
PO Box 12 Liverpool NSW 1871
T: +61-2-975-3444 F: +61-2-1-800-105-504

USA
954 Toro St San Luis Obispo CA 93401
PO Box 13310 San Luis Obispo CA 93406
T: (800) 676-5290 or 1-800-303-3506

Description: JUPITER TWIN ACCESSIBLE USA		Proj: 	Units: in	Rev: 1-H	Rev Date: 24/08/2022
Tolerance: +/-0.5	Scale: N.T.S.	Checked by:	Approved by:		
Material:	Finish: REF	Drawn by: JJG	Creation Date: 16/04/2012	Sheet No: B 6	Drawing No: ASJUP22DD-US1BON

DO NOT SCALE - IF IN DOUBT ASK

SPECIFICATION SUBJECT TO CHANGE WITHOUT NOTICE

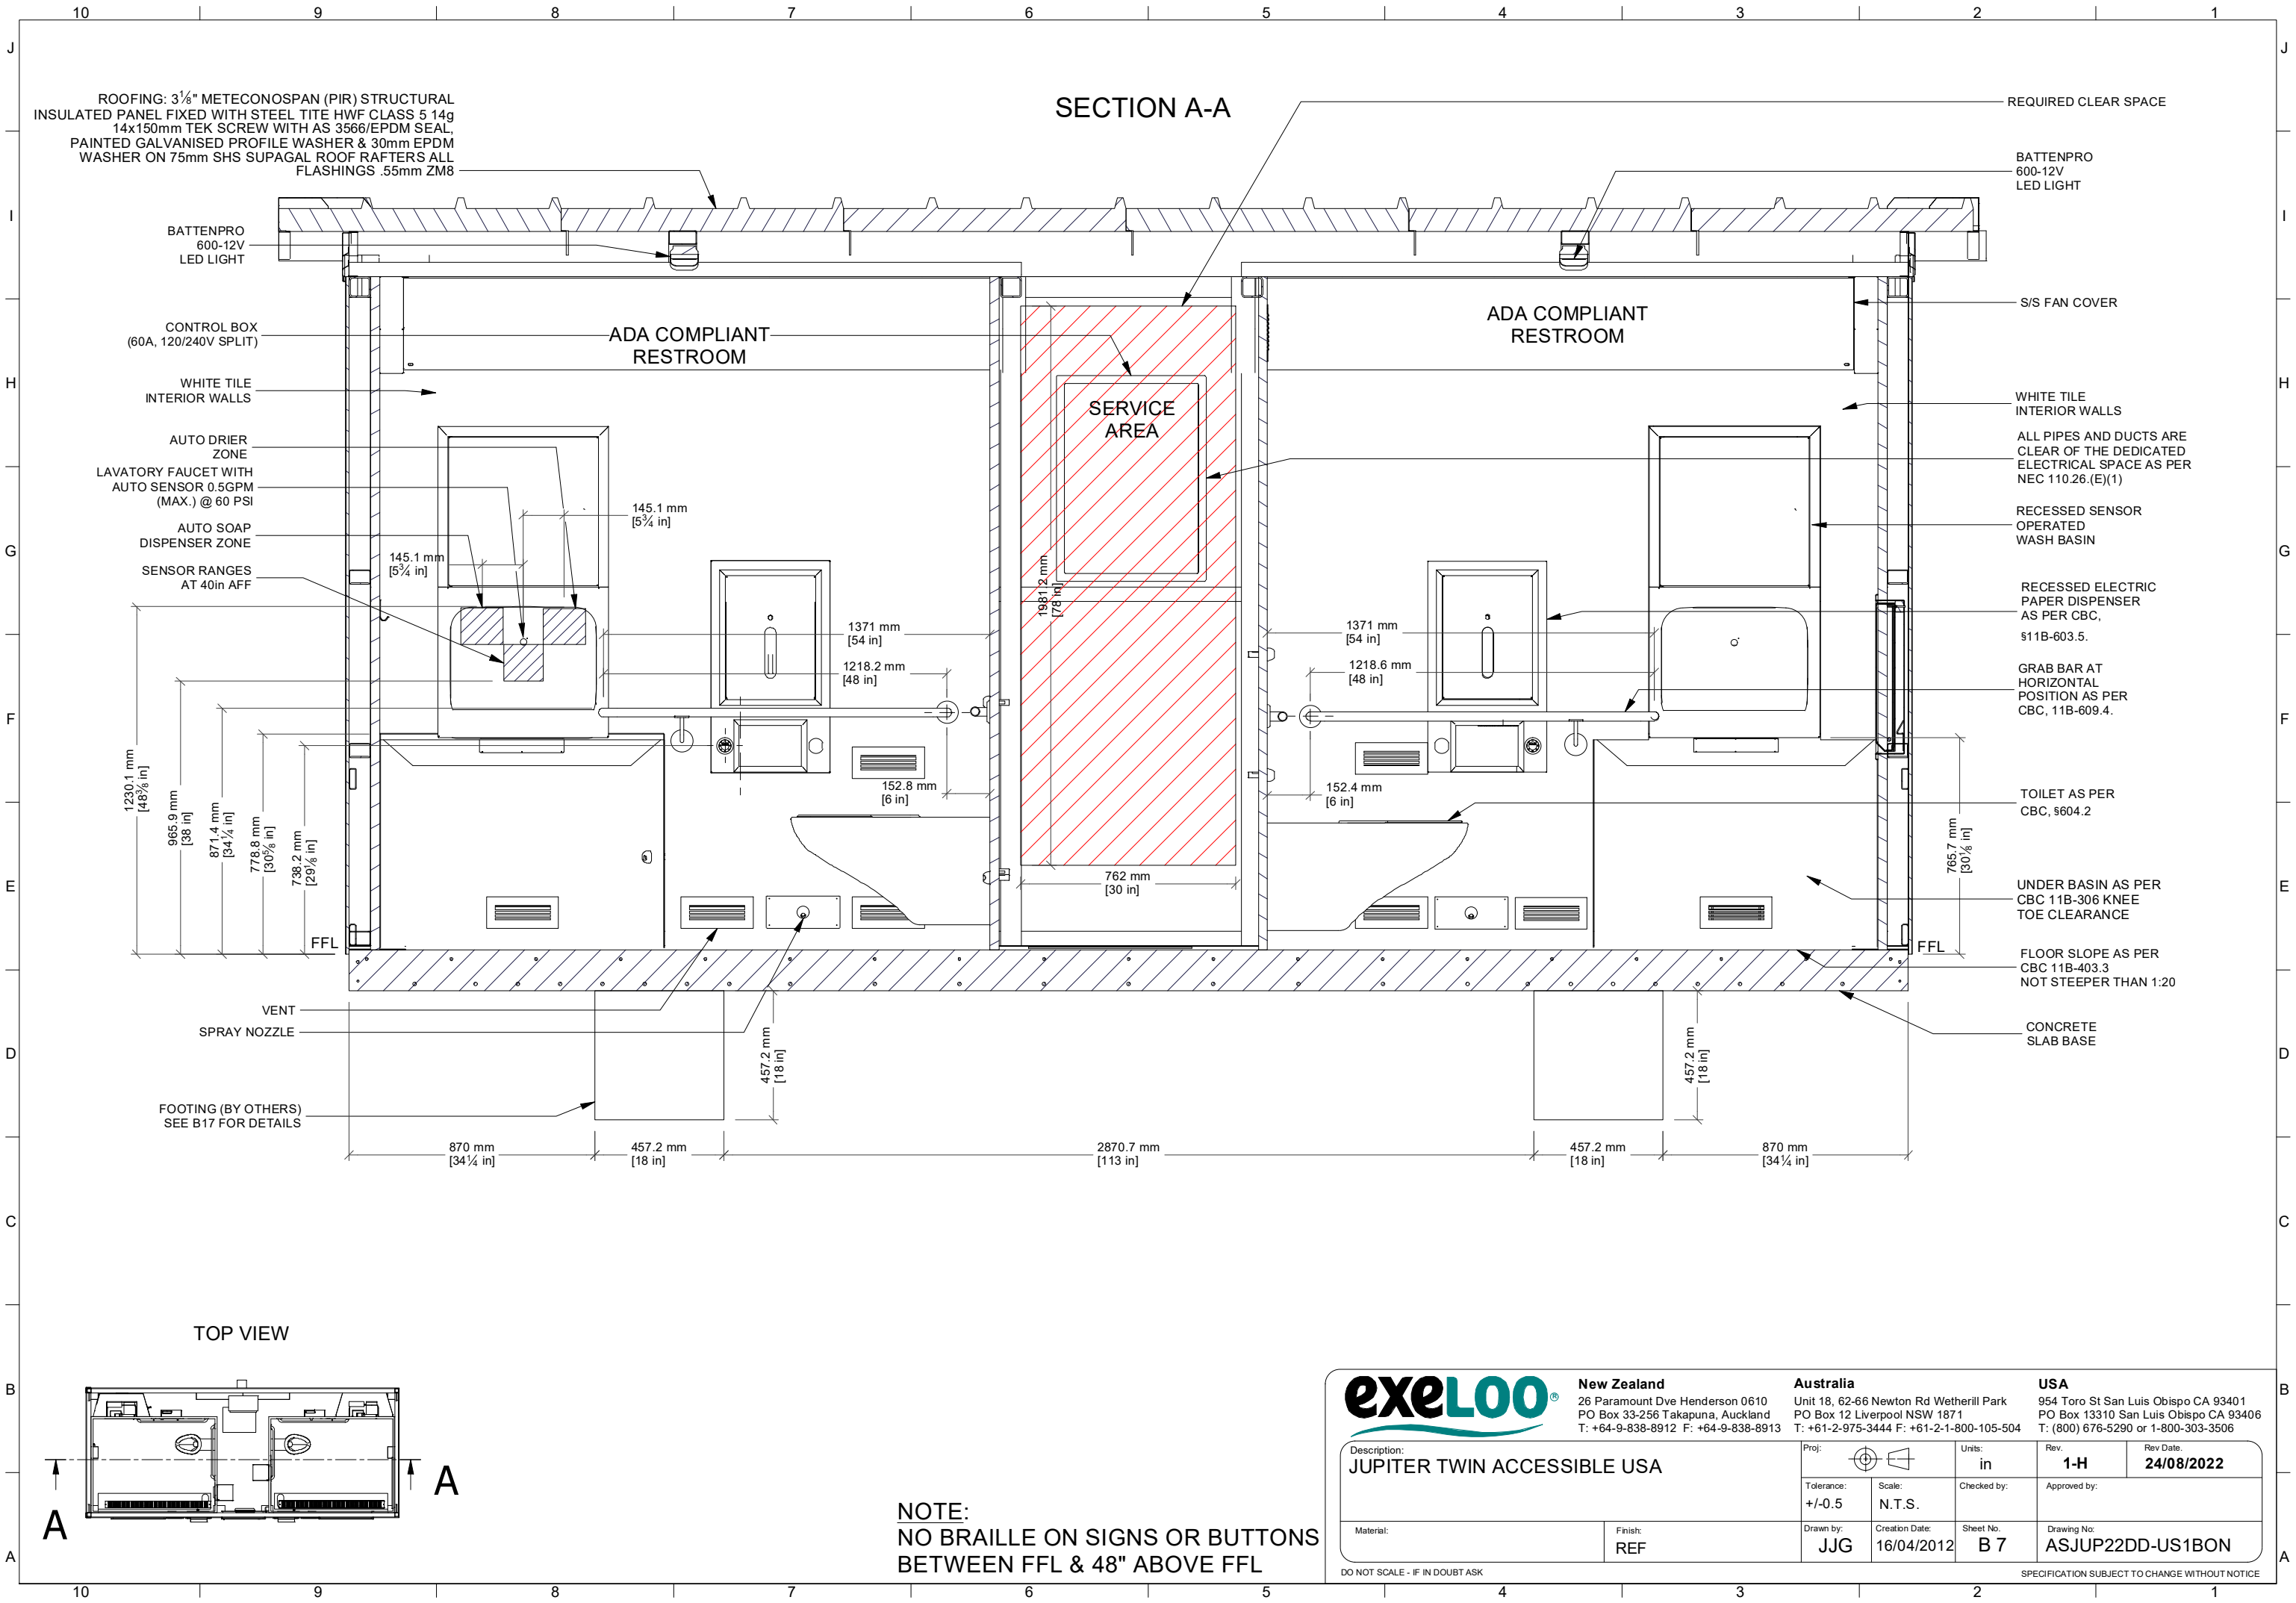

SECTION A-A

REQUIRED CLEAR SPACE

BATTENPRO
600-12V
LED LIGHT

S/S FAN COVER

WHITE TILE
INTERIOR WALLS

ALL PIPES AND DUCTS ARE
CLEAR OF THE DEDICATED
ELECTRICAL SPACE AS PER
NEC 110.26.(E)(1)

RECESSED SENSOR
OPERATED
WASH BASIN

RECESSED ELECTRIC
PAPER DISPENSER
AS PER CBC,
§11B-603.5.

GRAB BAR AT
HORIZONTAL
POSITION AS PER
CBC, 11B-609.4.

TOILET AS PER
CBC, §604.2

UNDER BASIN AS PER
CBC 11B-306 KNEE
TOE CLEARANCE

FLOOR SLOPE AS PER
CBC 11B-403.3
NOT STEEPER THAN 1:20

CONCRETE
SLAB BASE

ADA COMPLIANT
RESTROOM

ADA COMPLIANT
RESTROOM

SERVICE
AREA

ROOFING: 3/8" METECONOSPAN (PIR) STRUCTURAL
INSULATED PANEL FIXED WITH STEEL TITE HWF CLASS 5 14g
14x150mm TEK SCREW WITH AS 3566/EPDM SEAL,
PAINTED GALVANISED PROFILE WASHER & 30mm EPDM
WASHER ON 75mm SHS SUPAGAL ROOF RAFTERS ALL
FLASHINGS .55mm ZM8

BATTENPRO
600-12V
LED LIGHT

CONTROL BOX
(60A, 120/240V SPLIT)

WHITE TILE
INTERIOR WALLS

AUTO DRIER
ZONE
LAVATORY FAUCET WITH
AUTO SENSOR 0.5GPM
(MAX.) @ 60 PSI

AUTO SOAP
DISPENSER ZONE

SENSOR RANGES
AT 40in AFF

145.1 mm
[5 3/4 in]

145.1 mm
[5 3/4 in]

1371 mm
[54 in]

1218.2 mm
[48 in]

152.8 mm
[6 in]

457.2 mm
[18 in]

870 mm
[34 1/4 in]

457.2 mm
[18 in]

2870.7 mm
[113 in]

457.2 mm
[18 in]

870 mm
[34 1/4 in]

765.7 mm
[30 1/8 in]

457.2 mm
[18 in]

TOP VIEW

NOTE:
NO BRAILLE ON SIGNS OR BUTTONS
BETWEEN FFL & 48" ABOVE FFL

exelOO

New Zealand
26 Paramount Dve Henderson 0610
PO Box 33-256 Takapuna, Auckland
T: +64-9-838-8912 F: +64-9-838-8913

Australia
Unit 18, 62-66 Newton Rd Wetherill Park
PO Box 12 Liverpool NSW 1871
T: +61-2-975-3444 F: +61-2-1-800-105-504

USA
954 Toro St San Luis Obispo CA 93401
PO Box 13310 San Luis Obispo CA 93406
T: (800) 676-5290 or 1-800-303-3506

Description:
JUPITER TWIN ACCESSIBLE USA

Material:

Finish:

REF

Proj:

Units:

in

Rev.

1-H

Rev Date:

24/08/2022

Tolerance:

+/-0.5

Scale:

N.T.S.

Checked by:

Approved by:

Drawn by:

JJG

Creation Date:

16/04/2012

Sheet No.


B 7


Drawing No:


ASJUP22DD-US1BON


DO NOT SCALE - IF IN DOUBT ASK

SPECIFICATION SUBJECT TO CHANGE WITHOUT NOTICE

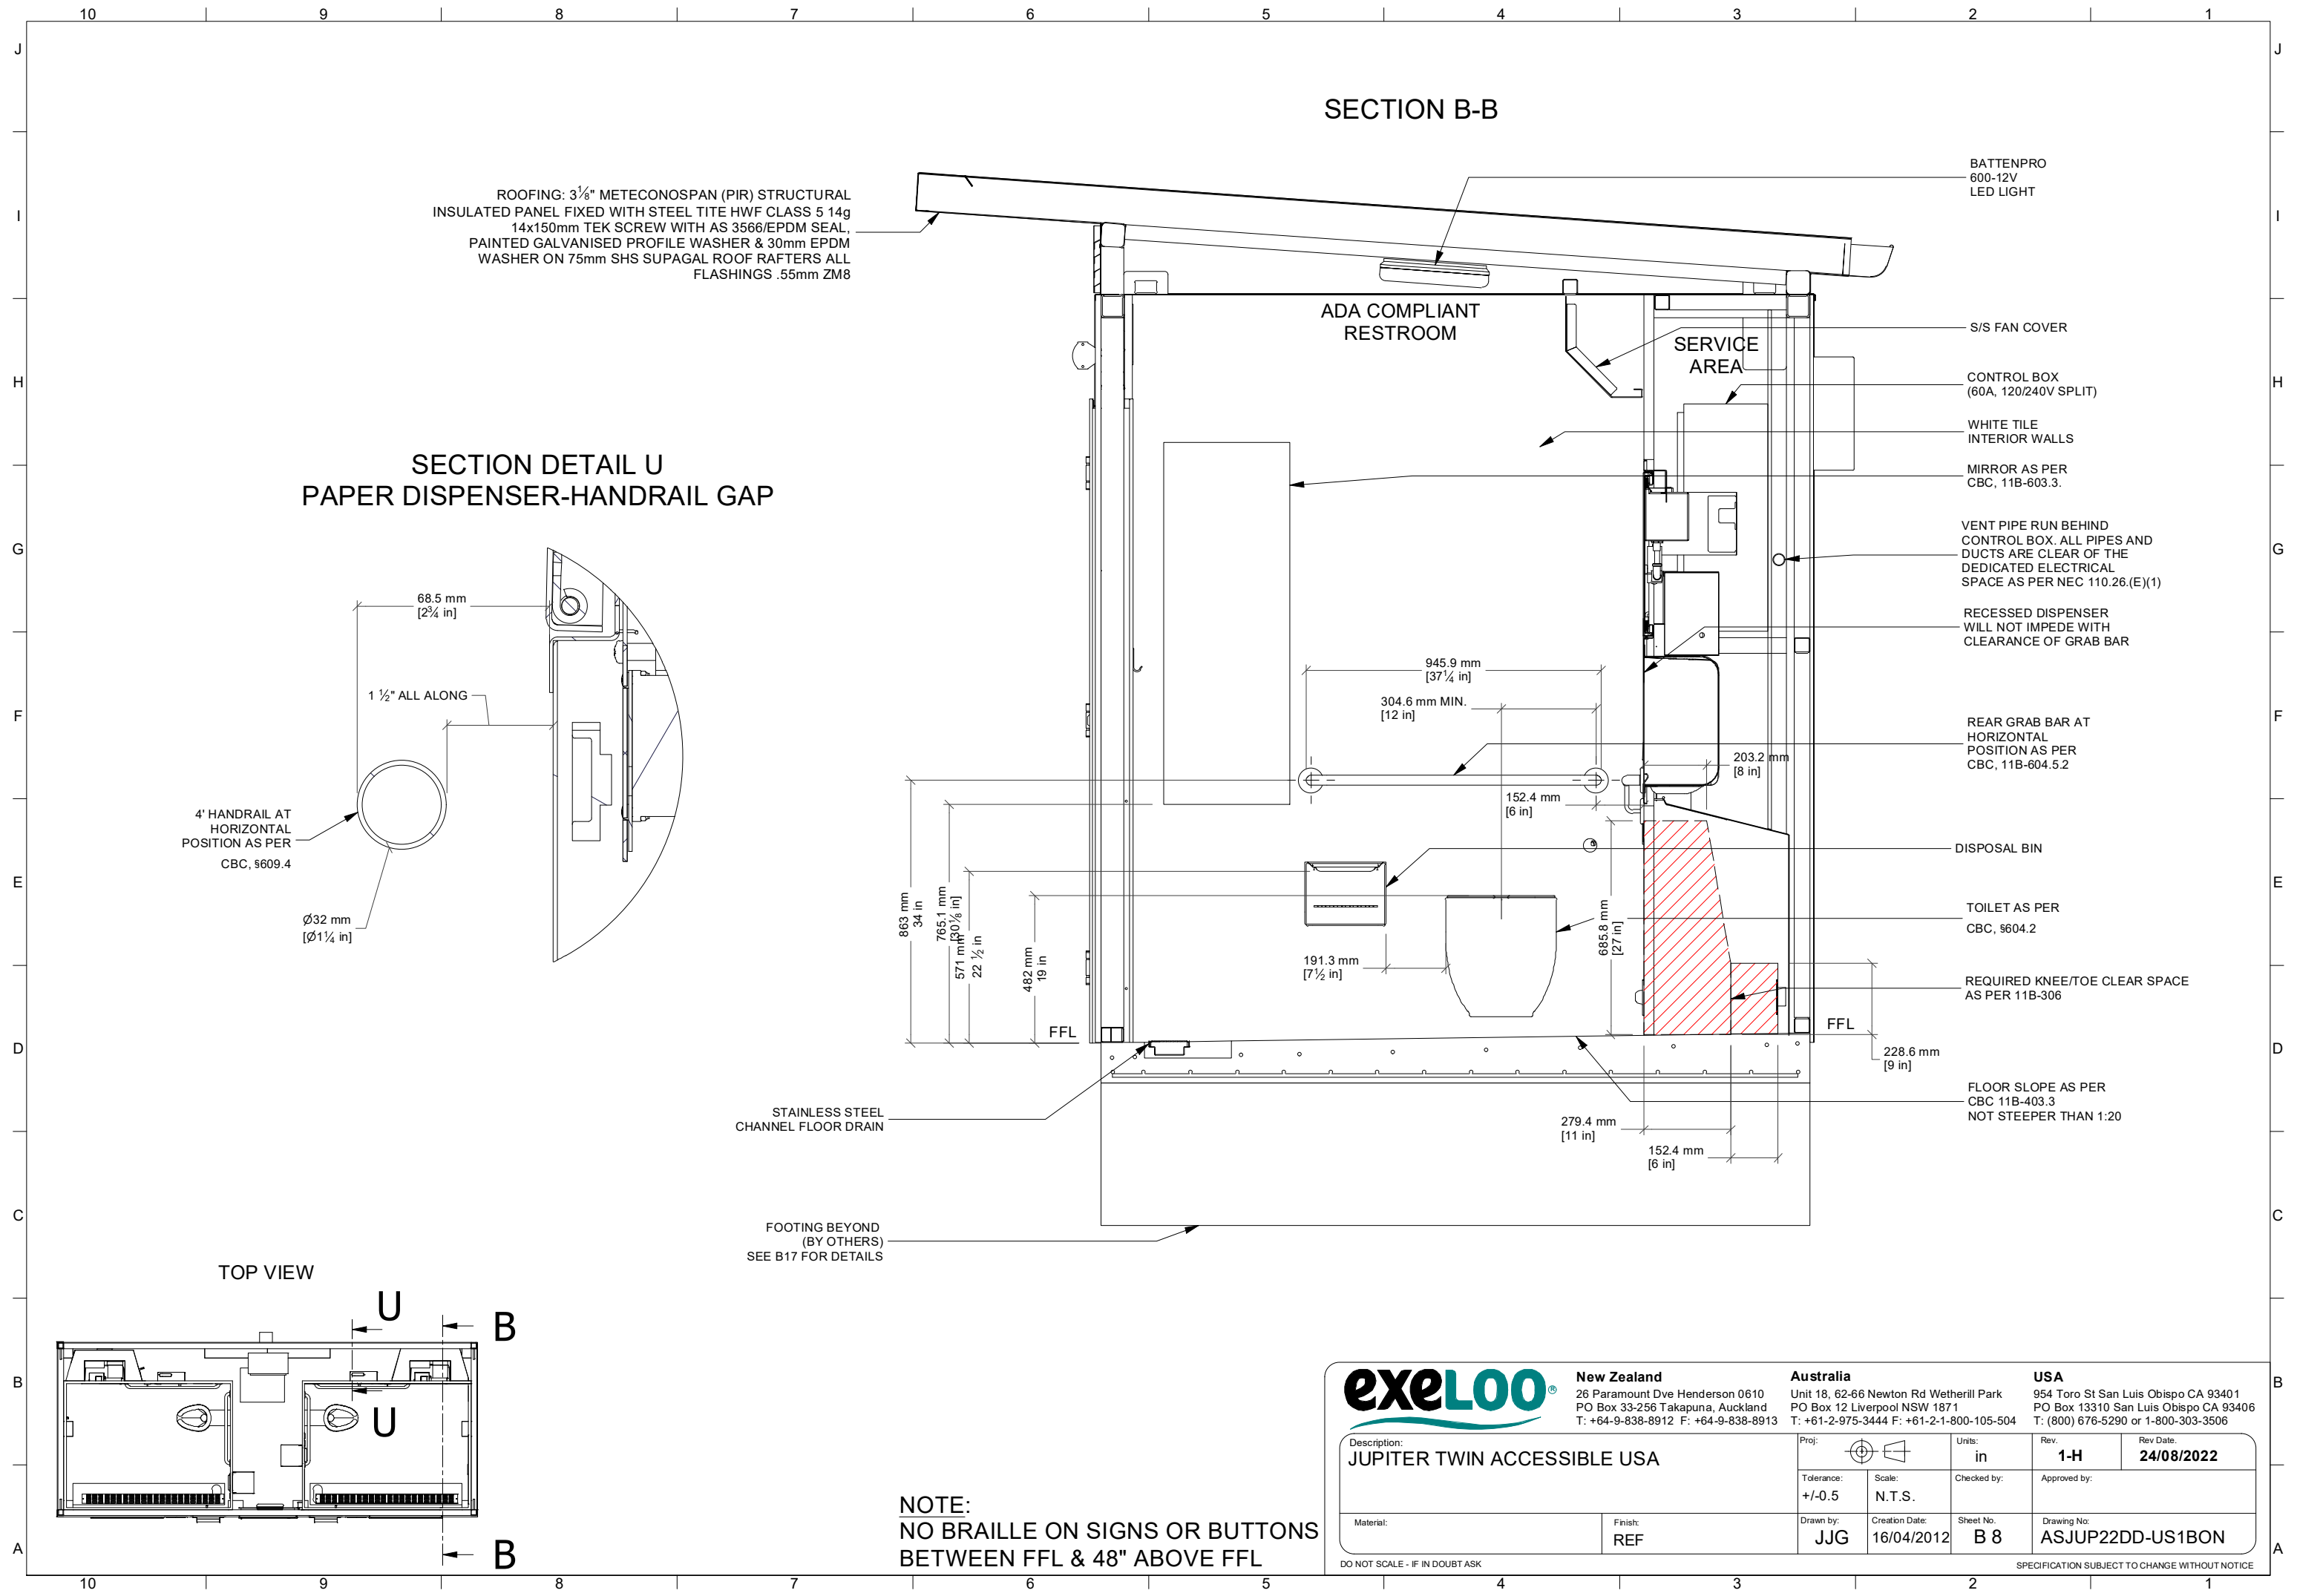

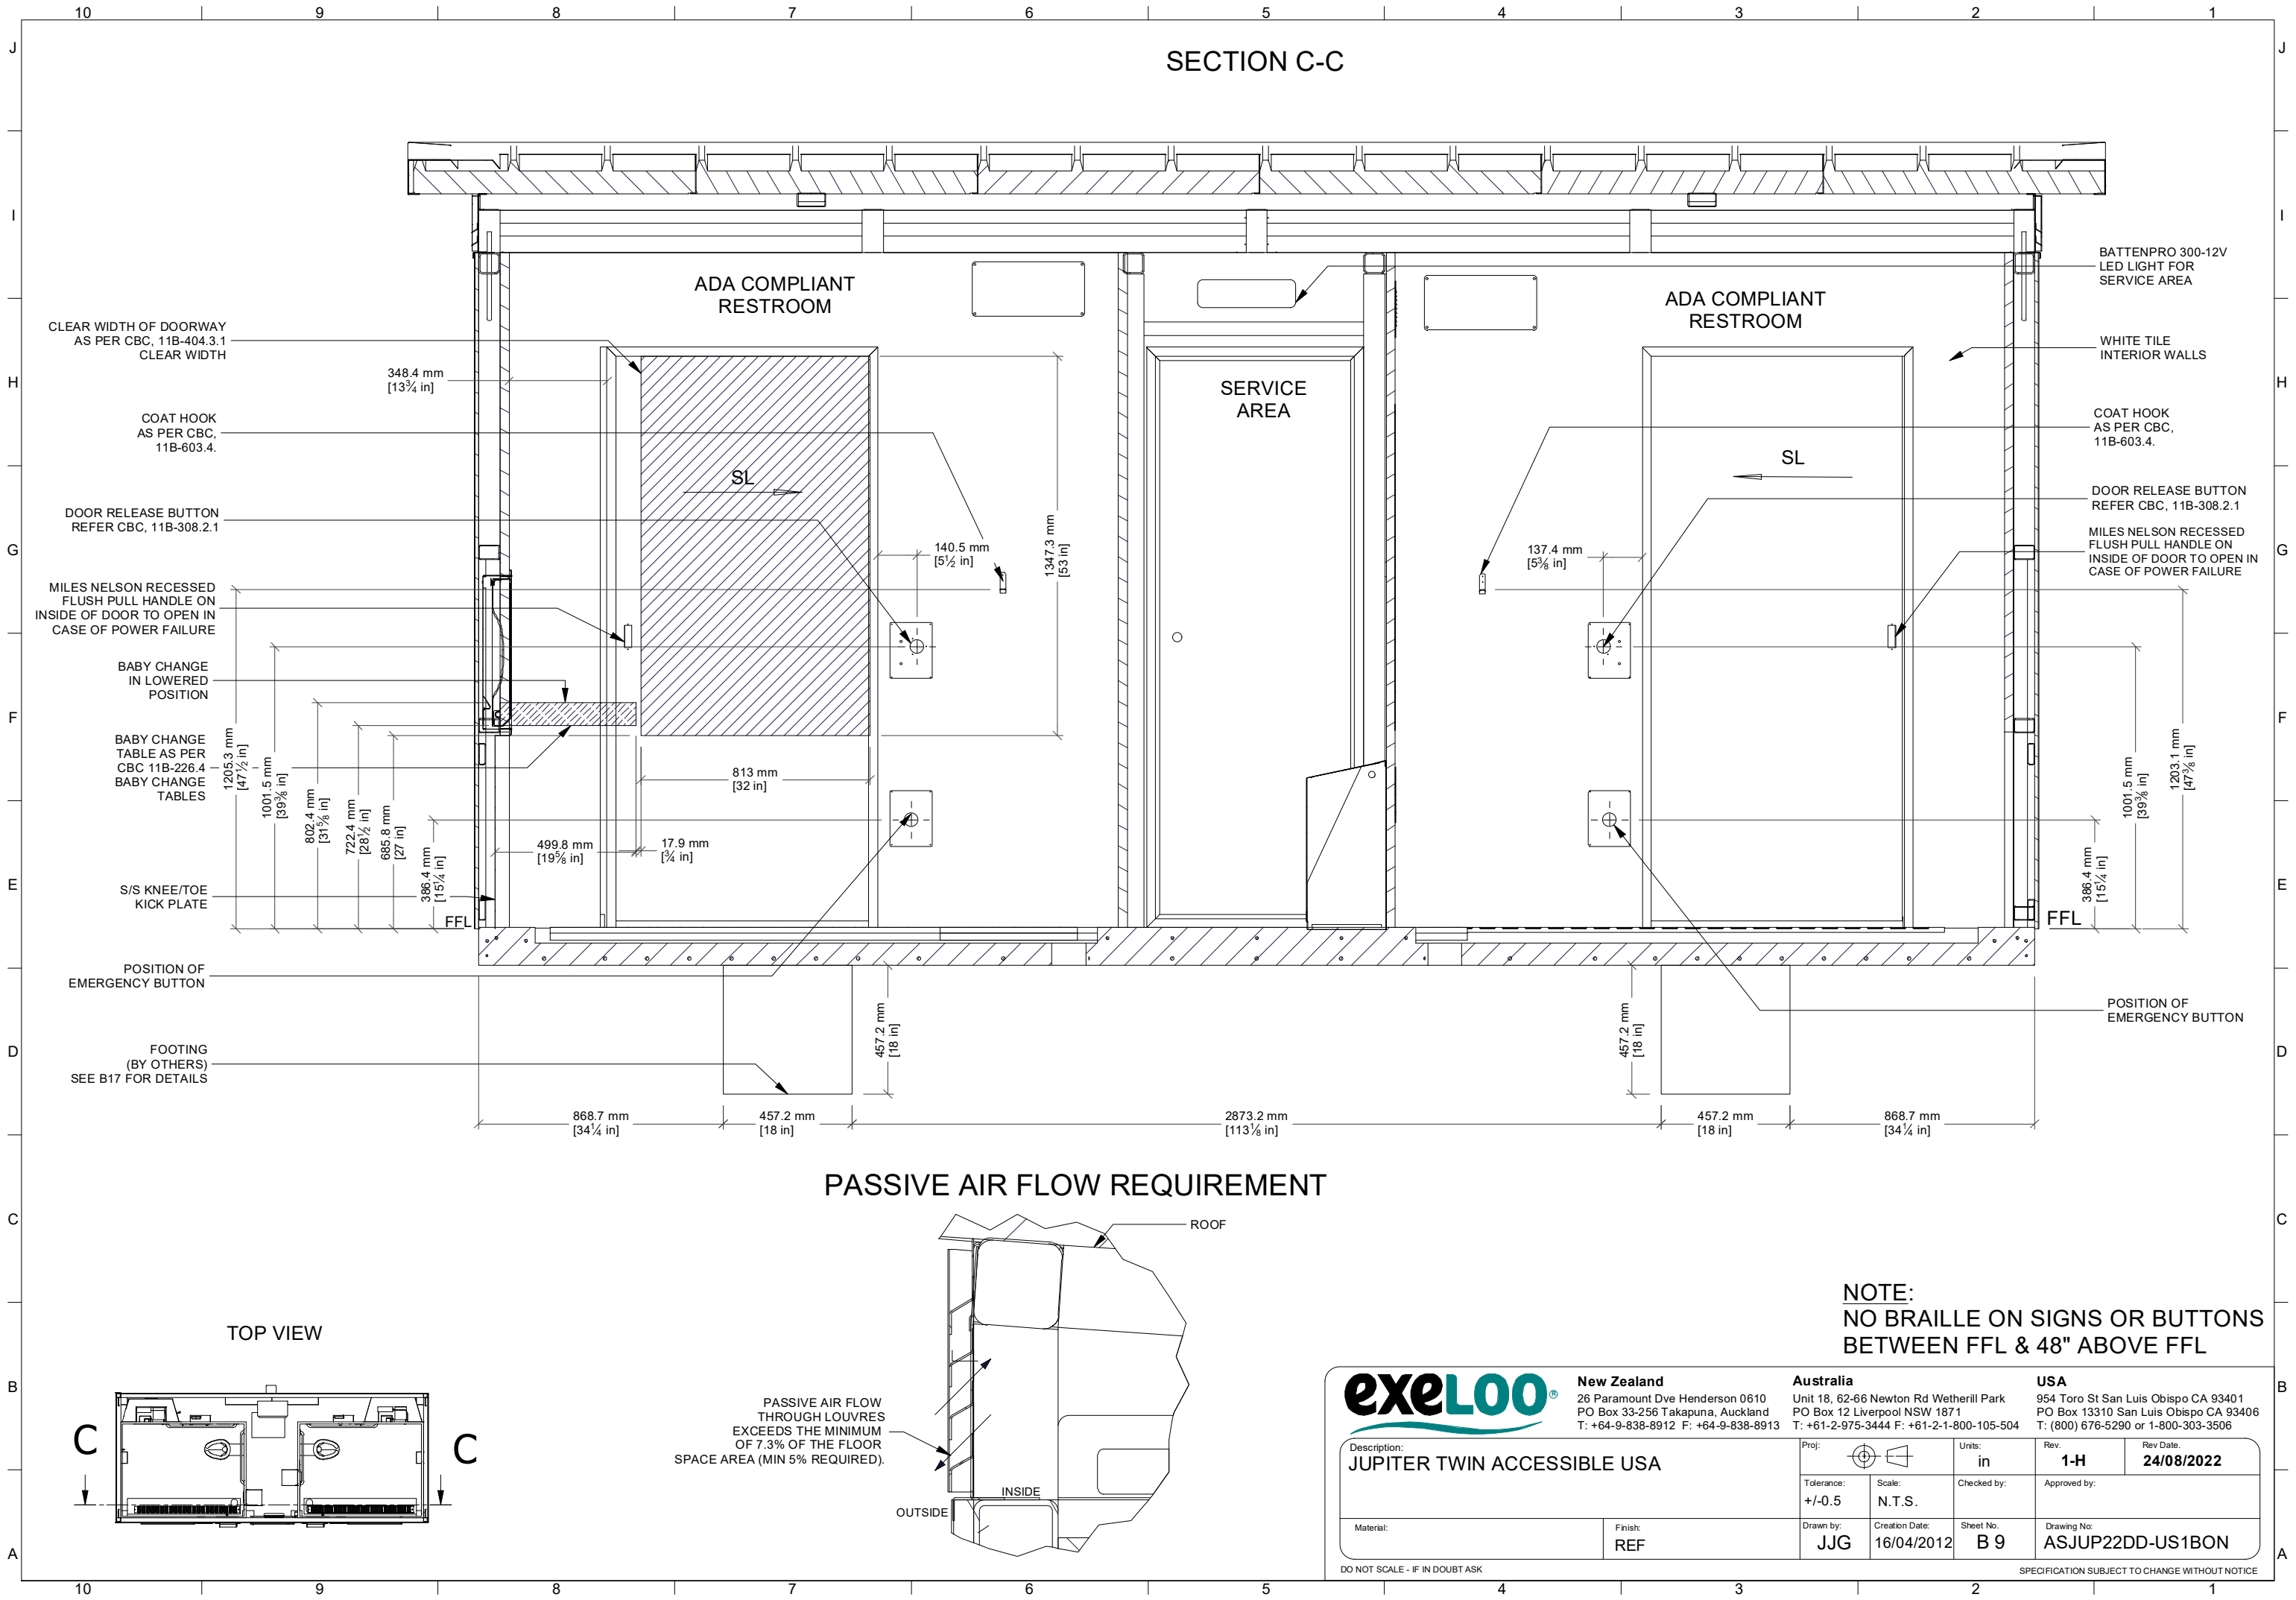

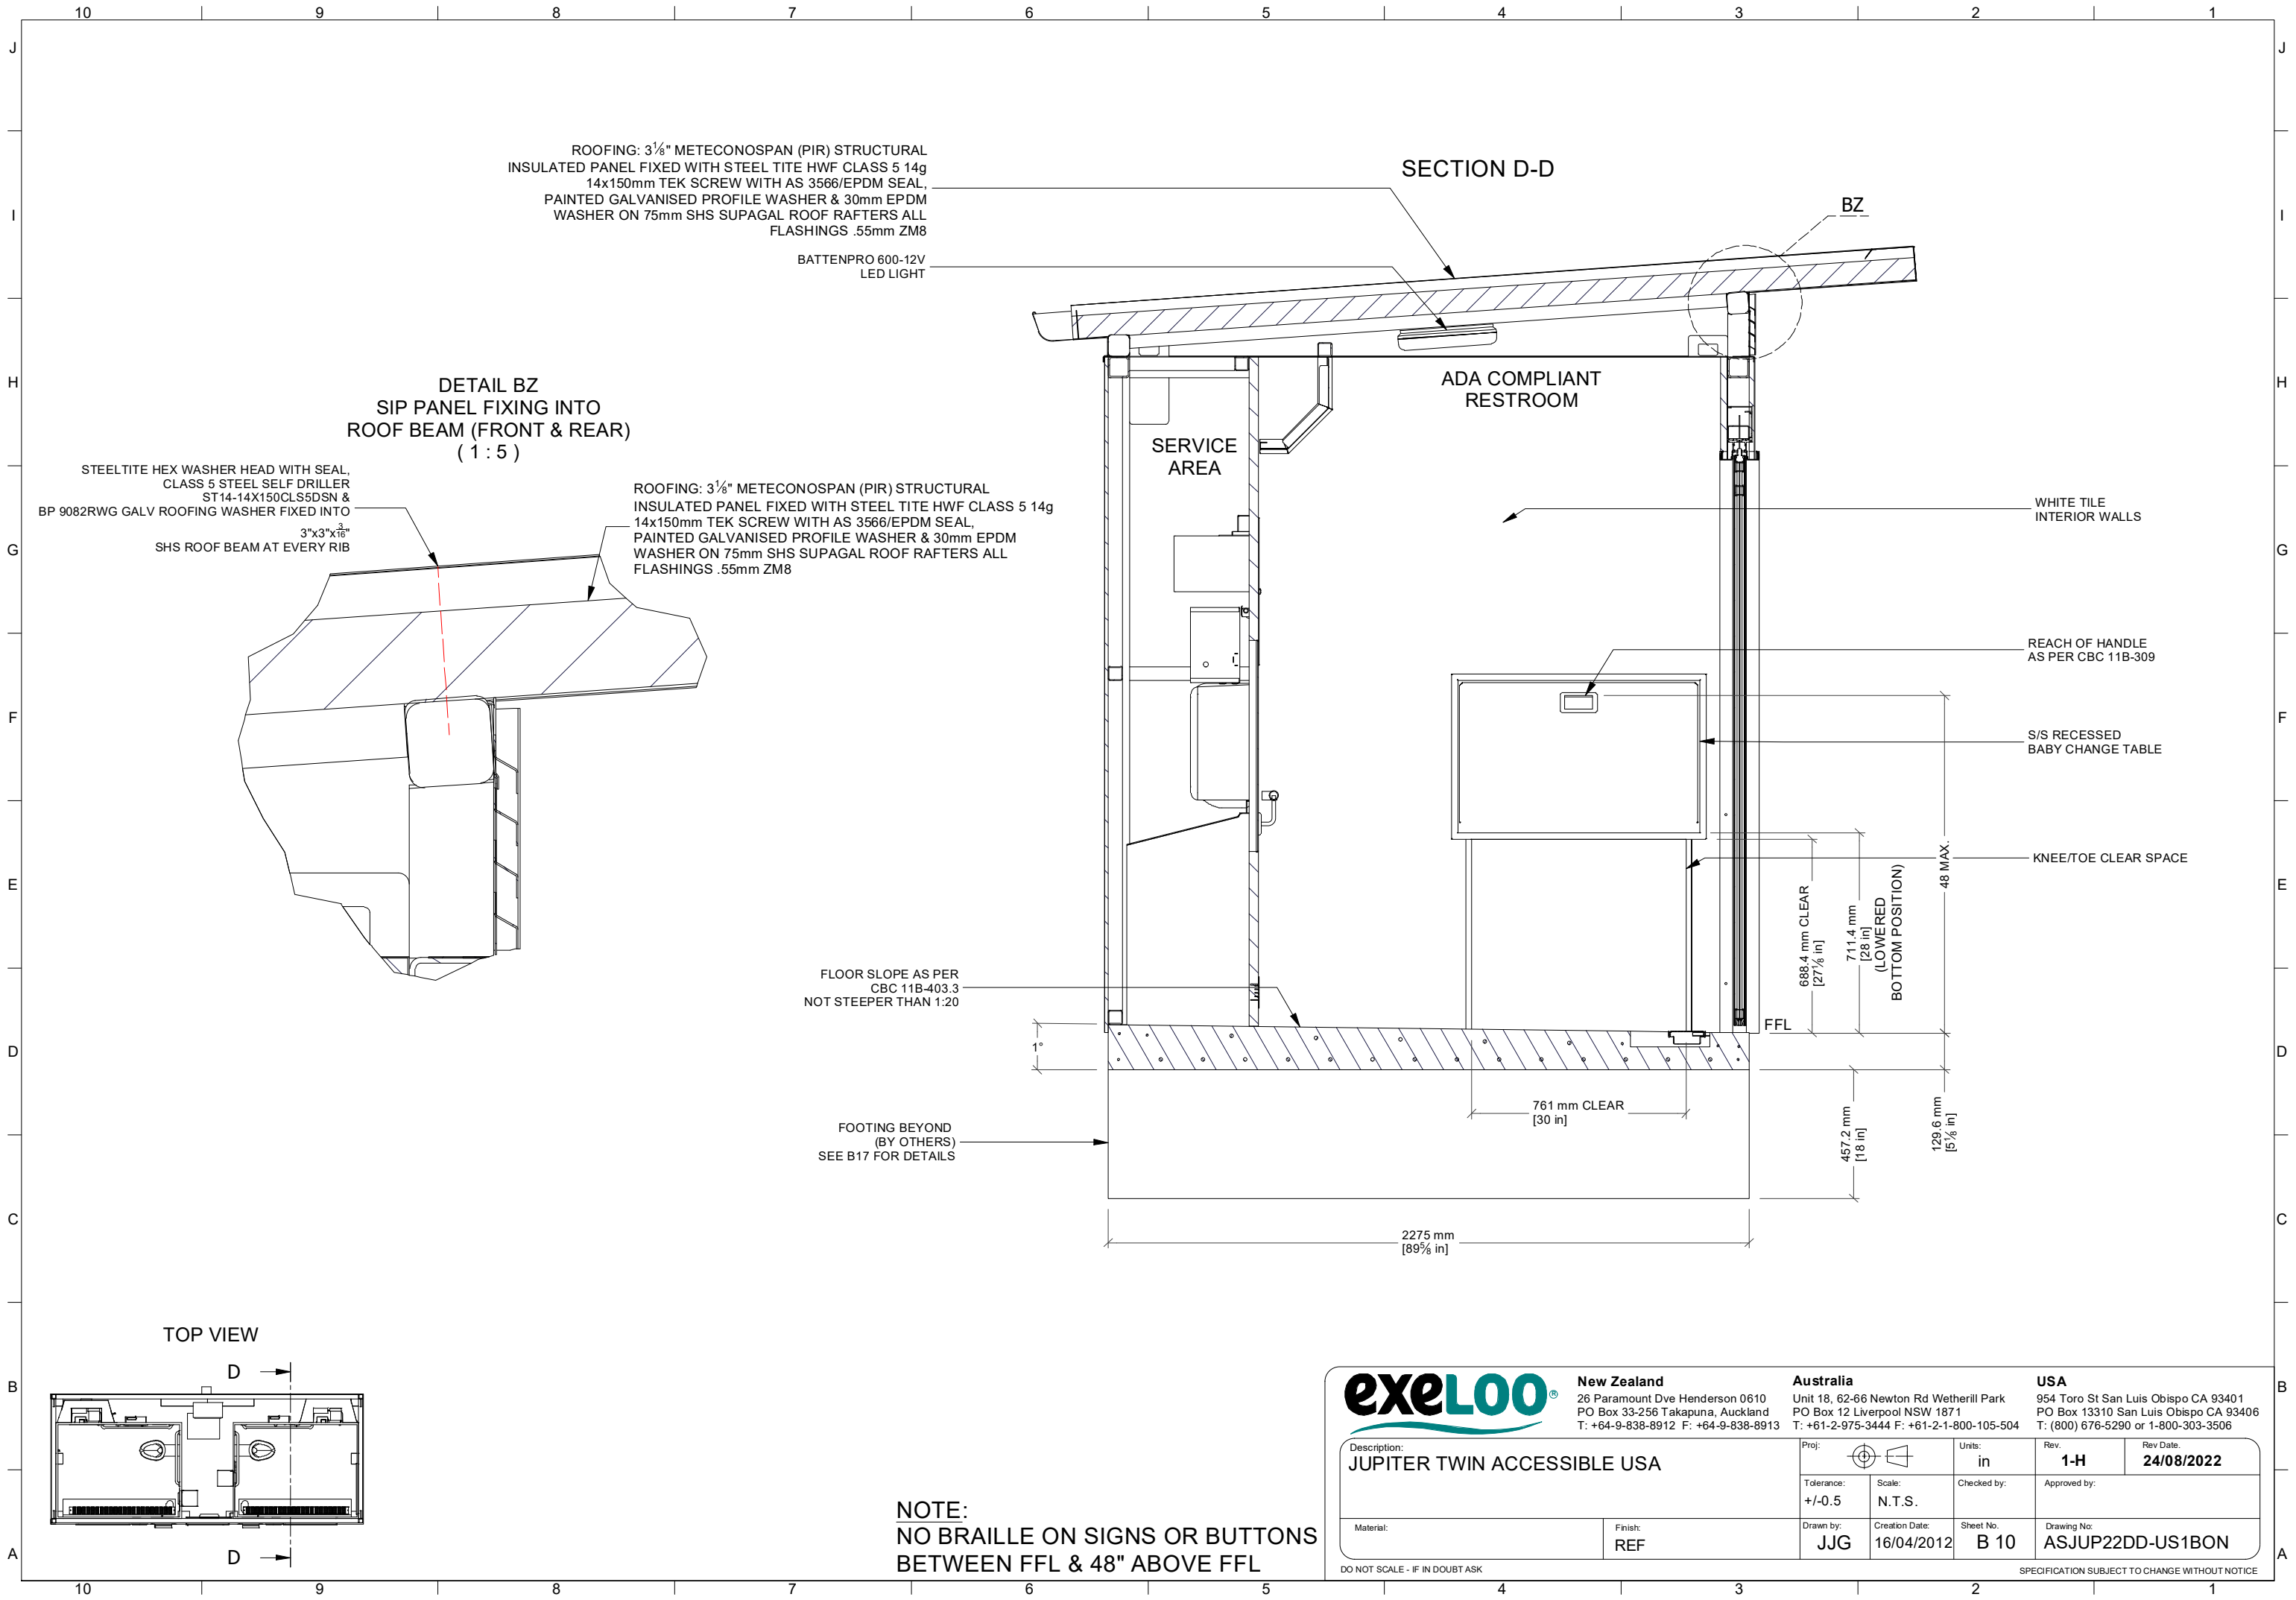

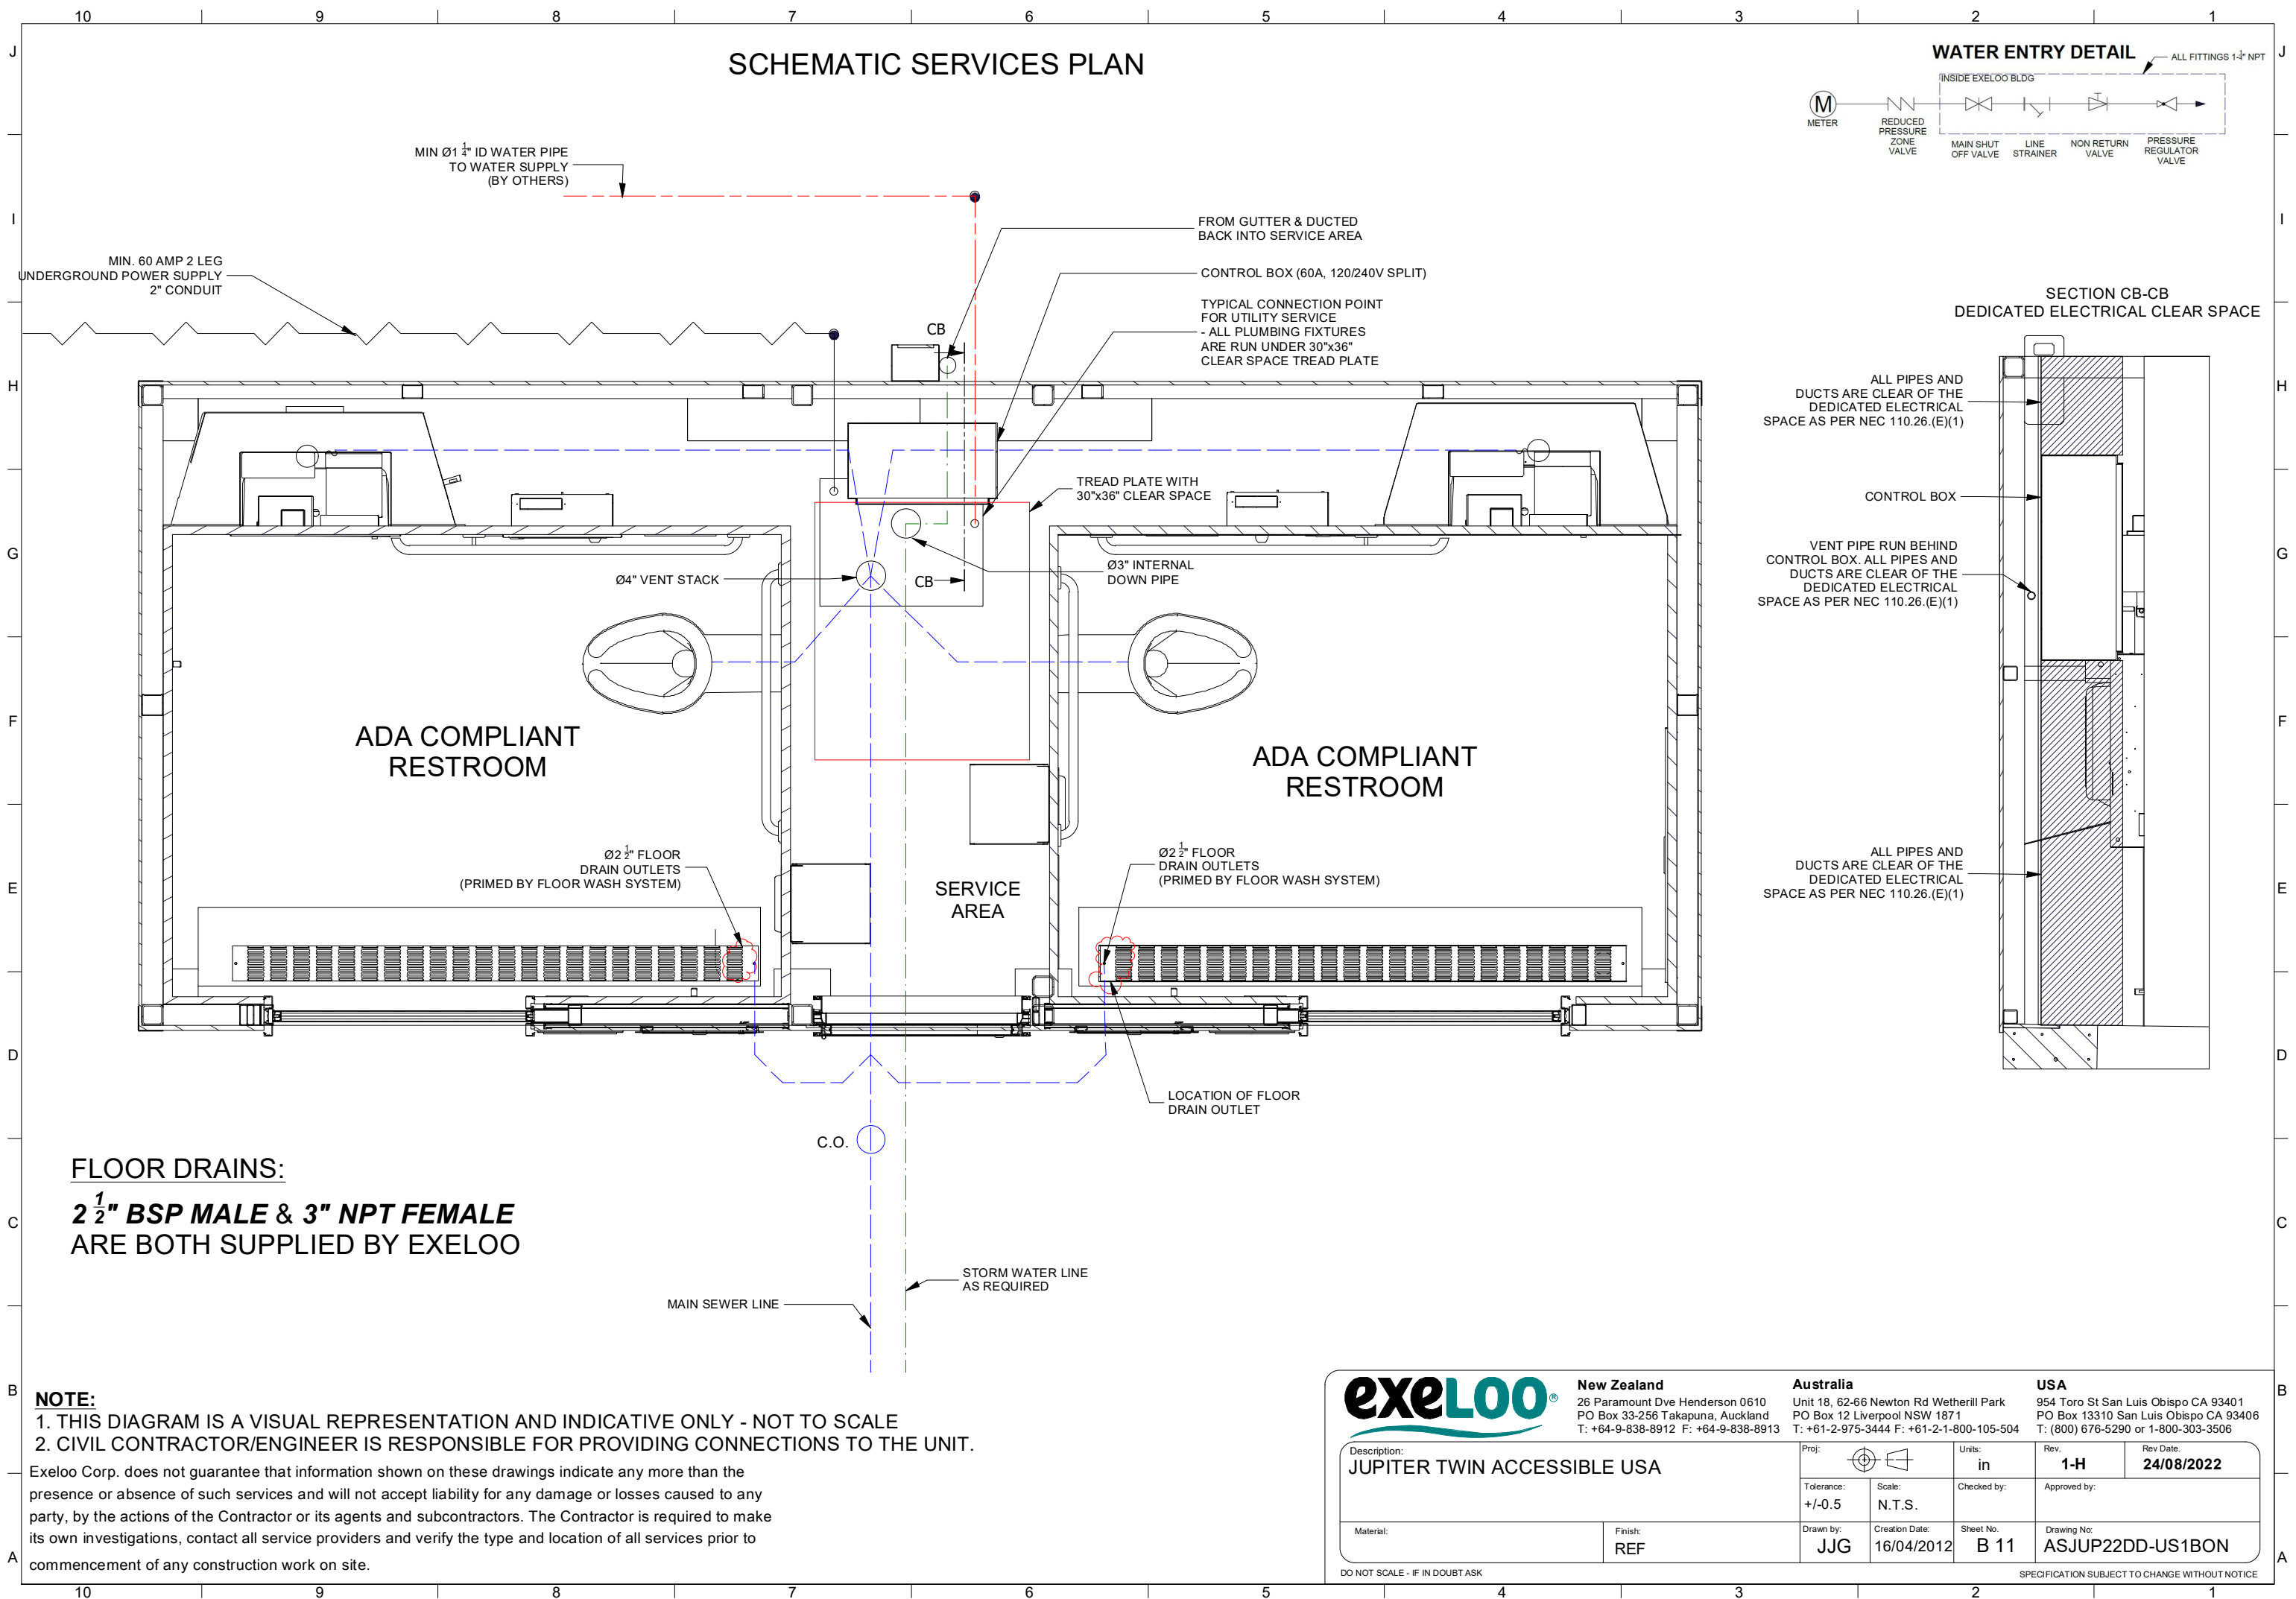

FLOOR DRAINS:
2 1/2" BSP MALE & 3" NPT FEMALE
ARE BOTH SUPPLIED BY EXELOO

NOTE:
1. THIS DIAGRAM IS A VISUAL REPRESENTATION AND INDICATIVE ONLY - NOT TO SCALE
2. CIVIL CONTRACTOR/ENGINEER IS RESPONSIBLE FOR PROVIDING CONNECTIONS TO THE UNIT.
Exeloo Corp. does not guarantee that information shown on these drawings indicate any more than the presence or absence of such services and will not accept liability for any damage or losses caused to any party, by the actions of the Contractor or its agents and subcontractors. The Contractor is required to make its own investigations, contact all service providers and verify the type and location of all services prior to commencement of any construction work on site.

exeloo[®]

New Zealand
26 Paramount Dve Henderson 0610
PO Box 33-256 Takapuna, Auckland
T: +64-9-838-8912 F: +64-9-838-8913


Australia
Unit 18, 62-66 Newton Rd Wetherill Park
PO Box 12 Liverpool NSW 1871
T: +61-2-975-3444 F: +61-2-1-800-105-504

USA
954 Toro St San Luis Obispo CA 93401
PO Box 13310 San Luis Obispo CA 93406
T: (800) 676-5290 or 1-800-303-3506

Description: JUPITER TWIN ACCESSIBLE USA		Proj: 	Units: in	Rev: 1-H	Rev Date: 24/08/2022
Tolerance: +/-0.5	Scale: N.T.S.	Checked by:	Approved by:		
Material:	Finish: REF	Drawn by: JJG	Creation Date: 16/04/2012	Sheet No: B 11	Drawing No: ASJUP22DD-US1BON

DO NOT SCALE - IF IN DOUBT ASK

SPECIFICATION SUBJECT TO CHANGE WITHOUT NOTICE

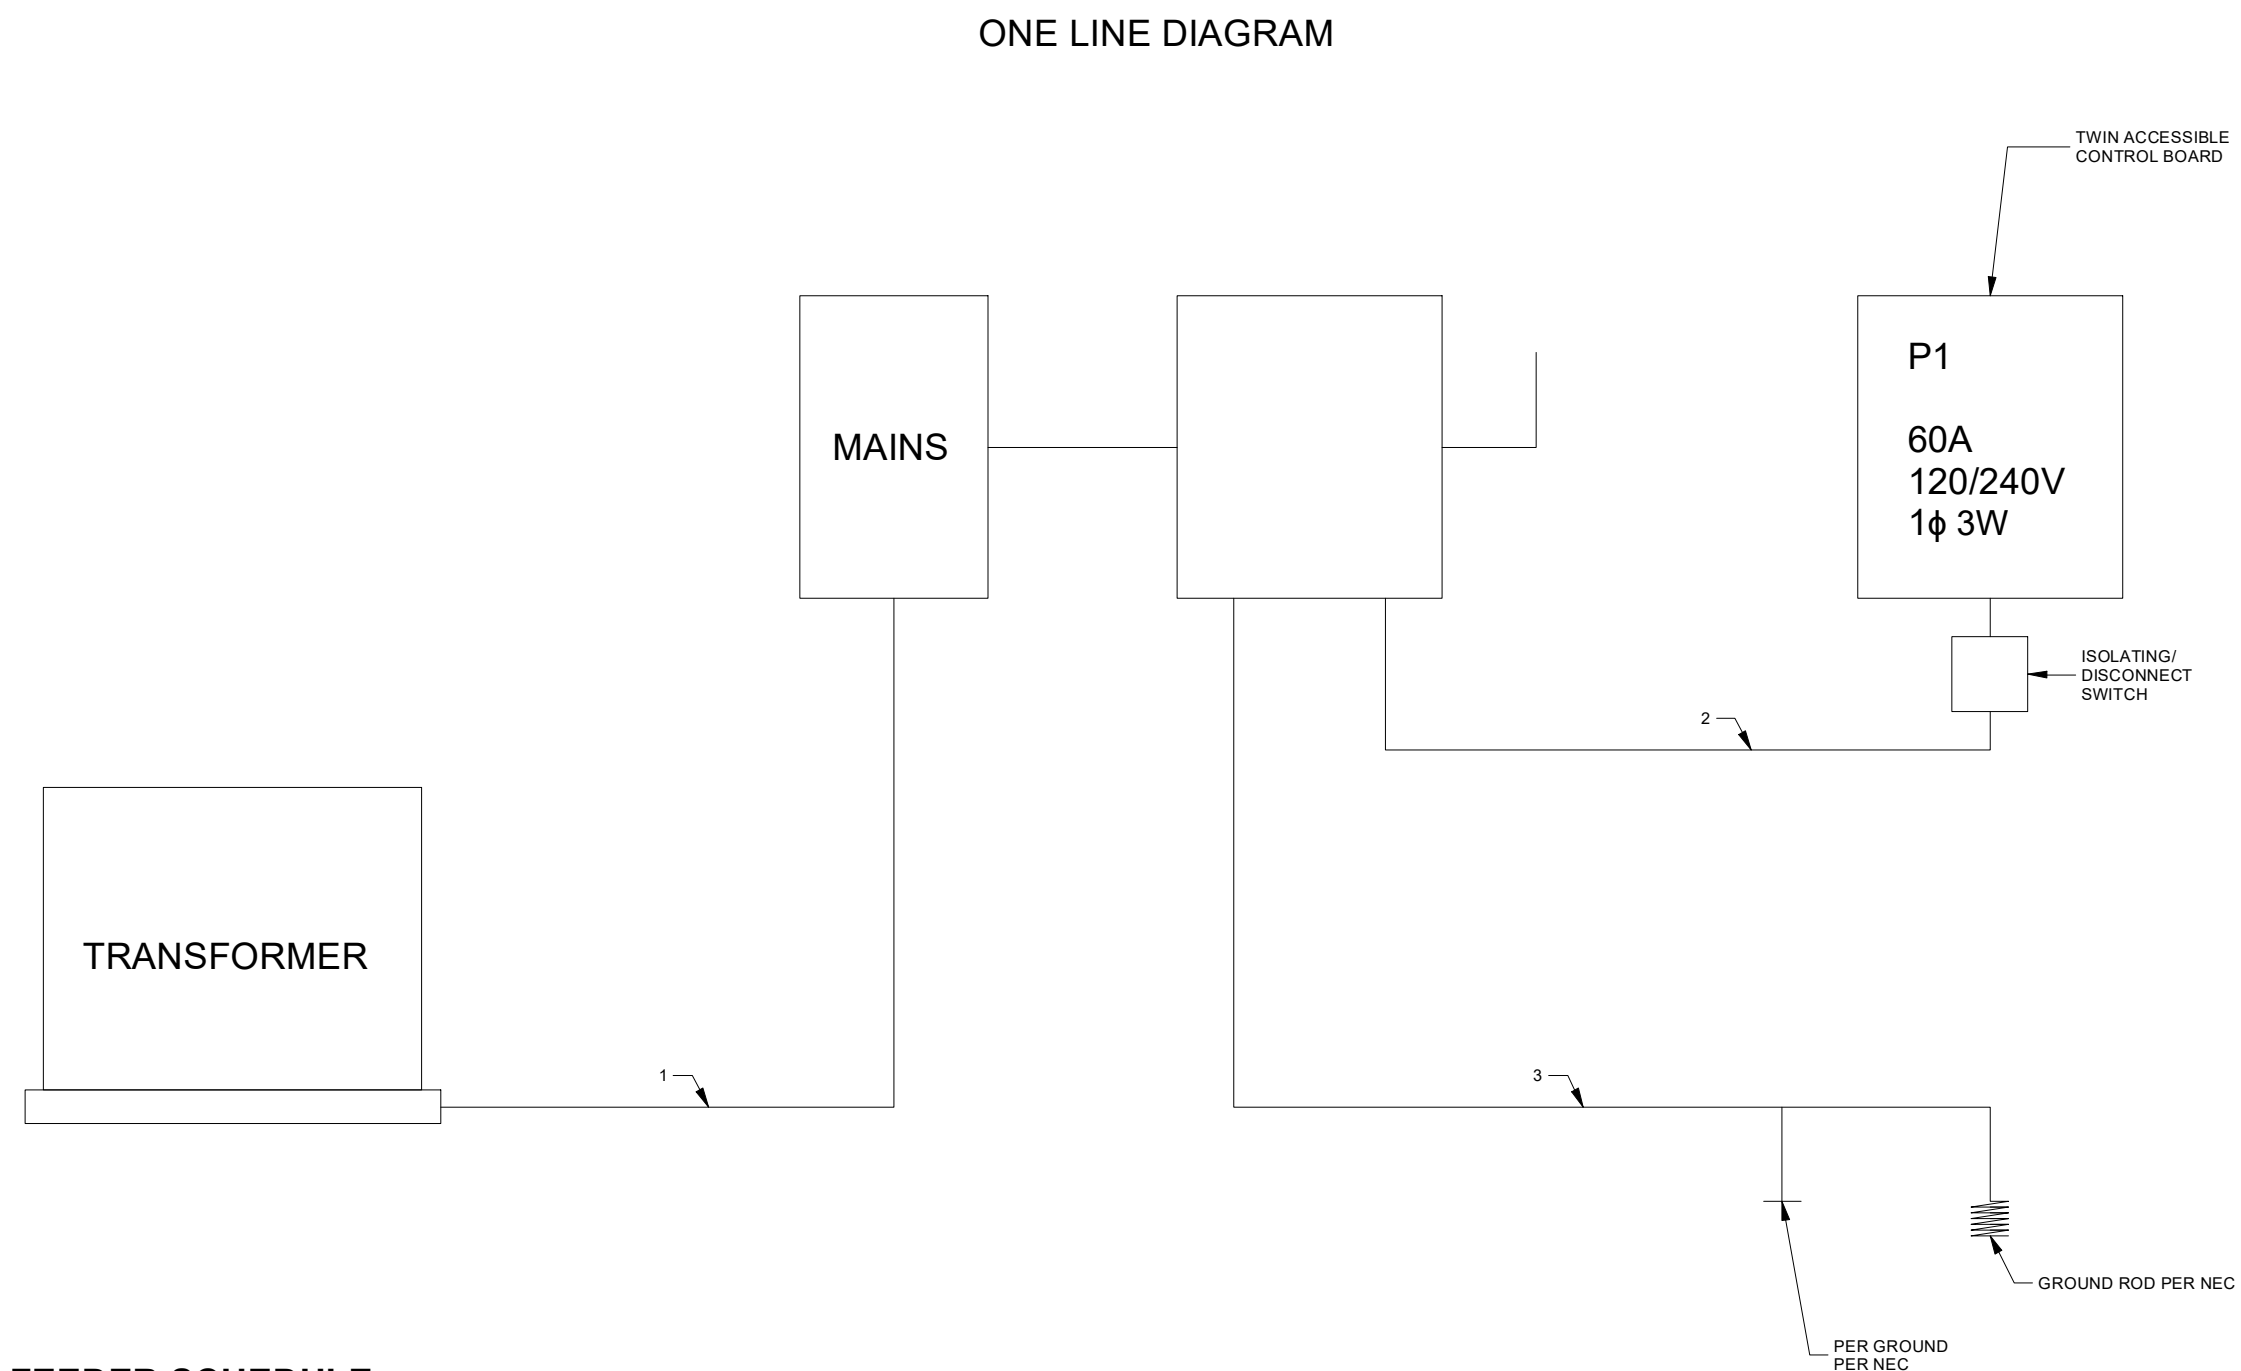

FEEDER SCHEDULE:

SIZE REQUIREMENTS TO MEET P1 CONTROL BOARD SPECIFICATIONS


exeLOO®		New Zealand 26 Paramount Dve Henderson 0610 PO Box 33-256 Takapuna, Auckland T: +64-9-838-8912 F: +64-9-838-8913	Australia Unit 18, 62-66 Newton Rd Wetherill Park PO Box 12 Liverpool NSW 1871 T: +61-2-975-3444 F: +61-2-1-800-105-504	USA 954 Toro St San Luis Obispo CA 93401 PO Box 13310 San Luis Obispo CA 93406 T: (800) 676-5290 or 1-800-303-3506	
Description: JUPITER TWIN ACCESSIBLE USA		Proj: 	Units: in	Rev. 1-H	Rev Date. 24/08/2022
Tolerance: +/-0.5		Scale: N.T.S.	Checked by: Approved by:		
Material:	Finish: REF	Drawn by: JJG	Creation Date: 16/04/2012	Sheet No. B 12	Drawing No: ASJUP22DD-US1BON

DO NOT SCALE - IF IN DOUBT ASK

SPECIFICATION SUBJECT TO CHANGE WITHOUT NOTICE

ISOMETRIC - WASTEWATER JUPITER DD US
SINGLE UNDERSLAB FLOOR VENT

CPC §905.2.
WHERE VENTS CONNECT TO A HORIZONTAL
DRAINAGE PIPE, EACH VENT PIPE SHALL
HAVE ITS INVERT TAKEN OFF ABOVE THE
DRAINAGE CENTERLINE OF SUCH PIPE
DOWNSTREAM OF THE TRAP BEING SERVED.

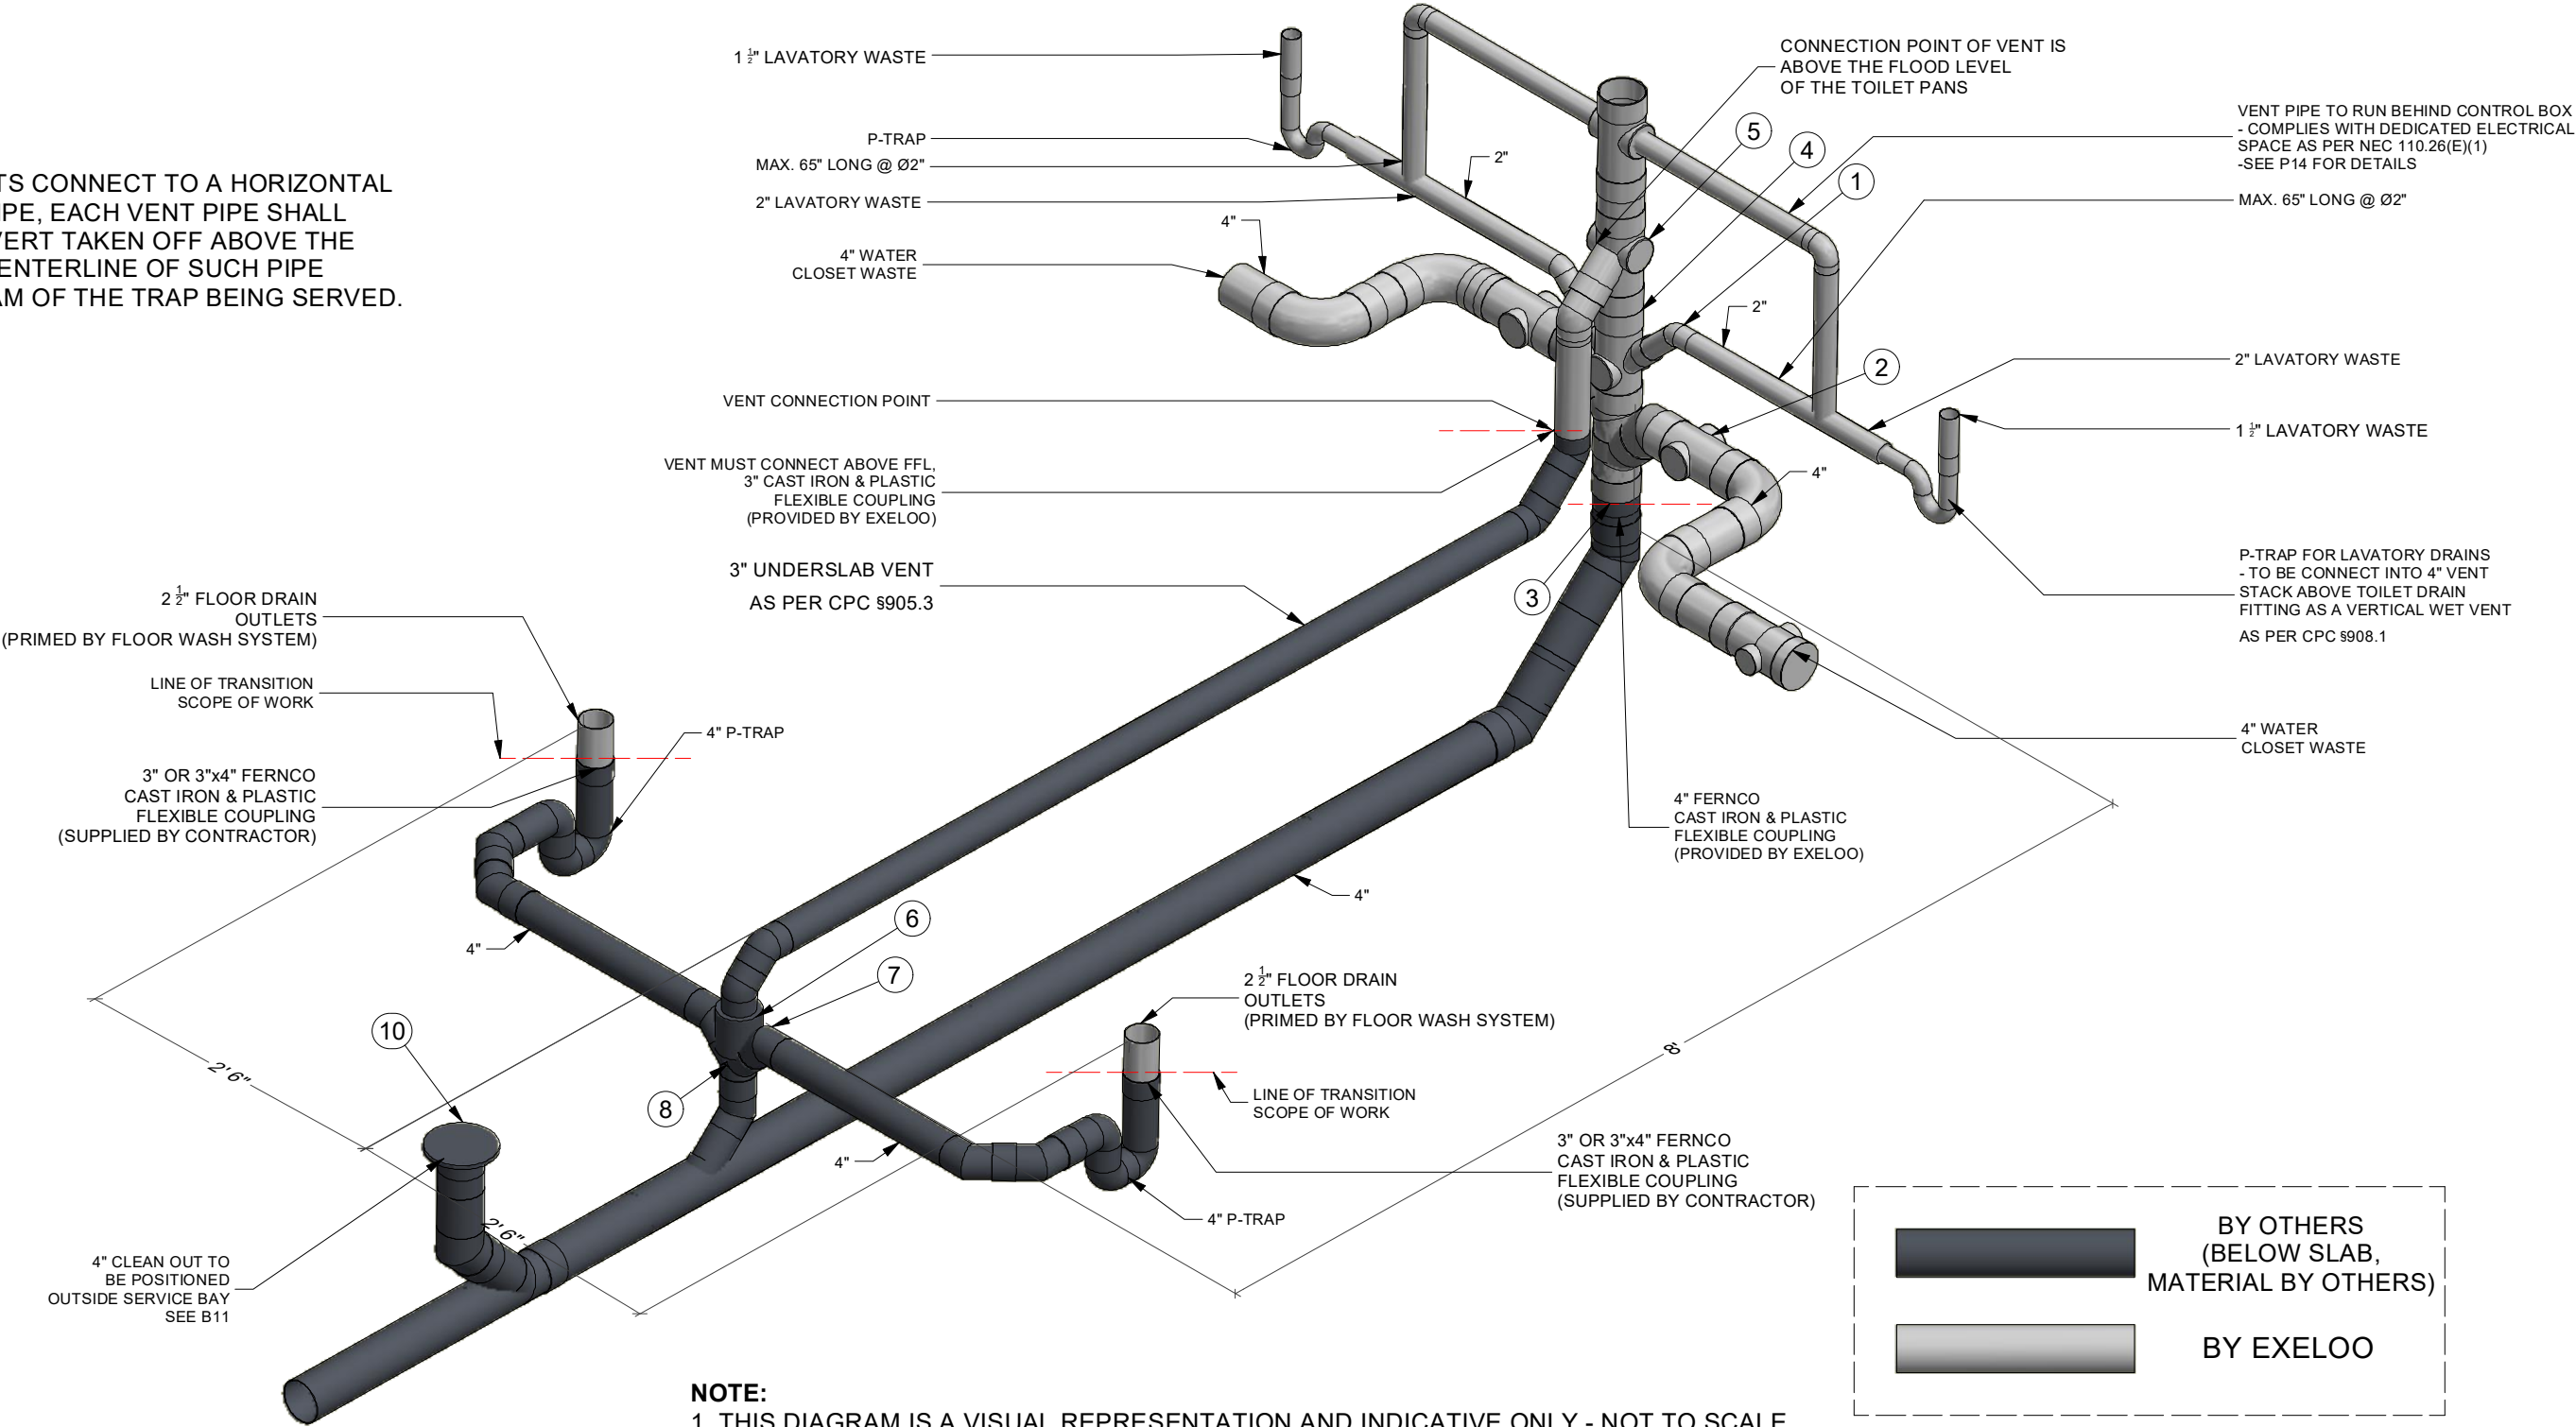

NOTE:
1. THIS DIAGRAM IS A VISUAL REPRESENTATION AND INDICATIVE ONLY - NOT TO SCALE

Parts List		
ITEM	EXELOO DESCRIPTION	MATERIAL
1	2" STREET 45	SCHEDULE 40 DWV
2	4" STREET 45	SCHEDULE 40 DWV
3	4"x4"x4" DOUBLE Y	SCHEDULE 40 DWV
4	4"x4"x2"x2" DOUBLE Y	SCHEDULE 40 DWV
5	4"x3" SANI TEE	SCHEDULE 40 DWV
6	4"x4"x4"x4" DOUBLE SAN TEE	BY CONTRACTOR
7	4" COMBY	BY CONTRACTOR
8	4"x3"ADAPTOR COUPLING	BY CONTRACTOR
9	4" LONG SWEEP	BY CONTRACTOR
10	4" CLEANOUT SQUARE CAP	BY CONTRACTOR

FLOOR DRAINS:
2 1/2" BSP MALE & 3" NPT FEMALE
ARE BOTH SUPPLIED BY EXELOO


REV	DESCRIPTION	DATE
1-B	NOTES AS PER BUREAU VERITAS MARK UP 29/01/2020	29/01/2020
1-C	REMOVE FLOOR DRAIN VENTS, 3" FLOOR DRAINS, 2" LAVATORY WASTE PIPE @ 65" MAX LENGTH	31/01/2020

		New Zealand 26 Paramount Dve Henderson 0610 PO Box 33-256 Takapuna, Auckland T: +64-9-838-8912 F: +64-9-838-8913	Australia Unit 18, 62-66 Newton Rd Wetherill Park PO Box 12 Liverpool NSW 1871 T: +61-2-975-3444 F: +61-2-1-800-105-504	USA 954 Toro St San Luis Obispo CA 93401 PO Box 13310 San Luis Obispo CA 93406 T: (800) 676-5290 or 1-800-303-3506	
Description: JUPITER PLATINUM TWIN ACCESSIBLE US - WASTEWATER SYSTEM		Proj: 	Units: in	Rev. 1-C	Rev Date. 31/01/2020
		Tolerance: +/-0.5	Scale: N.T.S.	Checked by:	Approved by:
Material:	Finish: REF	Drawn by: JJG	Creation Date: 12/12/2019	Sheet No. P 13	JUP22DD-US-WASTE SYSTEM

DO NOT SCALE - IF IN DOUBT ASK

SPECIFICATION SUBJECT TO CHANGE WITHOUT NOTICE

WATER SUPPLY SCHEMATIC PLAN

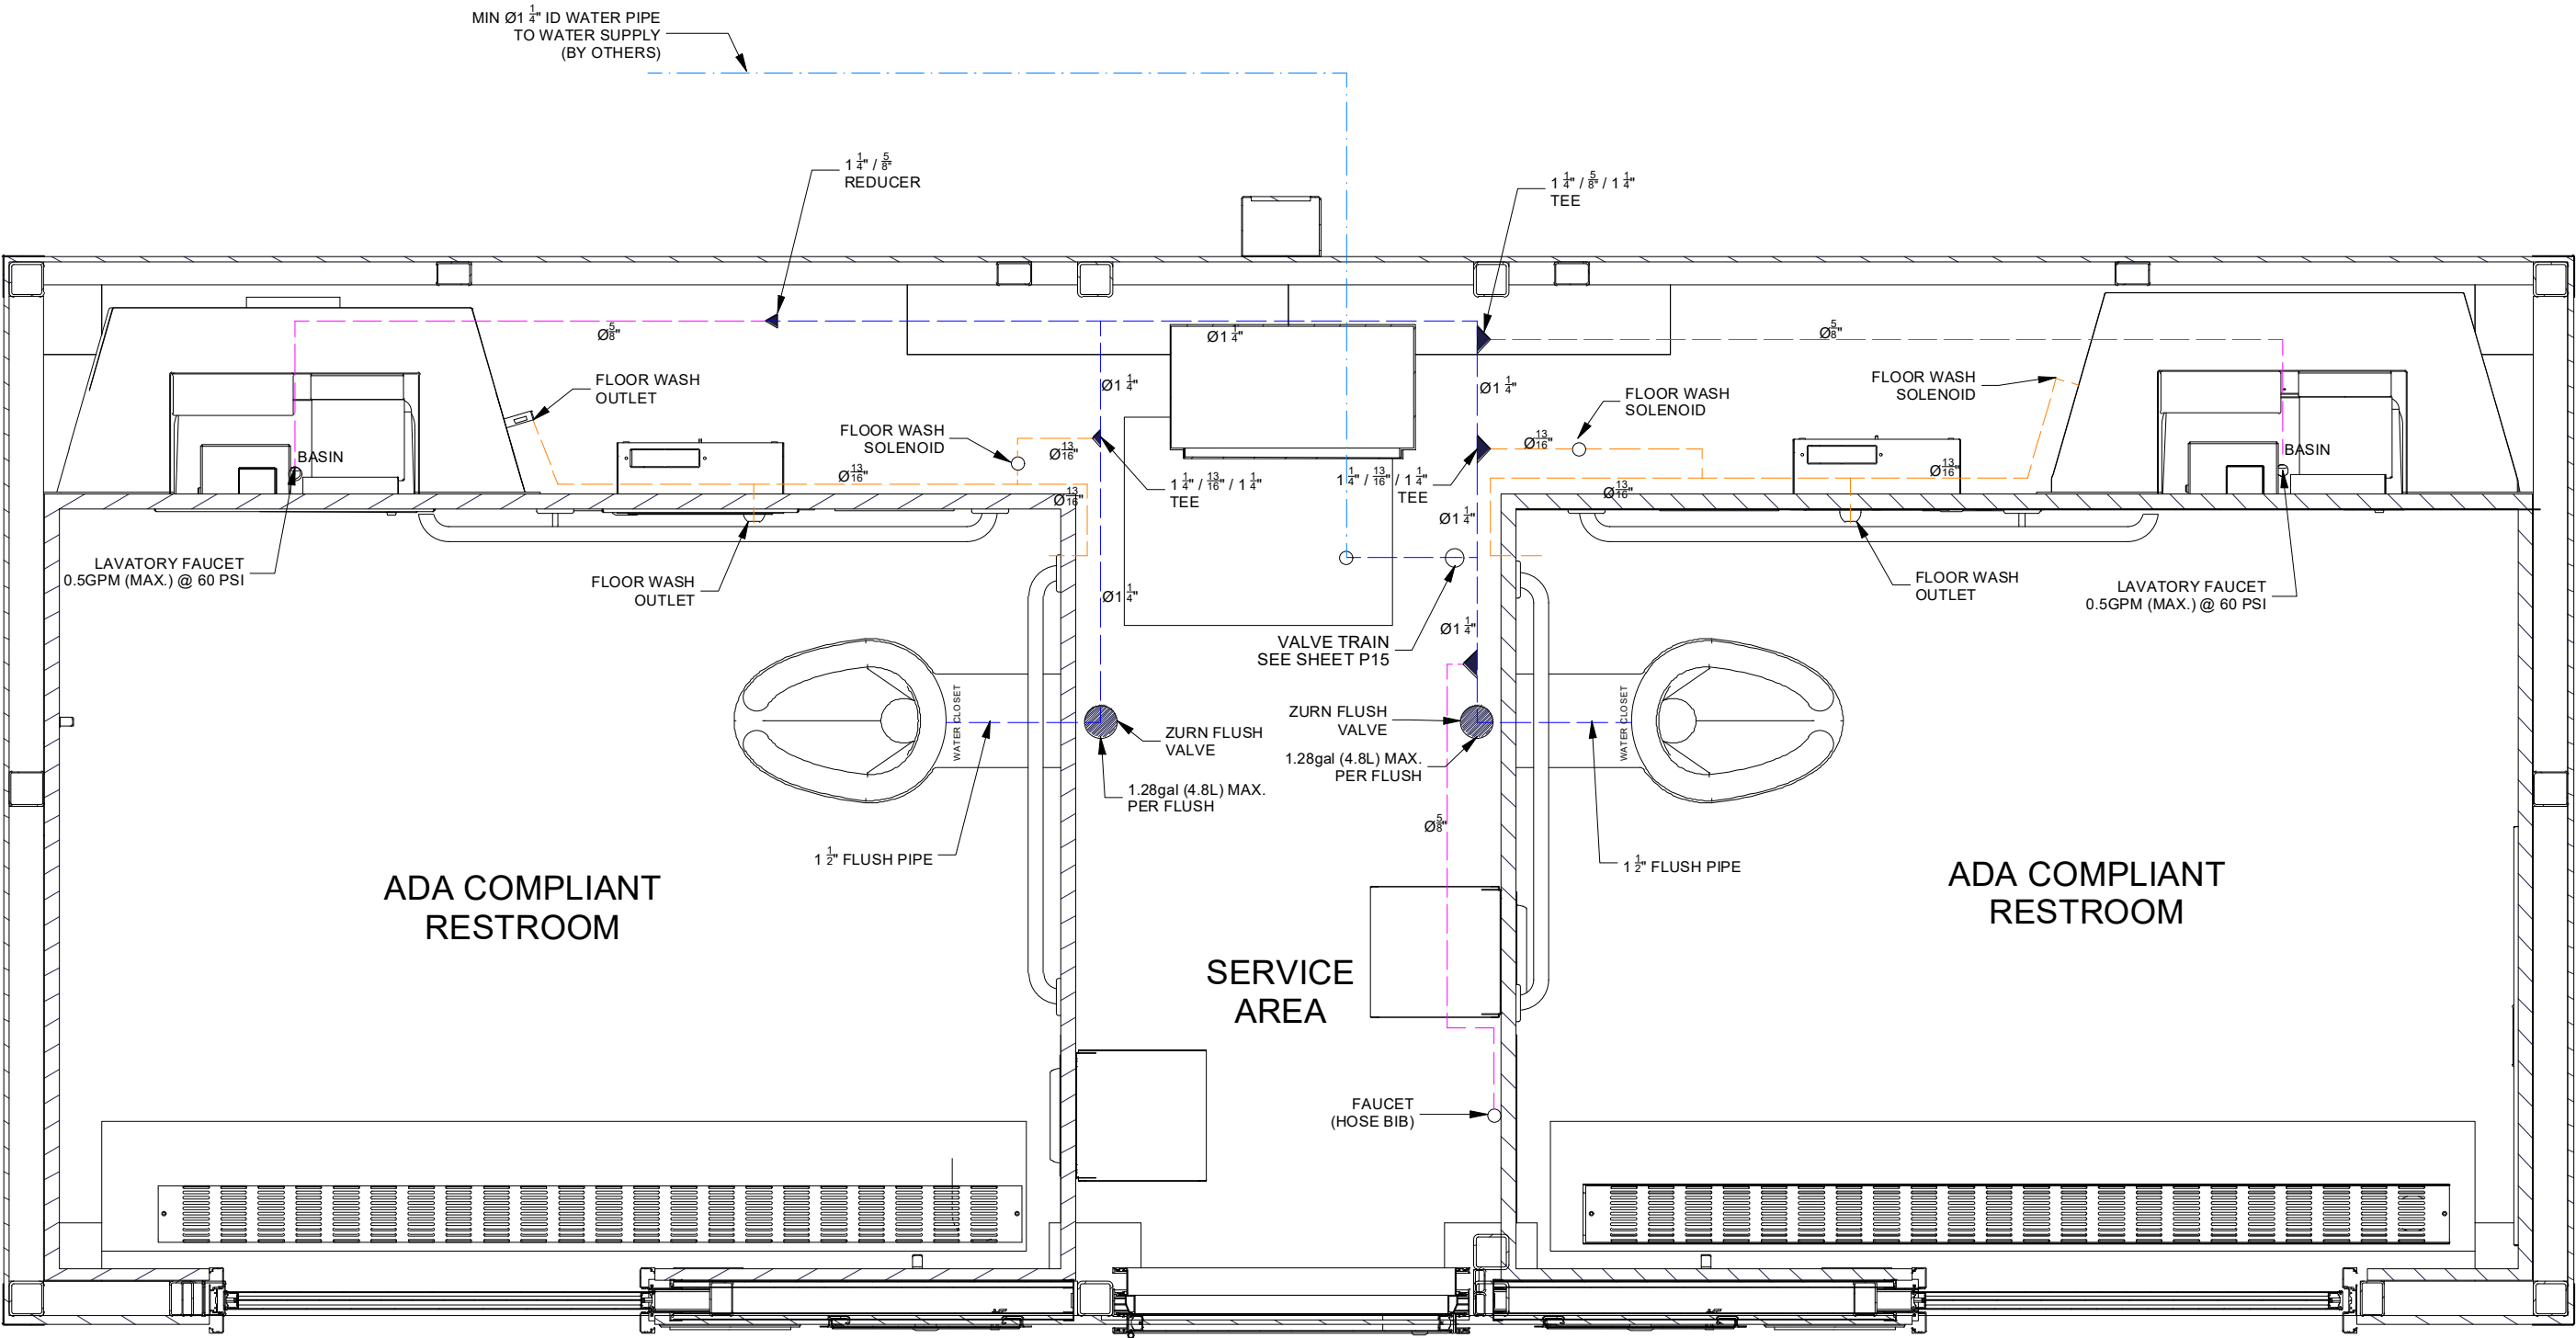

NOTE:
1. THIS DIAGRAM IS A VISUAL REPRESENTATION AND INDICATIVE ONLY - NOT TO SCALE
2. ALL PIPES AND DUCTS ARE CLEAR OF THE DEDICATED ELECTRICAL SPACE AS PER NEC 110.26.(E)(1)

exelOO
Description:
JUPITER TWIN ACCESSIBLE USA

New Zealand
26 Paramount Dve Henderson 0610
PO Box 33-256 Takapuna, Auckland
T: +64-9-838-8912 F: +64-9-838-8913

Australia
Unit 18, 62-66 Newton Rd Wetherill Park
PO Box 12 Liverpool NSW 1871
T: +61-2-975-3444 F: +61-2-1-800-105-504


USA
954 Toro St San Luis Obispo CA 93401
PO Box 13310 San Luis Obispo CA 93406
T: (800) 676-5290 or 1-800-303-3506

Proj:		Units:	in	Rev:	1-H	Rev Date:	24/08/2022
Tolerance:	+/-0.5	Scale:	N.T.S.	Checked by:			
Material:	Finish: REF	Drawn by:	JJG	Creation Date:	16/04/2012	Sheet No:	P 14
				Approved by:			
				Drawing No:	ASJUP22DD-US1BON		


DO NOT SCALE - IF IN DOUBT ASK

SPECIFICATION SUBJECT TO CHANGE WITHOUT NOTICE

ISOMETRIC VIEW

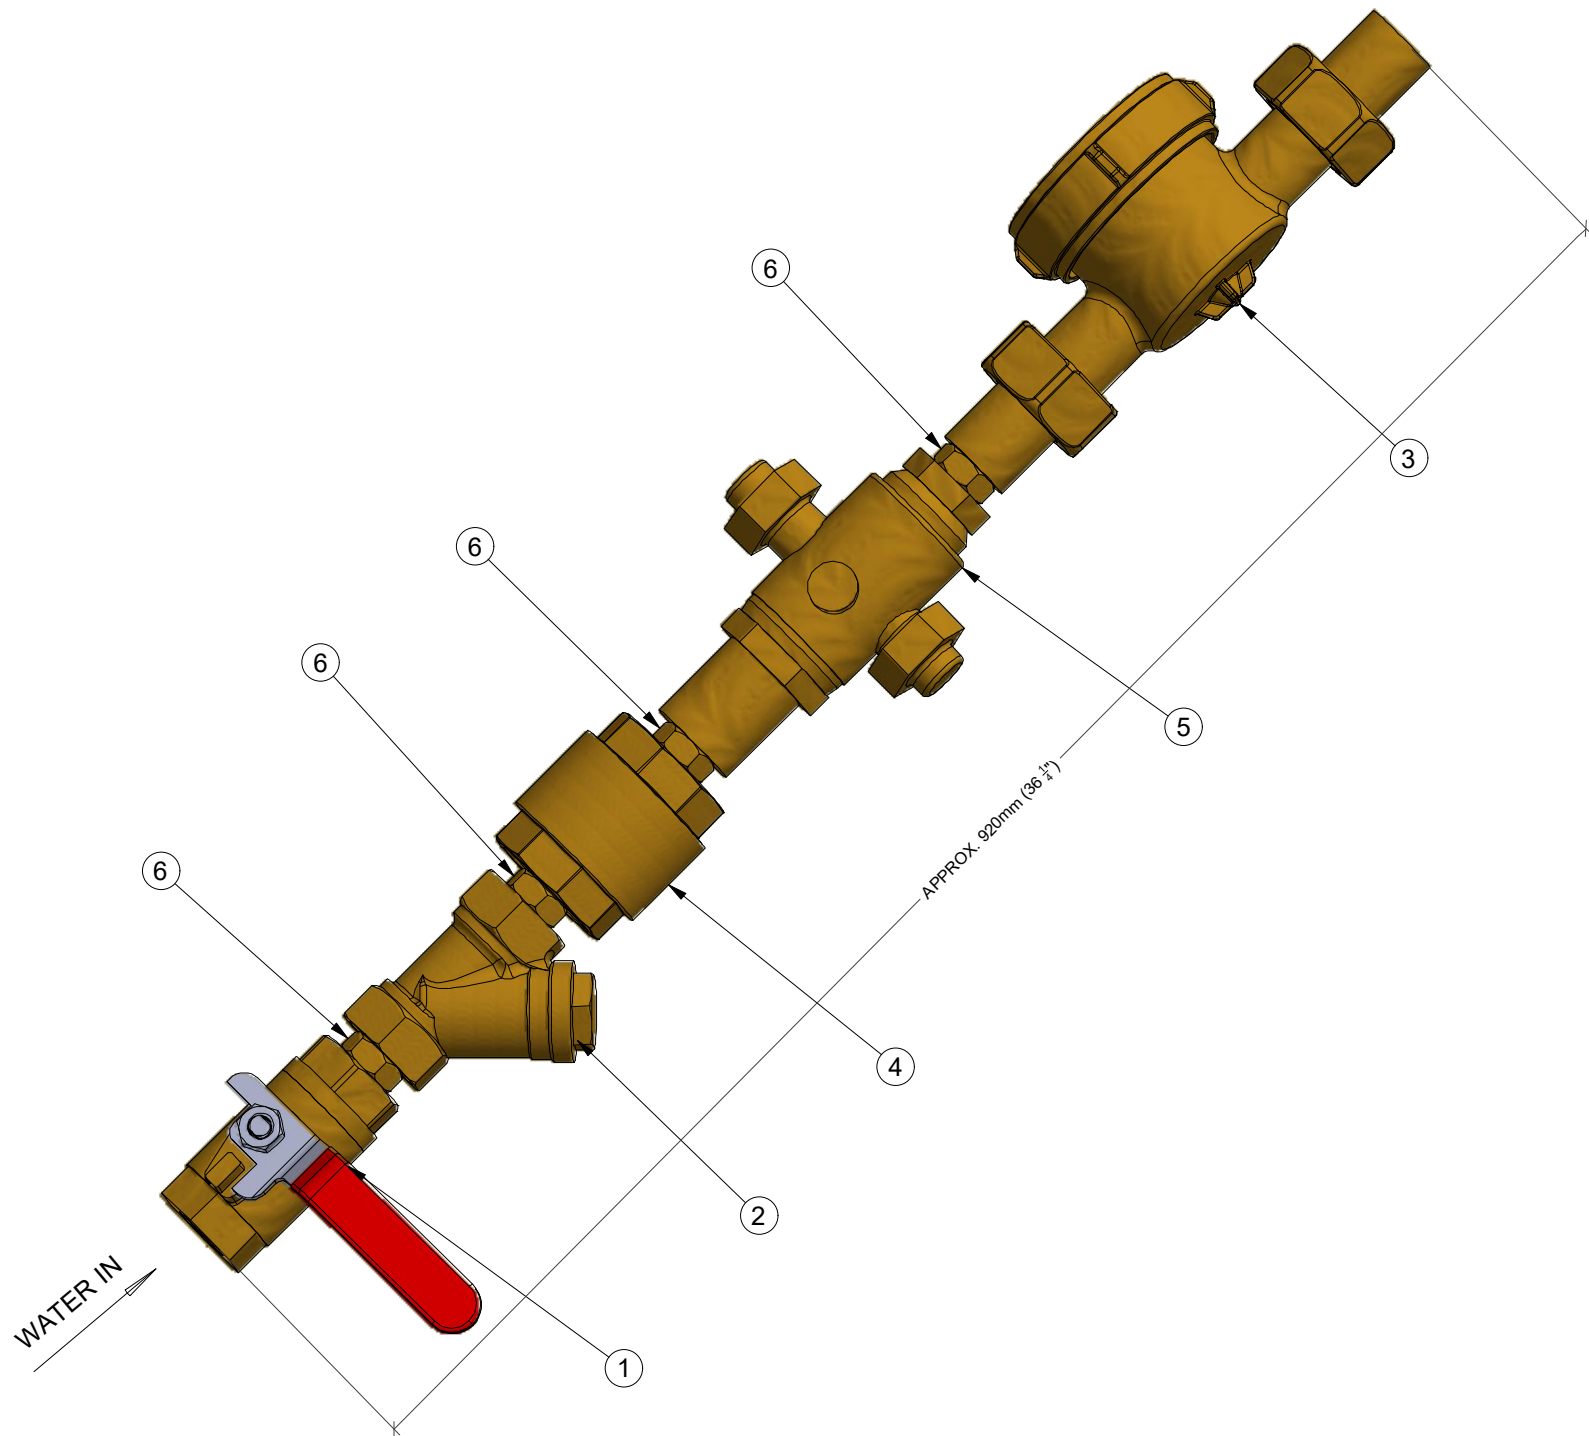

EXPLODED VIEW

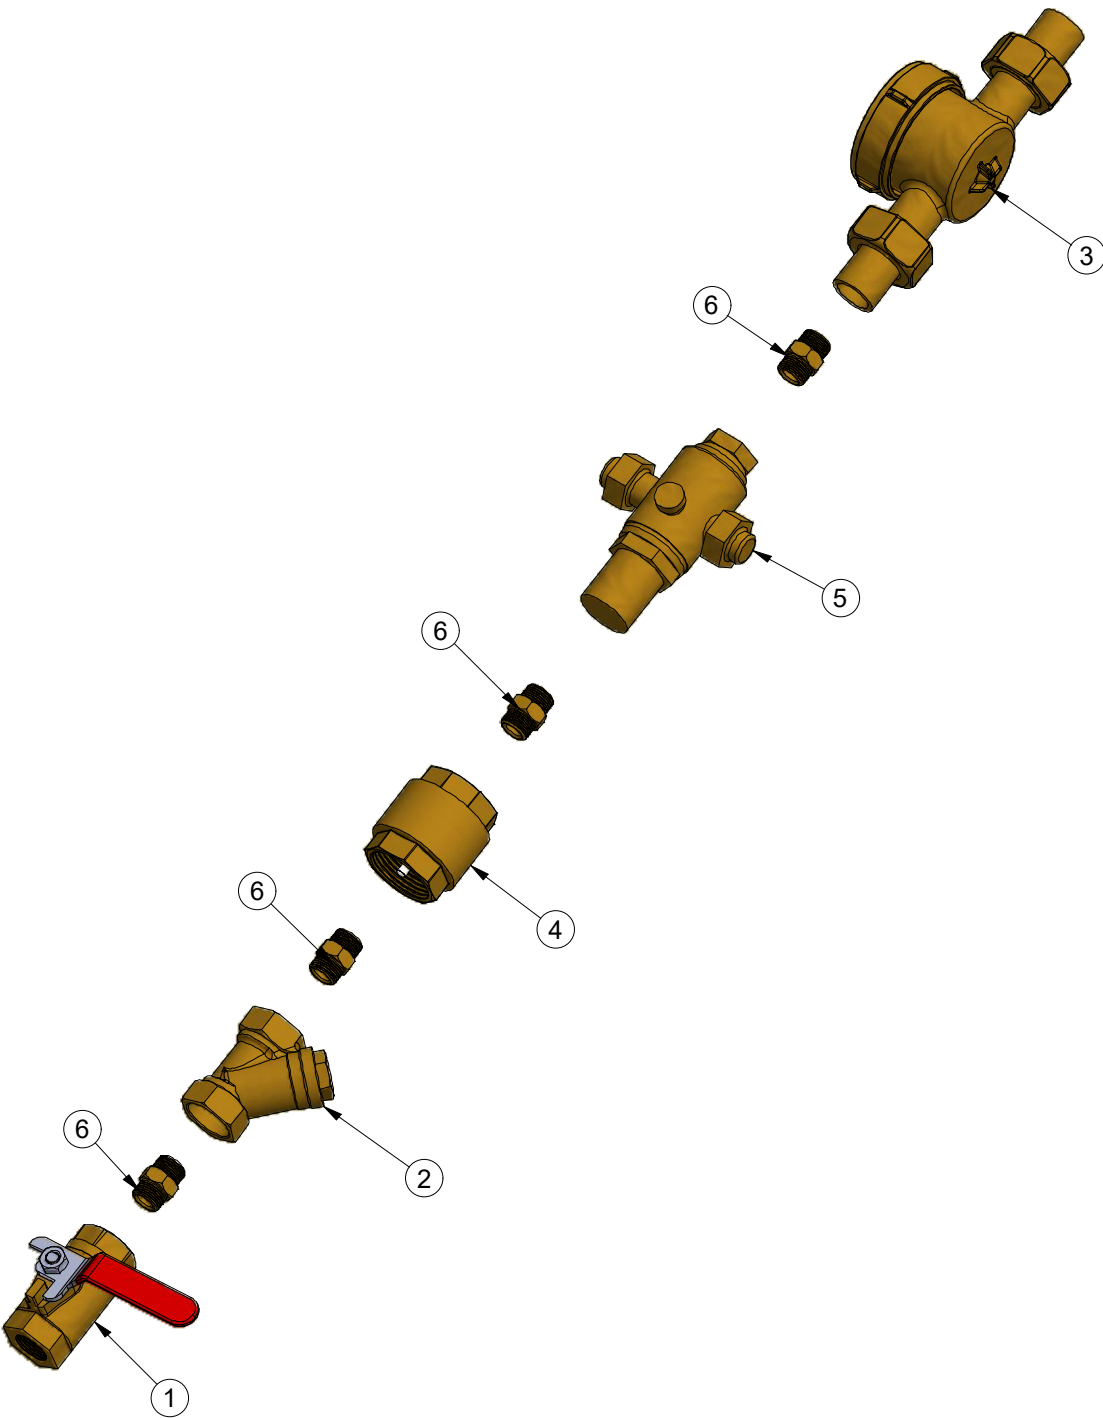

APPROXIMATE LENGTH OF TRAIN = 920mm (36 1/4")

Parts List			
ITEM	PART NUMBER	DESCRIPTION	QTY
1	5505008	VALVE TRAIN USA 1-1/4 VALVE BALL FEM/FEM LONG HANDLE WATER	1
2	5505015	VALVE TRAIN USA 1-1/4 BRONZE 150 SWP THREADED Y STRAINER	1
3	55160056	WATER METER - FOR REMOTE MONITORING (AS REQUIRED)	1
4	5505016	VALVE TRAIN USA 1-1/4 BRASS THREADED SPRING CHECK VALVE	1
5	5505013	VALVE TRAIN USA 1-1/4 BRONZE PRESSURE REDUCING VALVE FNPT X FNPT	1
6	5505017	VALVE TRAIN USA 1-1/4 X 2 BRASS NIPPLE GLOBAL	4



New Zealand
26 Paramount Dve Henderson 0610
PO Box 33-256 Takapuna, Auckland
T: +64-9-838-8912 F: +64-9-838-8913

Australia
Unit 18, 62-66 Newton Rd Wetherill Park
PO Box 12 Liverpool NSW 1871
T: +61-2-975-3444 F: +61-2-1-800-105-504

USA
954 Toro St San Luis Obispo CA 93401
PO Box 13310 San Luis Obispo CA 93406
T: (800) 676-5290 or 1-800-303-3506

Description:
VALVE TRAIN ASSEMBLY - USA



Units:
in

Rev.
1-A

Rev Date:
15/09/2021

Tolerance:
+/-0.5

Scale:
N.T.S.

Checked by:

Approved by:

Material:

Finish:
REF

Drawn by:

Creation Date:
15/09/2021

Sheet No.

Drawing No:

VALVE TRAIN - USA

DO NOT SCALE - IF IN DOUBT ASK

SPECIFICATION SUBJECT TO CHANGE WITHOUT NOTICE

BUTTON, LIGHT AND BRAILLE POSITIONS

ACCESSIBLE RESTROOM
 BRAILLE WITH TACTILE
 CHARACTERS WALL
 SIGNS AS PER
 2019 CBC, 11B-703.4.

INDICATOR LIGHTS - NO BRAILLE
 BETWEEN FFL & 48" ABOVE FFL


BUTTON HEIGHT AS PER
 11B-308.2.1 UNOBSTRUCTED
 2019 CALIFORNIA
 BUILDING CODE,
 MIN 15in/MAX 48in ABOVE FFL

EXAMPLE SIGNS ONLY

NOTE:
 NO BRAILLE ON SIGNS OR BUTTONS
 BETWEEN FFL & 48" ABOVE FFL

FFL

BUTTON, LIGHT AND BRAILLE POSITIONS

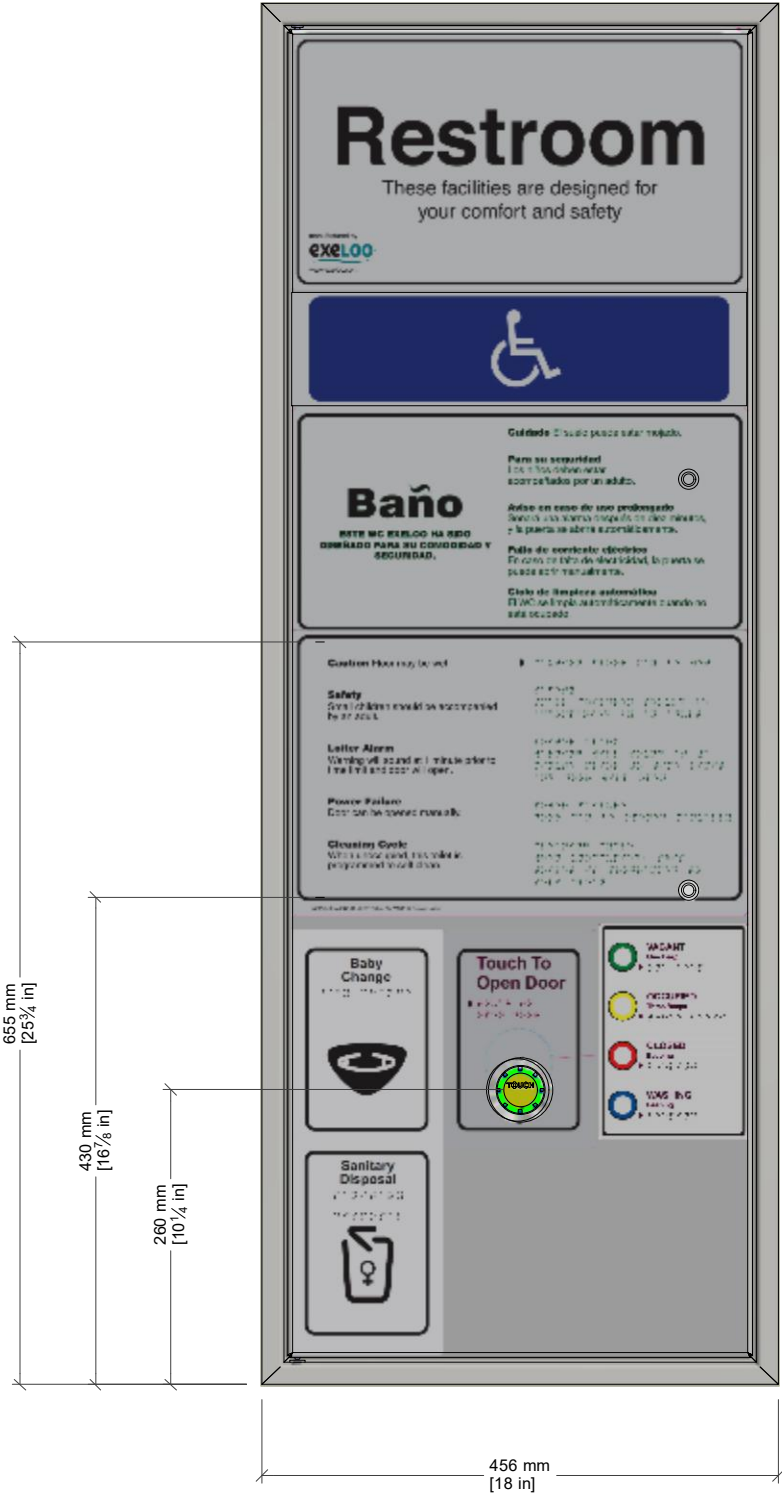

New Zealand
 26 Paramount Dve Henderson 0610
 PO Box 33-256 Takapuna, Auckland
 T: +64-9-838-8912 F: +64-9-838-8913

Australia
 Unit 18, 62-66 Newton Rd Wetherill Park
 PO Box 12 Liverpool NSW 1871
 T: +61-2-975-3444 F: +61-2-1-800-105-504

USA
 954 Toro St San Luis Obispo CA 93401
 PO Box 13310 San Luis Obispo CA 93406
 T: (800) 676-5290 or 1-800-303-3506

Description:
 SIGN DOOR ASSEMBLY USA - ADA

Proj:
 Tolerance:
 +/-0.5

Scale:
 N.T.S.

Drawn by:
 JJG

Creation Date:
 1/05/2006

Units:
 in

Rev:
 1-A

Rev Date:
 17/03/2020

Checked by:

Approved by:


Sheet No:
 G 16

SIGN FRAME MU001 -
 ADA

DO NOT SCALE - IF IN DOUBT ASK


SPECIFICATION SUBJECT TO CHANGE WITHOUT NOTICE

MAIN VIEW

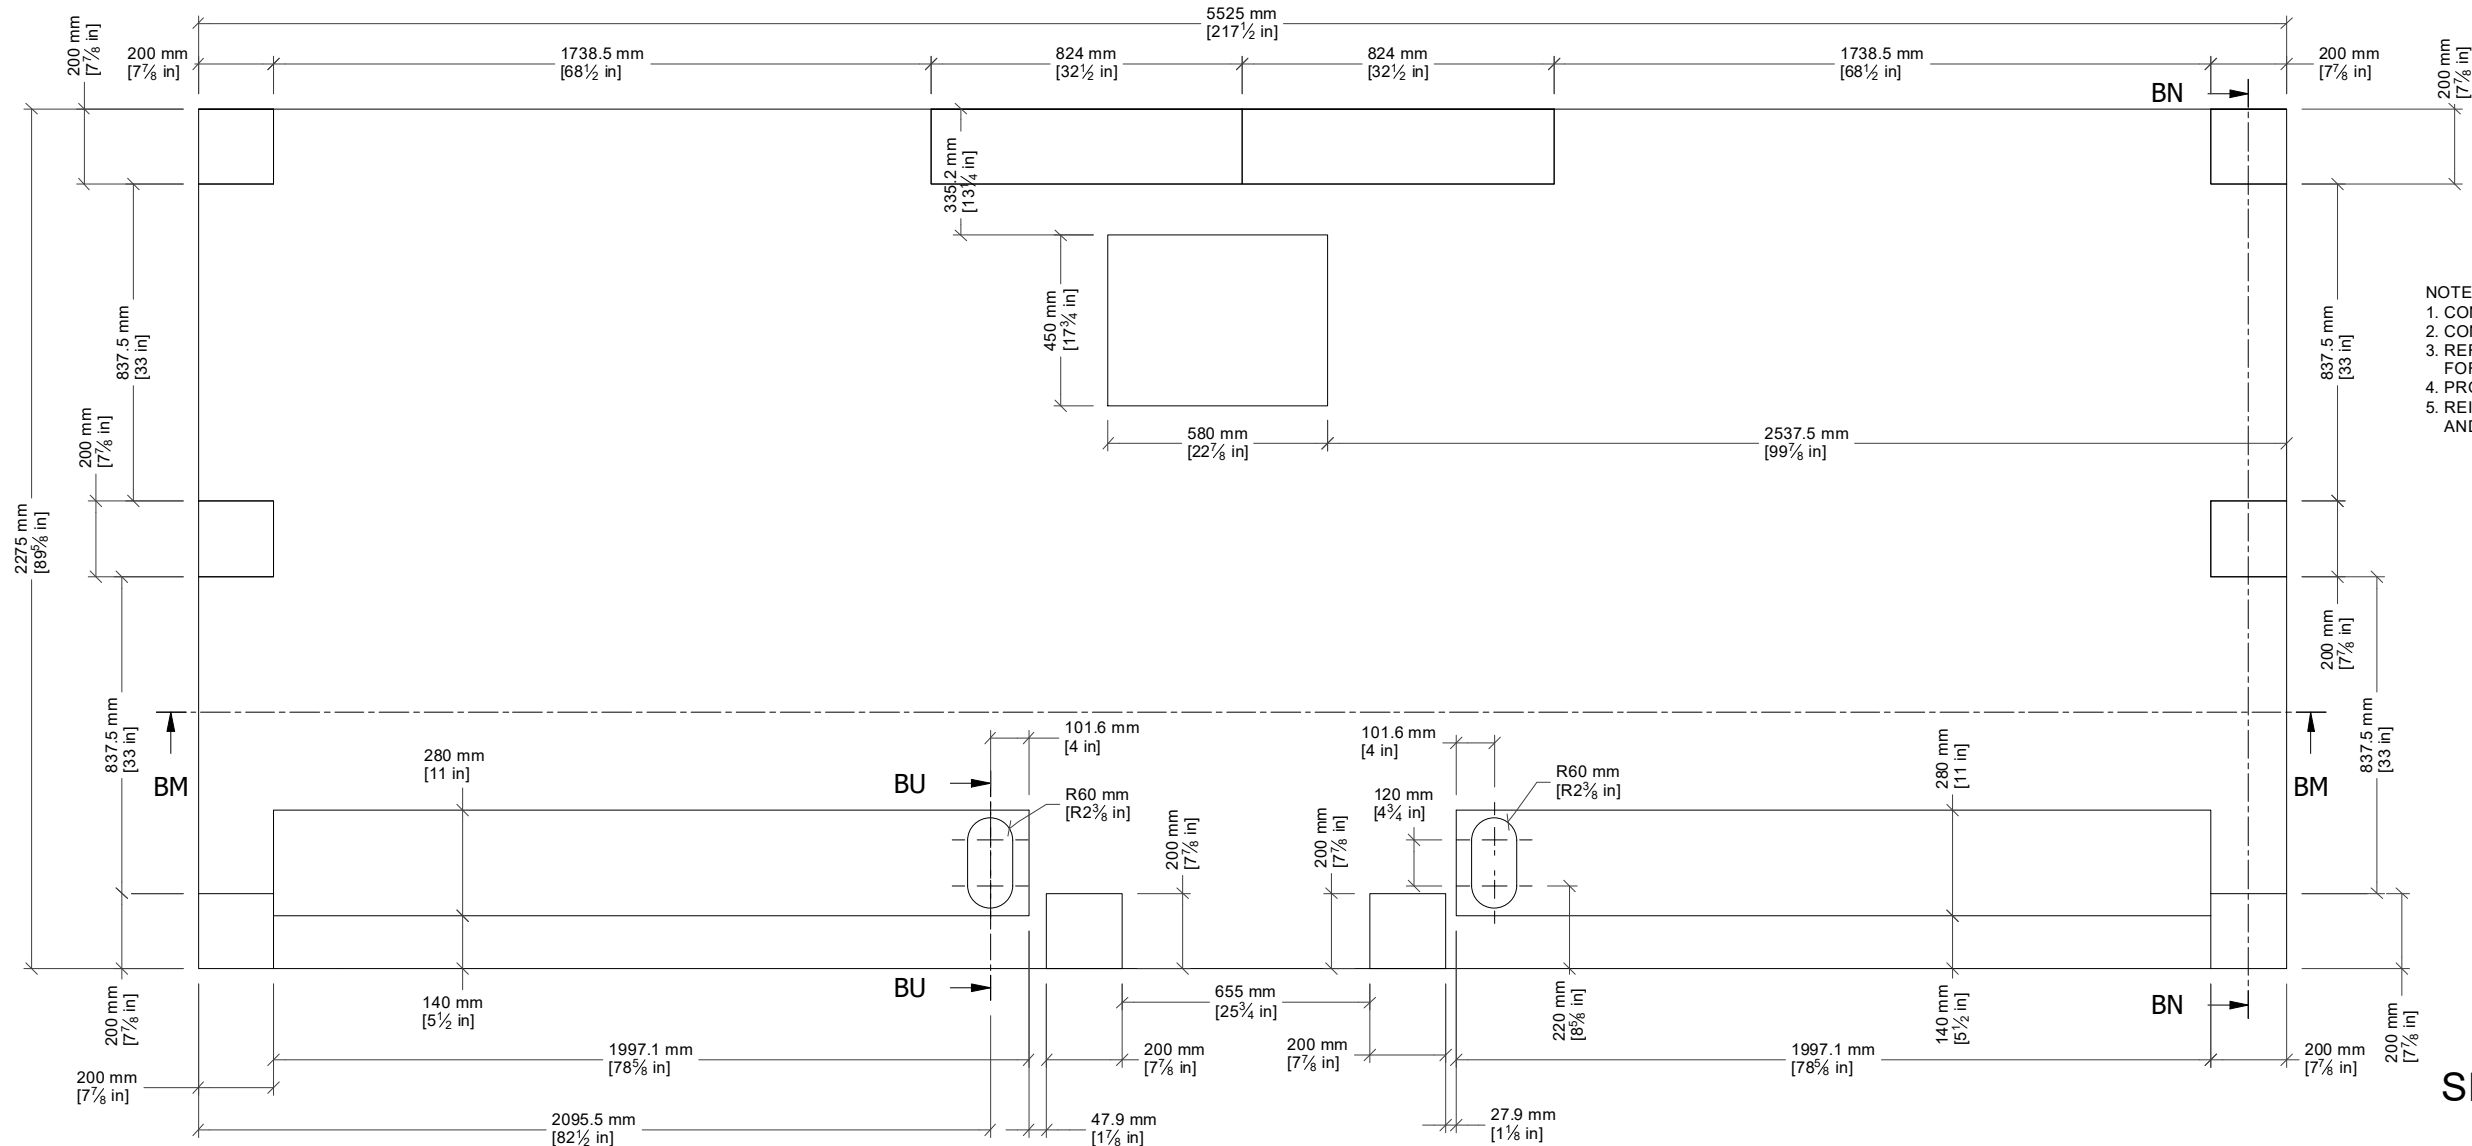


- NOTES (IMPERIAL):
1. CONCRETE STRENGTH TO BE 40 MPa
 2. CONCRETE COVER TO BE 30mm U.N.O
 3. REFER TO NZ 3109:1997 TABLE 5.1 FOR PRECAST TOLERANCES
 4. PRODUCT CODE - WX
 5. REINFORCING TO BE GRADE 430 AND HD10


SECTION VIEW BP-BP (1 : 20)

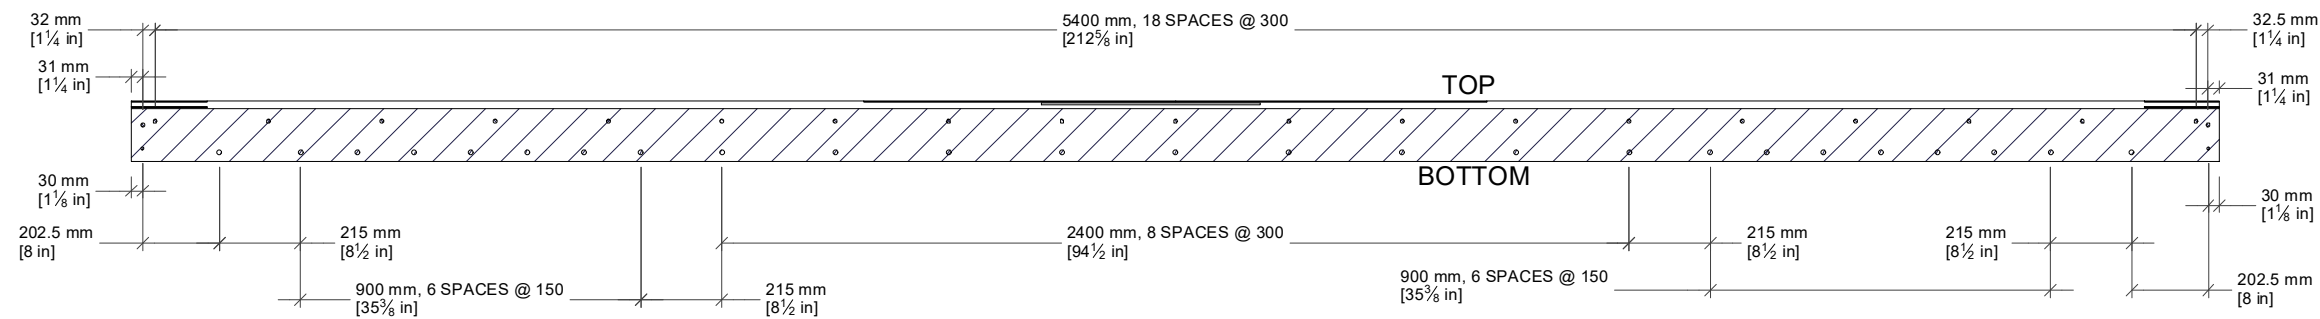

SECTION VIEW BR-BR (1 : 20)

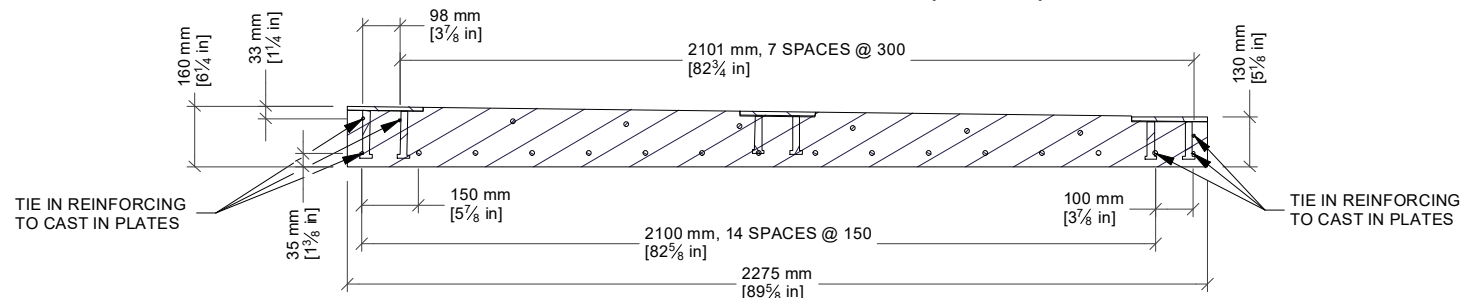

SECTION VIEW BT-BT (1 : 20)

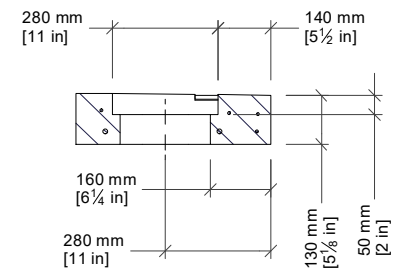

exelOO

New Zealand
26 Paramount Dve Henderson 0610
PO Box 33-256 Takapuna, Auckland
T: +64-9-838-8912 F: +64-9-838-8913

Australia
Unit 18, 62-66 Newton Rd Wetherill Park
PO Box 12 Liverpool NSW 1871
T: +61-2-975-3444 F: +61-2-1-800-105-504

USA
954 Toro St San Luis Obispo CA 93401
PO Box 13310 San Luis Obispo CA 93406
T: (800) 676-5290 or 1-800-303-3506

Description:
JUPITER SUPER TWIN BASE - USA

Proj:

Units:
in

Rev:
1-A

Rev Date:
15/07/2021

Tolerance:
+/-0.5

Scale:
N.T.S.

Checked by:

Approved by:

Material:

Finish:
REF

Drawn by:
JJG



Creation Date:
16/06/2011

Sheet No:
B 18



Drawing No:
3D-2755

DO NOT SCALE - IF IN DOUBT ASK

SPECIFICATION SUBJECT TO CHANGE WITHOUT NOTICE

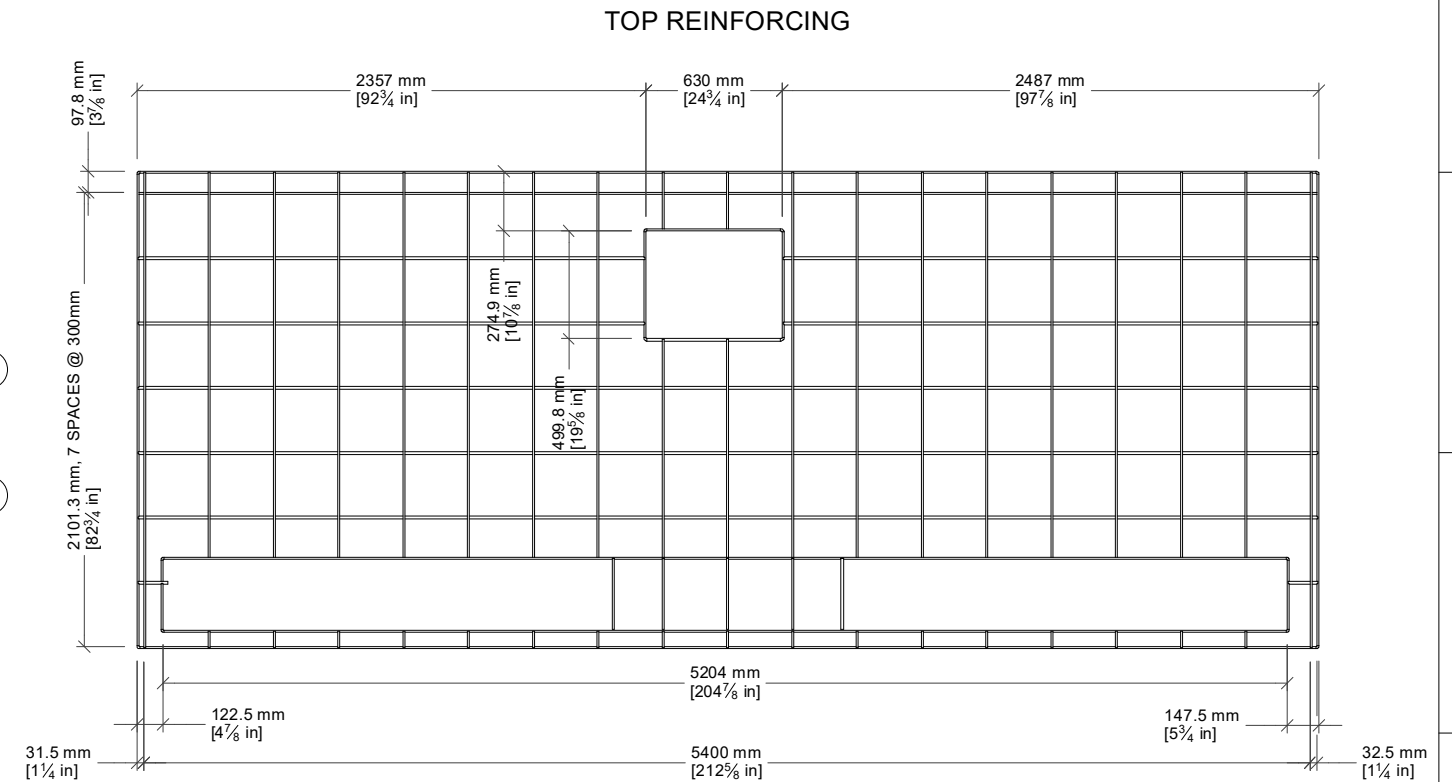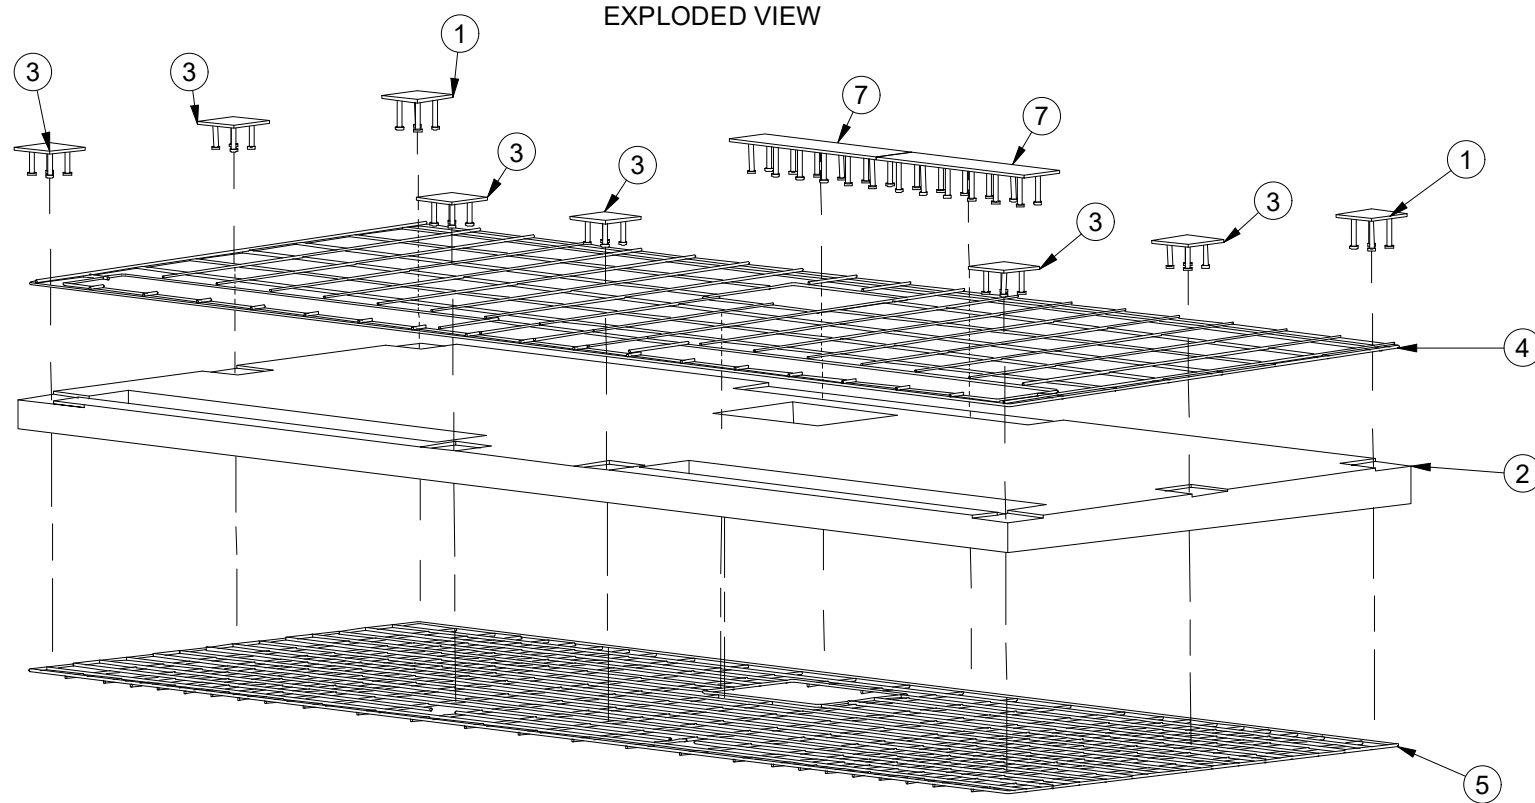

REINFORCING - HIDDEN VIEW

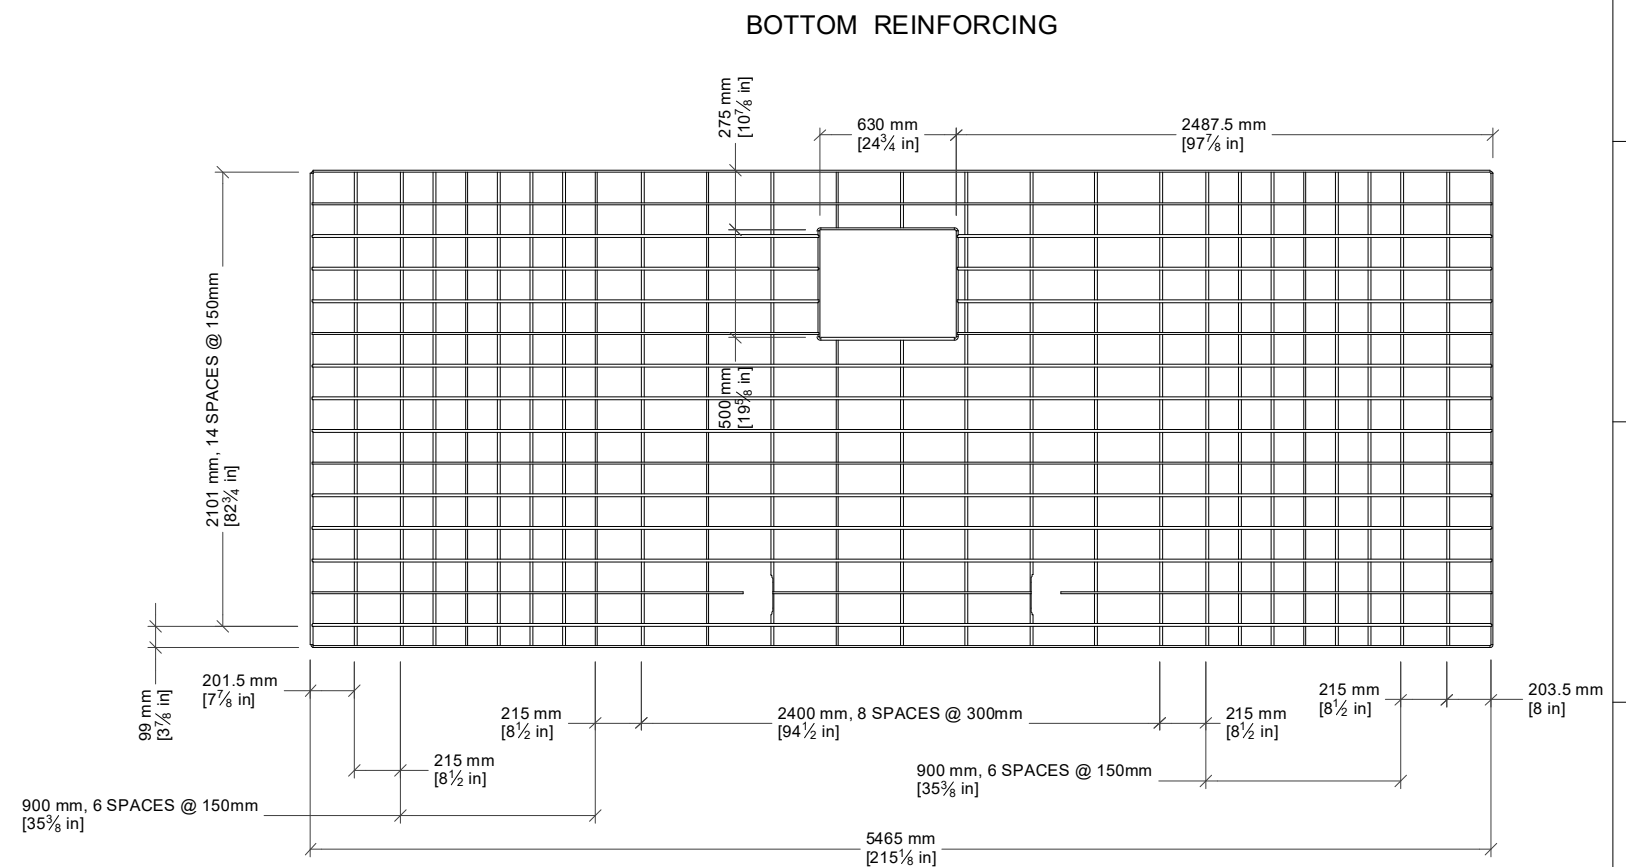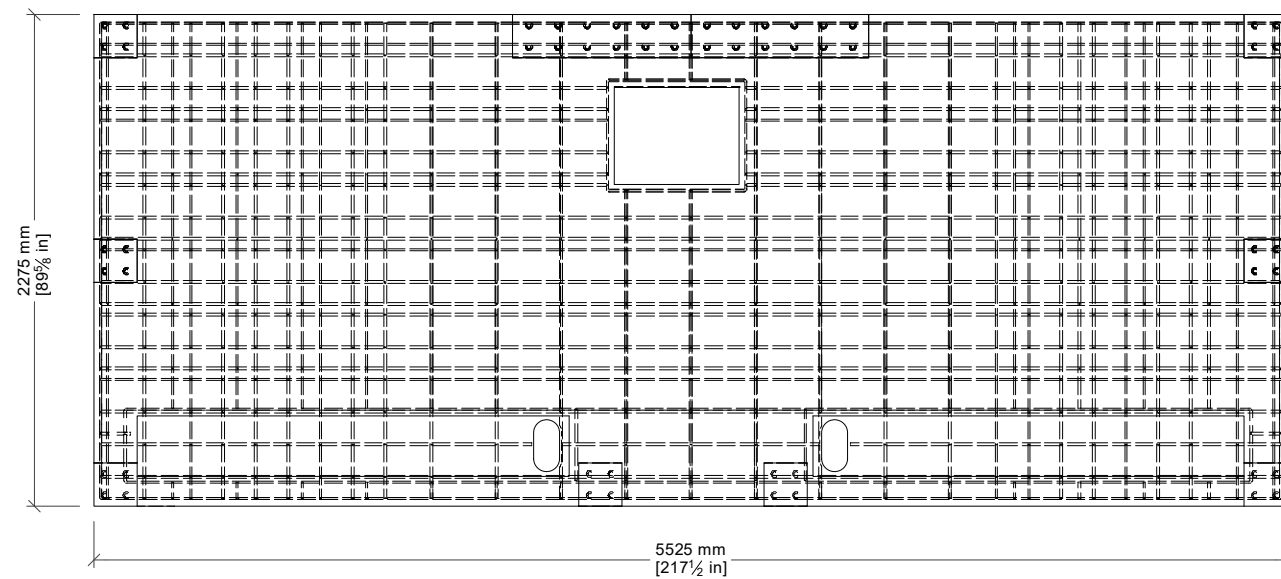

Parts List			
ITEM	PART NUMBER	DESCRIPTION	QTY
1	JUP 10025	CORNER REAR CASTING PLATE	2
2	JUP32 80002-USA	JUPITER 32 CONCRETE FLOOR SLAB	1
3	JUP 10024	CORNER FRONT CASTING PLATE	6
4	JUP32 50012-JUP22US	JUPITER 32 TOP REINFORCING	1
5	JUP32 50022-jup22us	JUPITER 32 BOTTOM REINFORCING	1
7	JUP 10023	REAR CASTING PLATE	2

exeLOO

New Zealand
26 Paramount Dve Henderson 0610
PO Box 33-256 Takapuna, Auckland
T: +64-9-838-8912 F: +64-9-838-8913

Australia
Unit 18, 62-66 Newton Rd Wetherill Park
PO Box 12 Liverpool NSW 1871
T: +61-2-975-3444 F: +61-2-1-800-105-504

USA
954 Toro St San Luis Obispo CA 93401
PO Box 13310 San Luis Obispo CA 93406
T: (800) 676-5290 or 1-800-303-3506

Description:
JUPITER SUPER TWIN BASE - USA

Proj:

Units:
in

Rev.
1-A

Rev Date:
15/07/2021

Tolerance:
+/-0.5

Scale:
N.T.S.

Checked by:

Approved by:

Material:

Finish:
REF

Drawn by:
JJG

Creation Date:
16/06/2011

Sheet No.
B 19



Drawing No:
3D-2755

DO NOT SCALE - IF IN DOUBT ASK

SPECIFICATION SUBJECT TO CHANGE WITHOUT NOTICE

10 9 8 7 6 5 4 3 2 1

NOTE:
SLAB SLOPES FROM 5-1/8" (5-5/8" INC TILES) AT FRONT
TO 6-1/4" (6-3/4" INC TILES) AT REAR.
FOOTING IS NOT PART OF THE BASE
- CONTRACTOR TO SUPPLY.

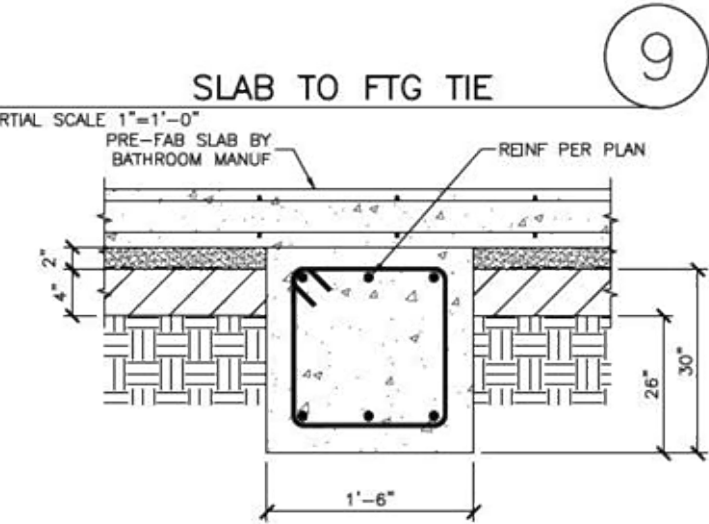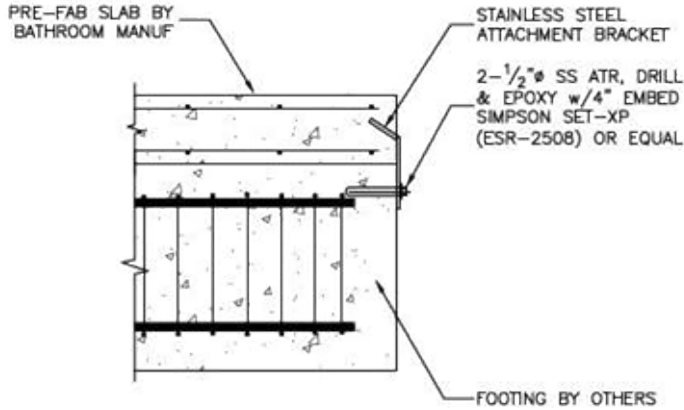


NOTE:
1. THE SUBGRADE (BELOW THE AGGREGATE BASE) SHOULD BE SCARIFIED TO A MINIMUM DEPTH OF 12 INCHES, MOISTURE CONDITIONED TO AT LEAST 3 PERCENT ABOVE OPTIMUM MOISTURE CONTENT, AND RE-COMPACTED TO AT LEAST 90 PERCENT RELATIVE COMPACTION PER ASTM D-1557.
2. THE BOTTOM OF THE FOOTING EXCAVATION SHOULD BE COMPACTED WITH A JUMPING JACK COMPACTOR WITH AT LEAST 4 PASSES.
3. THE SLAB SHOULD BE UNDERLAIN BY 2 INCHES OF MASON SAND (ASTM C-144) COMPACTED WITH A VIBRATORY PLATE OVER A MINIMUM 4 INCHES OF CLASS 2 AGGREGATE BASE COMPACTED TO AT LEAST 95 PERCENT RELATIVE COMPACTION.

FOOTING @ SLAB

PARTIAL SCALE 1"=1'-0"

FOUNDATION PLAN

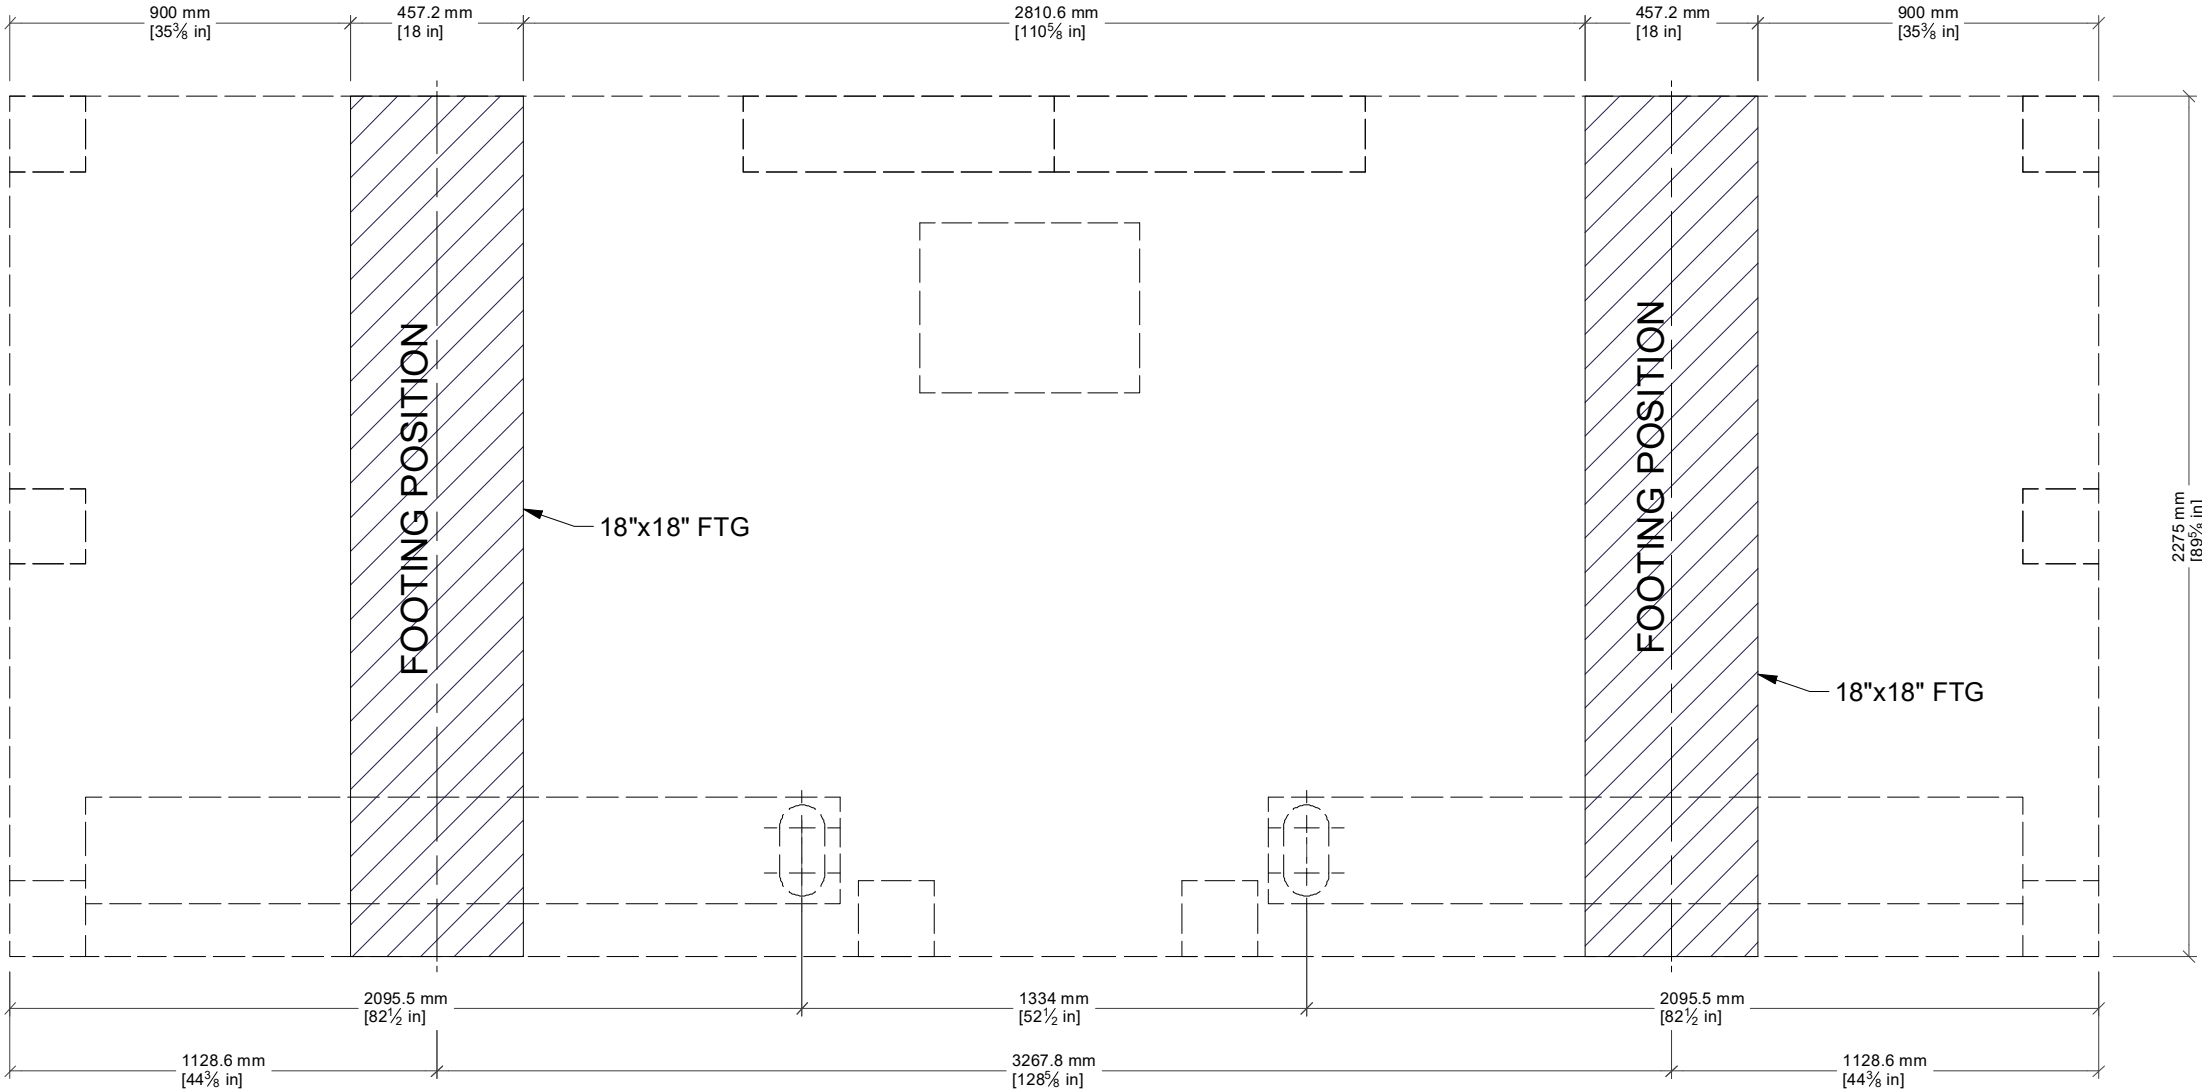

FOUNDATION

1. GROUND CONDITIONS TO BE AT LEAST CAPABLE OF AN ALLOWABLE WORKING LOAD (DEAD AND LIVE) STRENGTH OF 2,000 psf
2. GROUND BEAM TO BE FILLED WITH 3,000 psi 28 DAY STRENGTH CONCRETE FOR 7 DAYS MIN. BEFORE PLACING EXELOO UNIT INTO POSITION

exelOO

New Zealand
26 Paramount Dve Henderson 0610
PO Box 33-256 Takapuna, Auckland
T: +64-9-838-8912 F: +64-9-838-8913

Australia
Unit 18, 62-66 Newton Rd Wetherill Park
PO Box 12 Liverpool NSW 1871
T: +61-2-975-3444 F: +61-2-1-800-105-504

USA
954 Toro St San Luis Obispo CA 93401
PO Box 13310 San Luis Obispo CA 93406
T: (800) 676-5290 or 1-800-303-3506

Description:
**JUPITER SUPER TWIN/TRIPLE BASE FOR
MODELS 22,23,32,33,42,43,52,53**

Material:
REF

Proj:
+

Tolerance:
+/-0.5

Drawn by:
JJG

Scale:
N.T.S.

Creation Date:
16/06/2011

Units:
in

Checked by:

Sheet No.
B 20

Rev.
1-P

Approved by:

Drawing No.
3D-2712


Rev Date:
27/05/2022

DO NOT SCALE - IF IN DOUBT ASK

SPECIFICATION SUBJECT TO CHANGE WITHOUT NOTICE

10 9 8 7 6 5 4 3 2 1

FRONT PERSPECTIVE

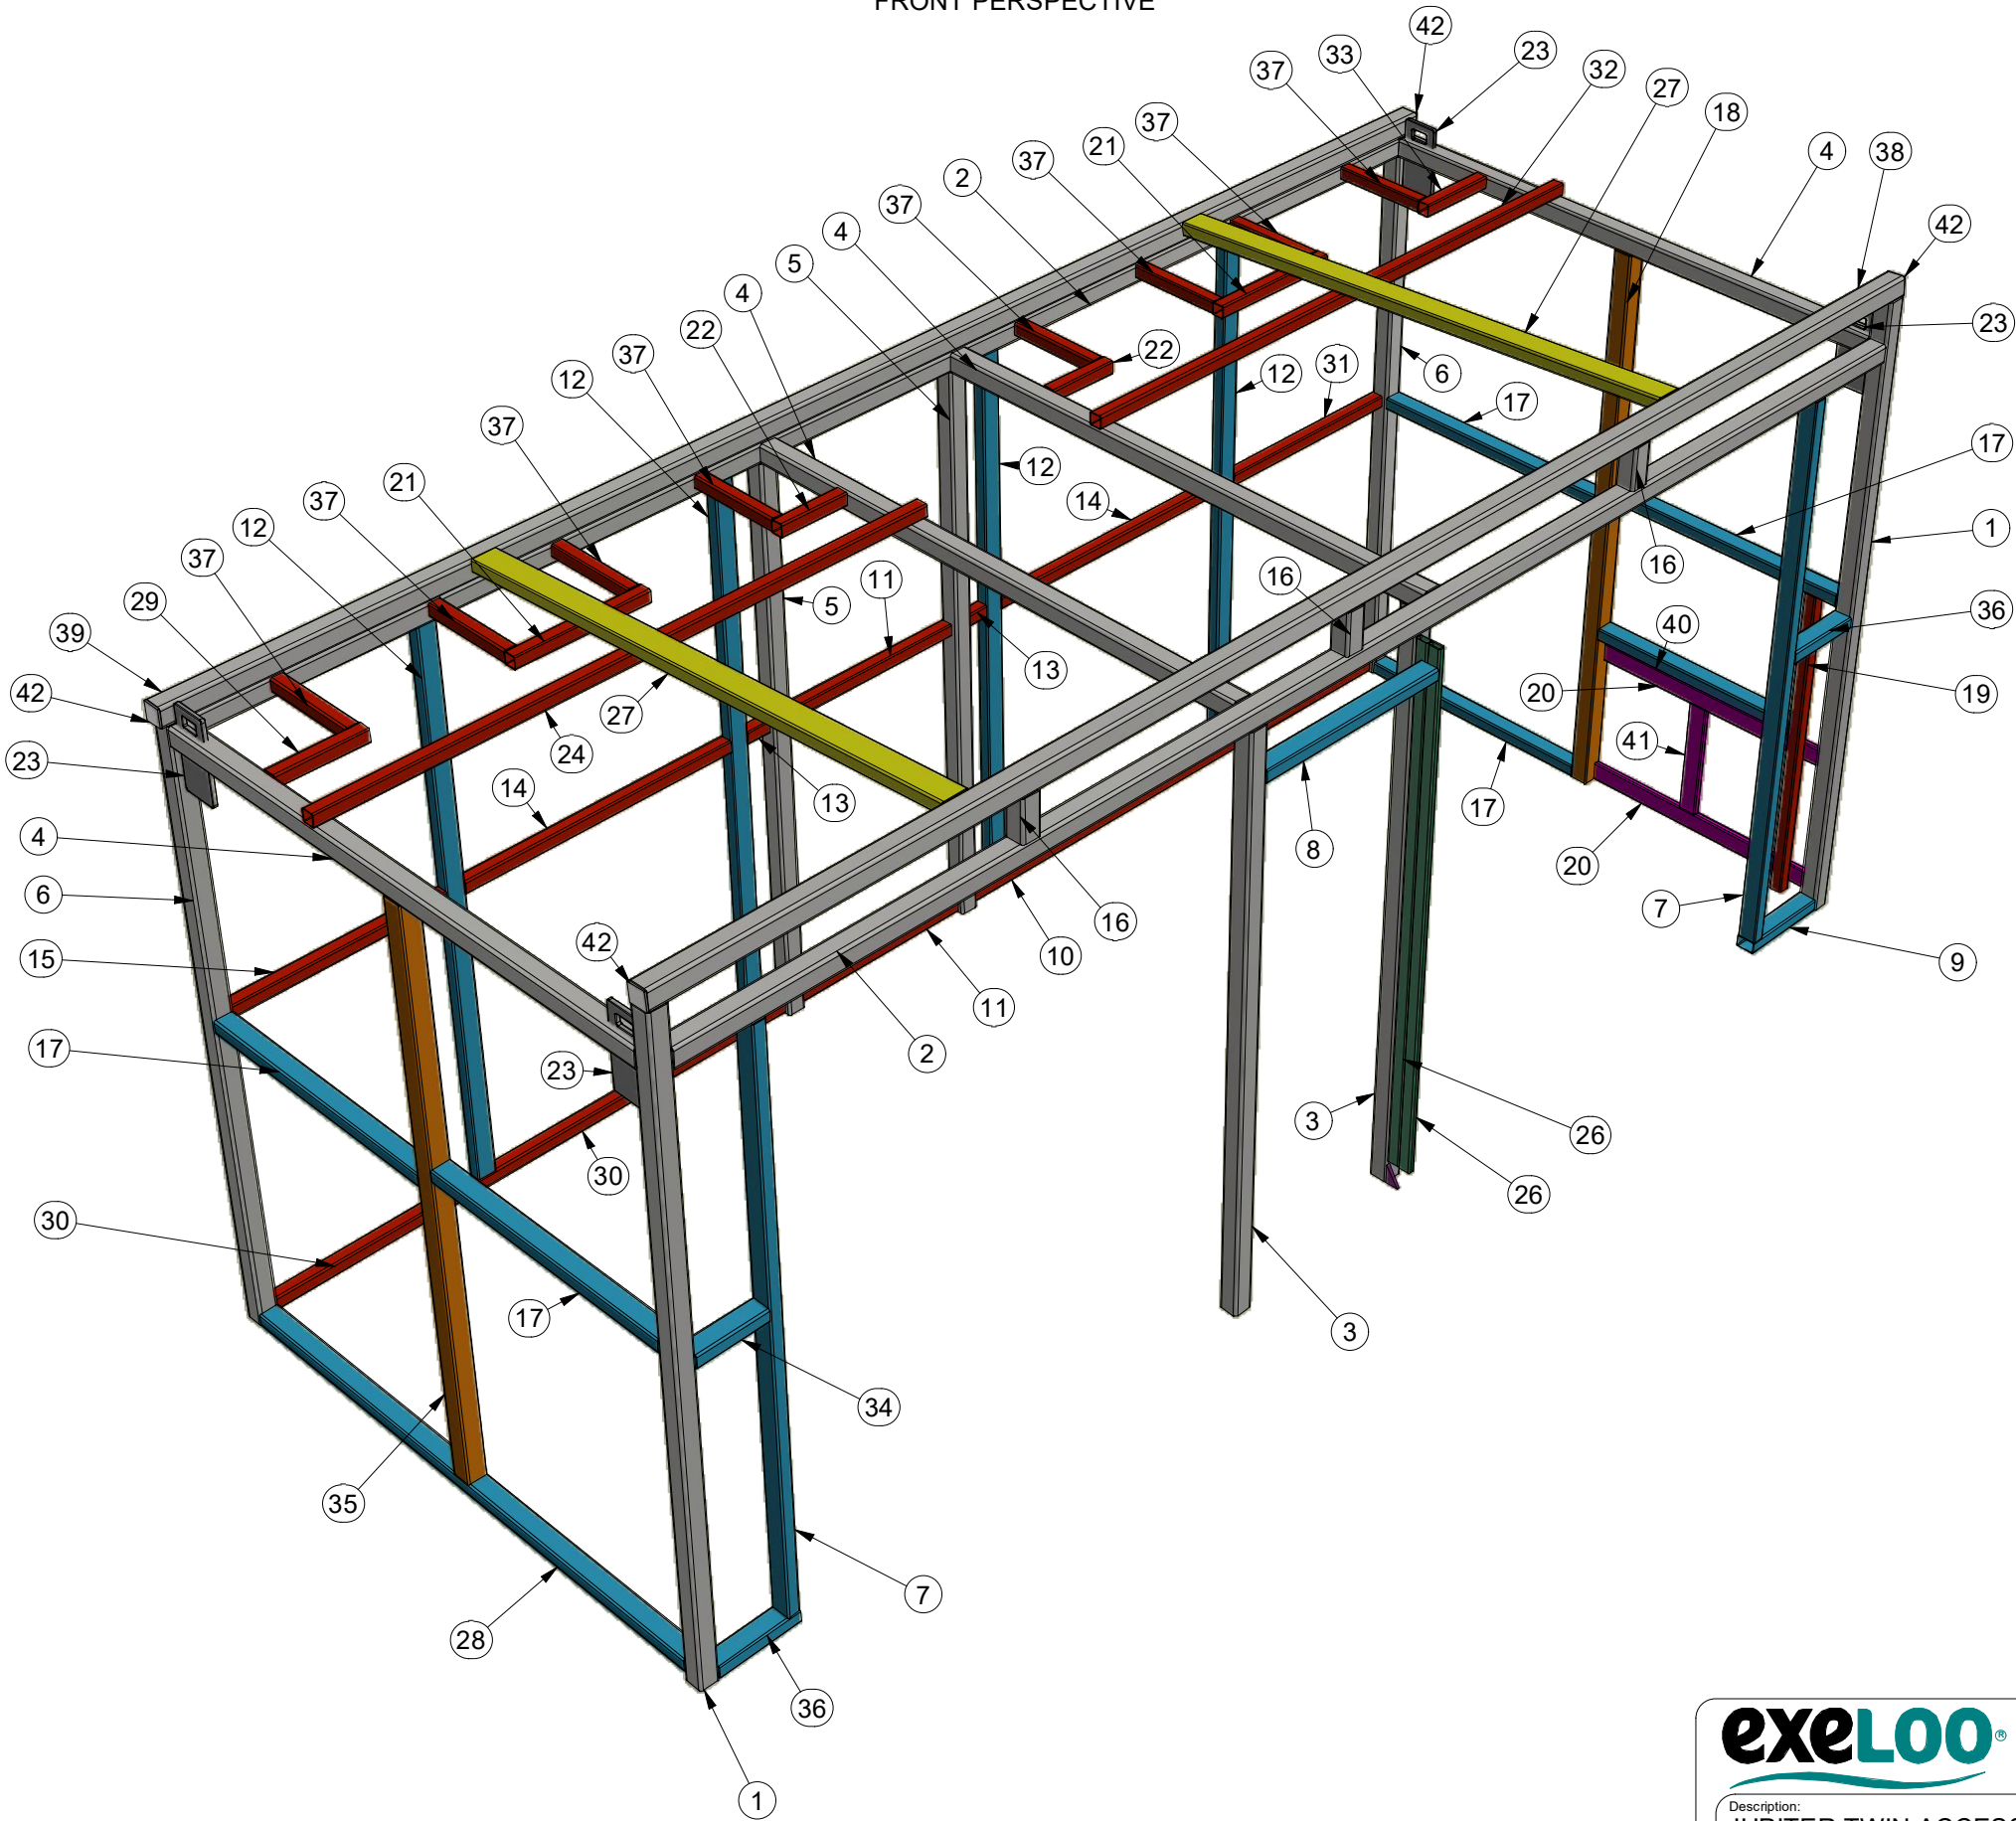

Parts List

ITEM	PART NUMBER	ITEM QTY	UNIT QTY	QTY
1	AS 1163 - C350L0 75x75x5.0 SHS - 2558	2	100 ¹¹ / ₁₆ in	201 ⁷ / ₁₆ in
2	AS 1163 - C350L0 75x75x5.0 SHS - 5375	2	211 ⁵ / ₈ in	423 ¹ / ₄ in
3	AS 1163 - C350L0 75x75x5.0 SHS - 2325	3	91 ⁹ / ₁₆ in	274 ⁵ / ₈ in
4	AS 1163 - C350L0 75x75x5.0 SHS - 2125	4	83 ¹¹ / ₁₆ in	334 ⁵ / ₈ in
5	AS 1163 - C350L0 75x75x5.0 SHS - 2295	2	90 ³ / ₈ in	180 ¹¹ / ₁₆ in
6	AS 1163 - C350L0 75x75x5.0 SHS - 2370	2	93 ⁵ / ₁₆ in	186 ⁵ / ₈ in
7	AS 1163 - C350L0 75x50x3.0 RHS - 2275	6	89 ⁹ / ₁₆ in	537 ³ / ₈ in
8	AS 1163 - C350L0 75x50x3.0 RHS - 780	1	30 ¹¹ / ₁₆ in	30 ¹¹ / ₁₆ in
9	AS 1163 - C350L0 75x50x3.0 RHS - 372.5	1	14 ¹¹ / ₁₆ in	14 ¹¹ / ₁₆ in
10	AS 1163 - C350L0 50x50x3.0 SHS - 2212.5	1	87 ¹ / ₈ in	87 ¹ / ₈ in
11	AS 1163 - C350L0 50x50x3.0 SHS - 780	2	30 ¹¹ / ₁₆ in	61 ⁷ / ₁₆ in
12	AS 1163 - C350L0 75x50x3.0 RHS - 2245	4	88 ³ / ₈ in	353 ⁹ / ₁₆ in
13	AS 1163 - C350L0 50x50x3.0 SHS - 99.5	2	3 ¹⁵ / ₁₆ in	7 ¹³ / ₁₆ in
14	AS 1163 - C350L0 50x50x3.0 SHS - 1135	2	44 ¹¹ / ₁₆ in	89 ³ / ₈ in
15	AS 1163 - C350L0 50x50x3.0 SHS - 848	1	33 ³ / ₈ in	33 ³ / ₈ in
16	AS 1163 - C350L0 75x75x5.0 SHS - 158	3	6 ¹ / ₄ in	18 ¹¹ / ₁₆ in
17	AS 1163 - C350L0 75x50x3.0 RHS - 1025	6	40 ³ / ₈ in	242 ¹ / ₈ in
18	AS 1163 - C350L0 75x75x3.0 SHS - 2295	2	90 ³ / ₈ in	180 ¹¹ / ₁₆ in
19	AS 1163 - C350L0 50x50x3.0 SHS - 1311	2	51 ⁵ / ₈ in	103 ¹ / ₄ in
20	AS 1163 - C350L0 75x25x2.5 RHS - 1025	4	40 ³ / ₈ in	161 ⁷ / ₁₆ in
21	AS 1163 - C350L0 50x50x3.0 SHS - 533	2	21 in	41 ¹⁵ / ₁₆ in
22	AS 1163 - C350L0 50x50x3.0 SHS - 279	2	11 in	21 ¹⁵ / ₁₆ in
23	55254235	4	¹ / ₁₆ in	³ / ₁₆ in
24	AS 1163 - C350L0 50x50x3.0 SHS - 2382.5	1	93 ¹³ / ₁₆ in	93 ¹³ / ₁₆ in
25	55250622	2	¹ / ₁₆ in	¹ / ₁₆ in
26	AS 1163 - C350L0 50x25x3.0 RHS - 2125	2	83 ¹¹ / ₁₆ in	167 ⁵ / ₁₆ in
27	AS 1163 - C350L0 100x50x3.0 RHS - 2126.126	2	83 ¹¹ / ₁₆ in	167 ⁷ / ₁₆ in
28	AS 1163 - C350L0 75x50x3.0 RHS - 2125	2	83 ¹¹ / ₁₆ in	167 ⁵ / ₁₆ in
29	AS 1163 - C350L0 50x50x3.0 SHS - 340.5	1	13 ³ / ₈ in	13 ³ / ₈ in
30	AS 1163 - C350L0 50x50x3.0 SHS - 2232.5	1	87 ⁷ / ₈ in	87 ⁷ / ₈ in
31	AS 1163 - C350L0 50x50x3.0 SHS - 828	1	32 ⁵ / ₈ in	32 ⁵ / ₈ in
32	AS 1163 - C350L0 50x50x3.0 SHS - 2362.5	1	93 in	93 in
33	AS 1163 - C350L0 50x50x3.0 SHS - 320.5	1	12 ⁵ / ₈ in	12 ⁵ / ₈ in
34	AS 1163 - C350L0 75x50x3.0 RHS - 272.5	1	10 ³ / ₄ in	10 ³ / ₄ in
35	AS 1163 - C350L0 75x75x3.0 SHS - 2245	1	88 ³ / ₈ in	88 ³ / ₈ in
36	AS 1163 - C350L0 75x50x3.0 RHS - 322.5	2	12 ¹¹ / ₁₆ in	25 ³ / ₈ in
37	AS 1163 - C350L0 50x50x3.0 SHS - 374	8	14 ³ / ₄ in	117 ¹³ / ₁₆ in
38	AS 1163 - C350L0 75x75x5.0 SHS - 5513	1	217 ¹ / ₁₆ in	217 ¹ / ₁₆ in
39	AS 1163 - C350L0 75x75x5.0 SHS - 5558	1	218 ¹³ / ₁₆ in	218 ¹³ / ₁₆ in
40	AS 1163 - C350L0 75x50x3.0 RHS - 891	2	35 ¹ / ₁₆ in	70 ³ / ₁₆ in
41	AS 1163 - C350L0 75x25x2.5 RHS - 478	2	18 ¹³ / ₁₆ in	37 ⁵ / ₈ in
42	55254335	4	¹ / ₁₆ in	³ / ₁₆ in

REV	DESCRIPTION	DATE
1-B	REMOVE ROOF OUTRIGGERS	29/04/2022



New Zealand
26 Paramount Dve Henderson 0610
PO Box 33-256 Takapuna, Auckland
T: +64-9-838-8912 F: +64-9-838-8913

Australia
Unit 18, 62-66 Newton Rd Wetherill Park
PO Box 12 Liverpool NSW 1871
T: +61-2-975-3444 F: +61-2-1-800-105-504

USA
954 Toro St San Luis Obispo CA 93401
PO Box 13310 San Luis Obispo CA 93406
T: (800) 676-5290 or 1-800-303-3506

Description:
**JUPITER TWIN ACCESSIBLE USA FRAME -
SINGLE BABY CHANGE**

Material:
REF

Proj:
Tolerance:
+/-0.5

Scale:
N.T.S.

Drawn by:
JJG

Creation Date:
11/05/2021

Units:
in
Checked by:

Rev.
1-B


Rev Date:
27/05/2022

Drawing No:
JUP22DD-US-TF1001

DO NOT SCALE - IF IN DOUBT ASK

SPECIFICATION SUBJECT TO CHANGE WITHOUT NOTICE

REAR PERSPECTIVE

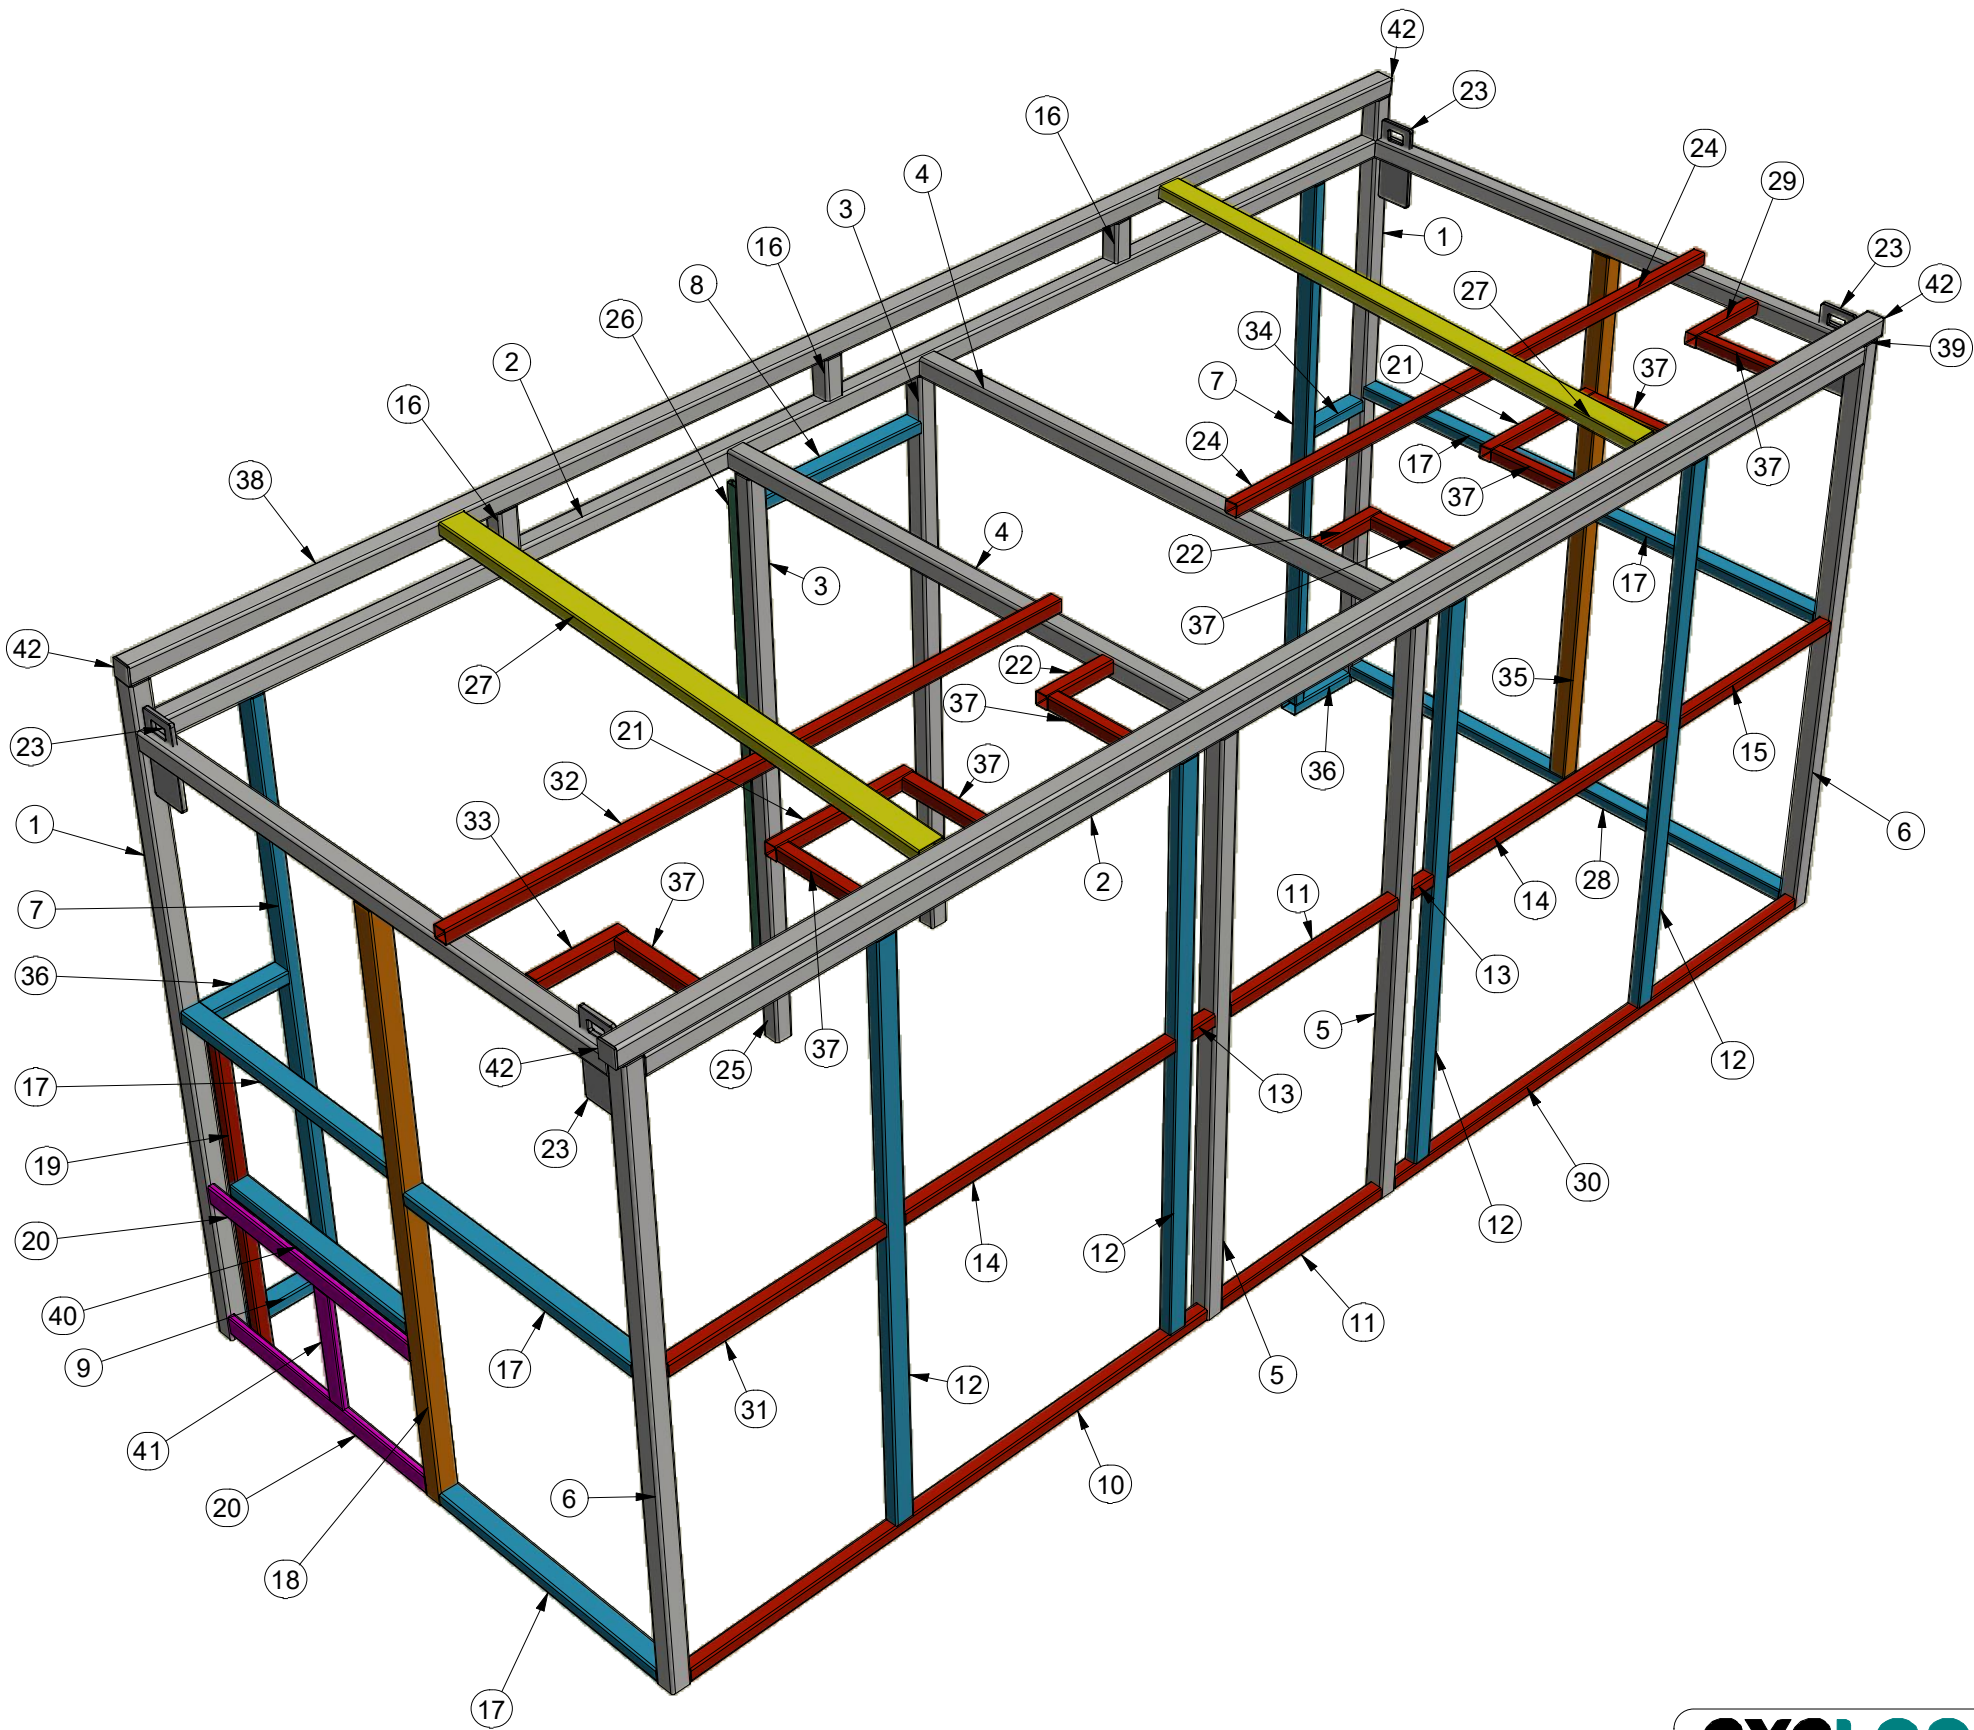

Parts List

ITEM	PART NUMBER	ITEM QTY	UNIT QTY	QTY
1	AS 1163 - C350L0 75x75x5.0 SHS - 2558	2	100 ¹¹ / ₁₆ in	201 ⁷ / ₁₆ in
2	AS 1163 - C350L0 75x75x5.0 SHS - 5375	2	211 ⁵ / ₈ in	423 ¹ / ₄ in
3	AS 1163 - C350L0 75x75x5.0 SHS - 2325	3	91 ⁹ / ₁₆ in	274 ⁵ / ₈ in
4	AS 1163 - C350L0 75x75x5.0 SHS - 2125	4	83 ¹¹ / ₁₆ in	334 ⁵ / ₈ in
5	AS 1163 - C350L0 75x75x5.0 SHS - 2295	2	90 ³ / ₈ in	180 ¹¹ / ₁₆ in
6	AS 1163 - C350L0 75x75x5.0 SHS - 2370	2	93 ⁵ / ₁₆ in	186 ⁵ / ₈ in
7	AS 1163 - C350L0 75x50x3.0 RHS - 2275	6	89 ⁹ / ₁₆ in	537 ³ / ₈ in
8	AS 1163 - C350L0 75x50x3.0 RHS - 780	1	30 ¹¹ / ₁₆ in	30 ¹¹ / ₁₆ in
9	AS 1163 - C350L0 75x50x3.0 RHS - 372.5	1	14 ¹¹ / ₁₆ in	14 ¹¹ / ₁₆ in
10	AS 1163 - C350L0 50x50x3.0 SHS - 2212.5	1	87 ¹ / ₈ in	87 ¹ / ₈ in
11	AS 1163 - C350L0 50x50x3.0 SHS - 780	2	30 ¹¹ / ₁₆ in	61 ⁷ / ₁₆ in
12	AS 1163 - C350L0 75x50x3.0 RHS - 2245	4	88 ³ / ₈ in	353 ⁹ / ₁₆ in
13	AS 1163 - C350L0 50x50x3.0 SHS - 99.5	2	3 ¹⁵ / ₁₆ in	7 ¹³ / ₁₆ in
14	AS 1163 - C350L0 50x50x3.0 SHS - 1135	2	44 ¹¹ / ₁₆ in	89 ³ / ₈ in
15	AS 1163 - C350L0 50x50x3.0 SHS - 848	1	33 ³ / ₈ in	33 ³ / ₈ in
16	AS 1163 - C350L0 75x75x5.0 SHS - 158	3	6 ¹ / ₄ in	18 ¹¹ / ₁₆ in
17	AS 1163 - C350L0 75x50x3.0 RHS - 1025	6	40 ³ / ₈ in	242 ¹ / ₈ in
18	AS 1163 - C350L0 75x75x3.0 SHS - 2295	2	90 ³ / ₈ in	180 ¹¹ / ₁₆ in
19	AS 1163 - C350L0 50x50x3.0 SHS - 1311	2	51 ⁵ / ₈ in	103 ¹ / ₄ in
20	AS 1163 - C350L0 75x25x2.5 RHS - 1025	4	40 ³ / ₈ in	161 ⁷ / ₁₆ in
21	AS 1163 - C350L0 50x50x3.0 SHS - 533	2	21 in	41 ¹⁵ / ₁₆ in
22	AS 1163 - C350L0 50x50x3.0 SHS - 279	2	11 in	21 ¹⁵ / ₁₆ in
23	55254235	4	¹ / ₁₆ in	³ / ₁₆ in
24	AS 1163 - C350L0 50x50x3.0 SHS - 2382.5	1	93 ¹³ / ₁₆ in	93 ¹³ / ₁₆ in
25	55250622	2	¹ / ₁₆ in	¹ / ₁₆ in
26	AS 1163 - C350L0 50x25x3.0 RHS - 2125	2	83 ¹¹ / ₁₆ in	167 ⁵ / ₁₆ in
27	AS 1163 - C350L0 100x50x3.0 RHS - 2126.126	2	83 ¹¹ / ₁₆ in	167 ⁷ / ₁₆ in
28	AS 1163 - C350L0 75x50x3.0 RHS - 2125	2	83 ¹¹ / ₁₆ in	167 ⁵ / ₁₆ in
29	AS 1163 - C350L0 50x50x3.0 SHS - 340.5	1	13 ³ / ₈ in	13 ³ / ₈ in
30	AS 1163 - C350L0 50x50x3.0 SHS - 2232.5	1	87 ⁷ / ₈ in	87 ⁷ / ₈ in
31	AS 1163 - C350L0 50x50x3.0 SHS - 828	1	32 ⁵ / ₈ in	32 ⁵ / ₈ in
32	AS 1163 - C350L0 50x50x3.0 SHS - 2362.5	1	93 in	93 in
33	AS 1163 - C350L0 50x50x3.0 SHS - 320.5	1	12 ⁵ / ₈ in	12 ⁵ / ₈ in
34	AS 1163 - C350L0 75x50x3.0 RHS - 272.5	1	10 ³ / ₄ in	10 ³ / ₄ in
35	AS 1163 - C350L0 75x75x3.0 SHS - 2245	1	88 ³ / ₈ in	88 ³ / ₈ in
36	AS 1163 - C350L0 75x50x3.0 RHS - 322.5	2	12 ¹¹ / ₁₆ in	25 ³ / ₈ in
37	AS 1163 - C350L0 50x50x3.0 SHS - 374	8	14 ³ / ₄ in	117 ¹³ / ₁₆ in
38	AS 1163 - C350L0 75x75x5.0 SHS - 5513	1	217 ¹ / ₁₆ in	217 ¹ / ₁₆ in
39	AS 1163 - C350L0 75x75x5.0 SHS - 5558	1	218 ¹³ / ₁₆ in	218 ¹³ / ₁₆ in
40	AS 1163 - C350L0 75x50x3.0 RHS - 891	2	35 ¹ / ₁₆ in	70 ³ / ₁₆ in
41	AS 1163 - C350L0 75x25x2.5 RHS - 478	2	18 ¹³ / ₁₆ in	37 ⁵ / ₈ in
42	55254335	4	¹ / ₁₆ in	³ / ₁₆ in



New Zealand
26 Paramount Dve Henderson 0610
PO Box 33-256 Takapuna, Auckland
T: +64-9-838-8912 F: +64-9-838-8913

Australia
Unit 18, 62-66 Newton Rd Wetherill Park
PO Box 12 Liverpool NSW 1871
T: +61-2-975-3444 F: +61-2-1-800-105-504

USA
954 Toro St San Luis Obispo CA 93401
PO Box 13310 San Luis Obispo CA 93406
T: (800) 676-5290 or 1-800-303-3506

Description:
**JUPITER TWIN ACCESSIBLE USA FRAME -
SINGLE BABY CHANGE**

Material:
REF

Proj:
Tolerance:
+/-0.5

Scale:
N.T.S.

Drawn by:
JJG





Creation Date:
11/05/2021

Units:
in
Checked by:

Rev.
1-B

Rev Date:
27/05/2022


Drawing No:
JUP22DD-US-TF1001

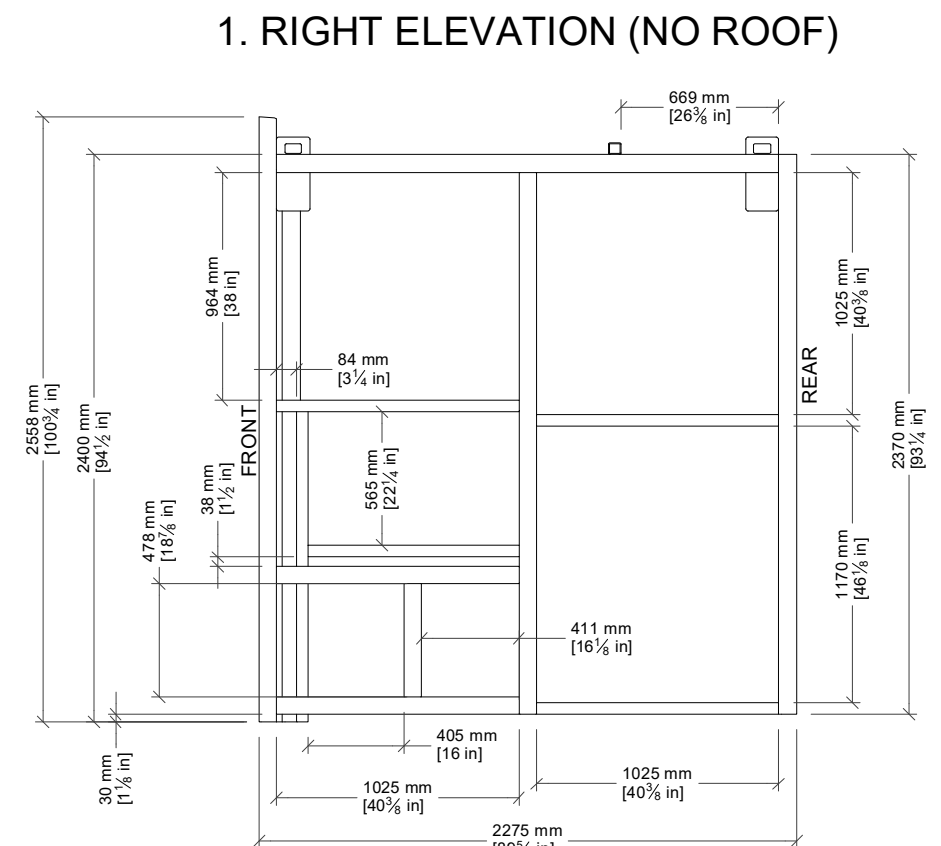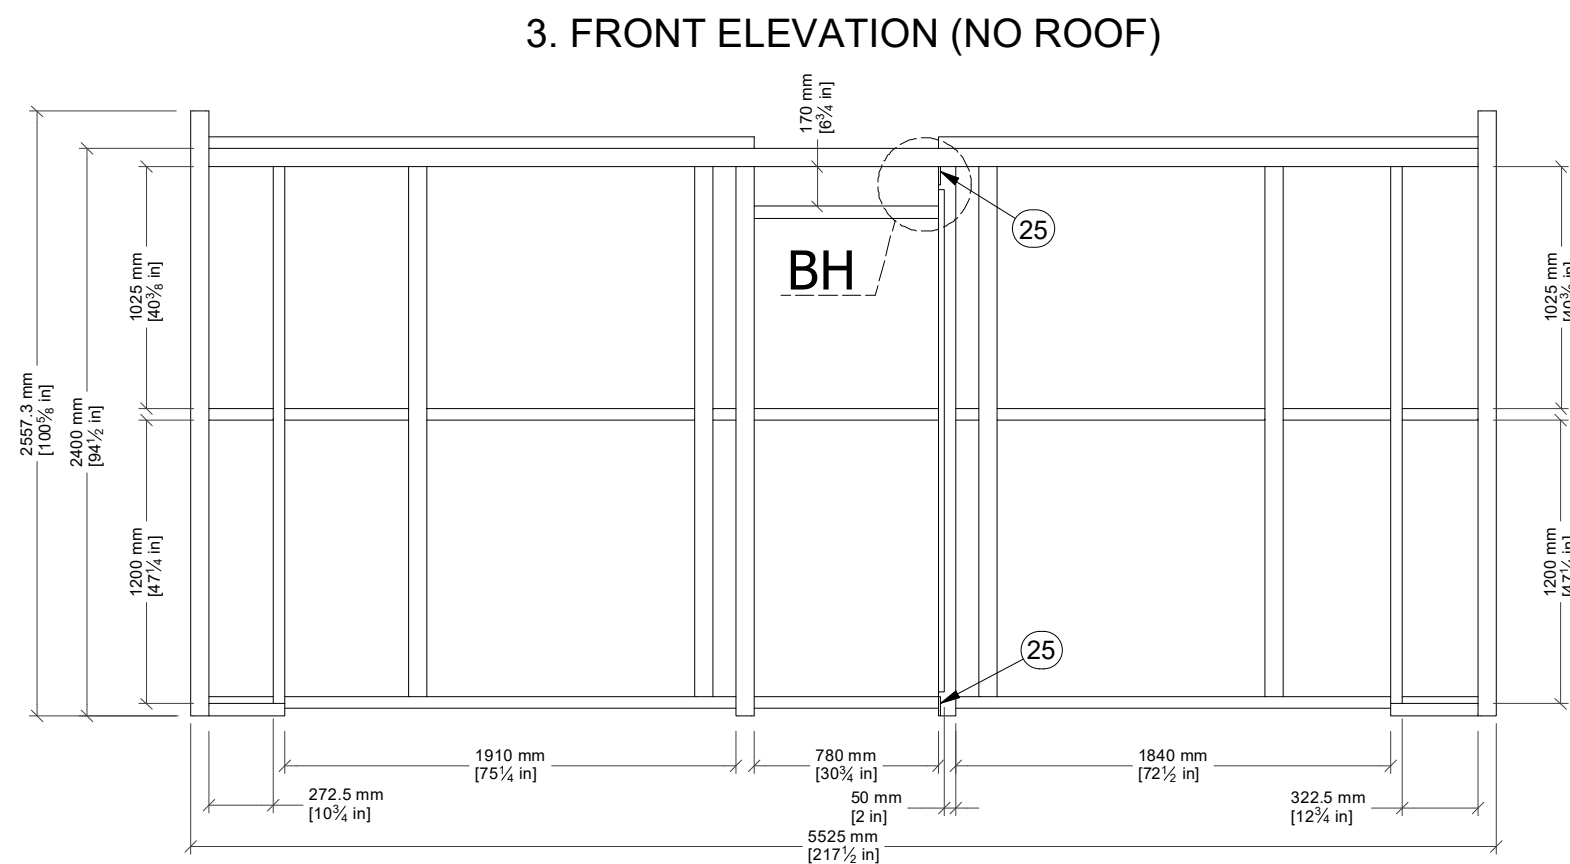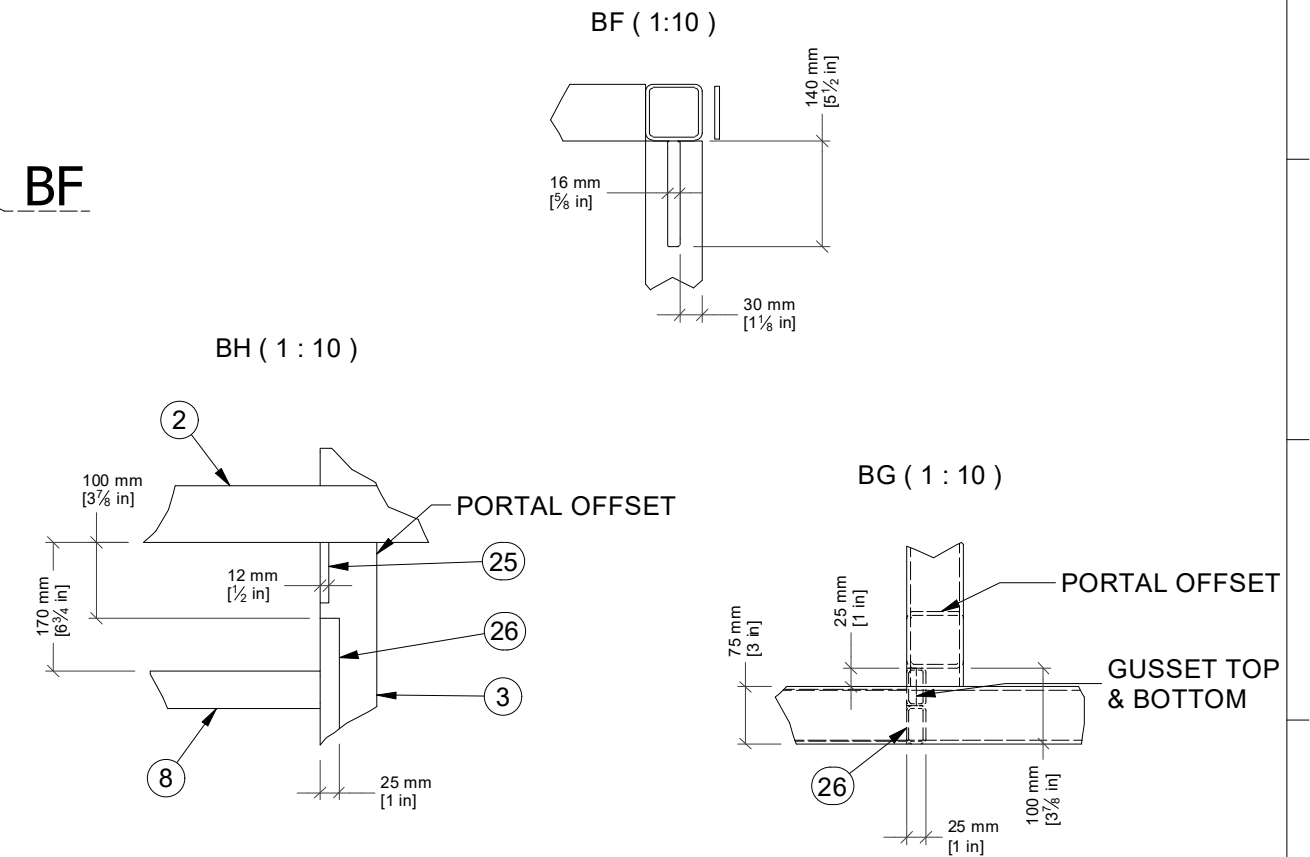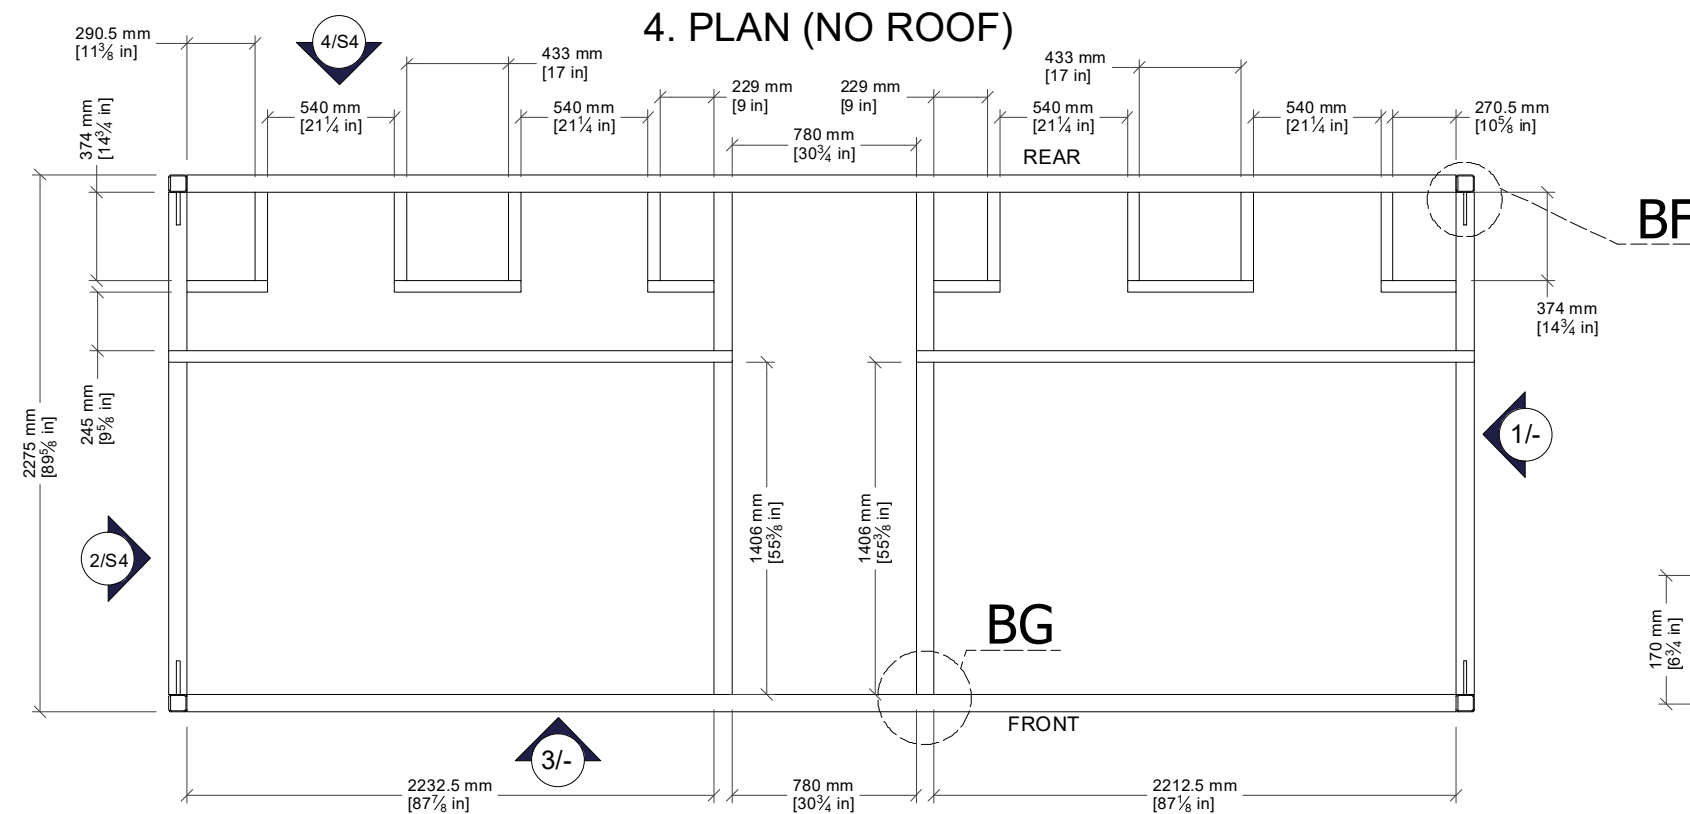


NOTE: MAX SPAN BETWEEN SUPPORTS IS <1200mm (47in) FOR COMPRESSED SHEET PANELS

		New Zealand 26 Paramount Dve Henderson 0610 PO Box 33-256 Takapuna, Auckland T: +64-9-838-8912 F: +64-9-838-8913	Australia Unit 18, 62-66 Newton Rd Wetherill Park PO Box 12 Liverpool NSW 1871 T: +61-2-975-3444 F: +61-2-1-800-105-504	USA 954 Toro St San Luis Obispo CA 93401 PO Box 13310 San Luis Obispo CA 93406 (800) 676-5290 or 1-800-303-3506
Description: JUPITER TWIN ACCESSIBLE USA FRAME - SINGLE BABY CHANGE		Proj:  Tolerance: +/-0.5 Scale: N.T.S. Drawn by: JJG Creation Date: 11/05/2021	Units: in Checked by: S 23 Sheet No: JUP22DD-US-TF1001	Rev. 1-B Rev Date: 27/05/2022 Approved by:
Material:	Finish: REF			


5. REAR ELEVATION (NO ROOF)

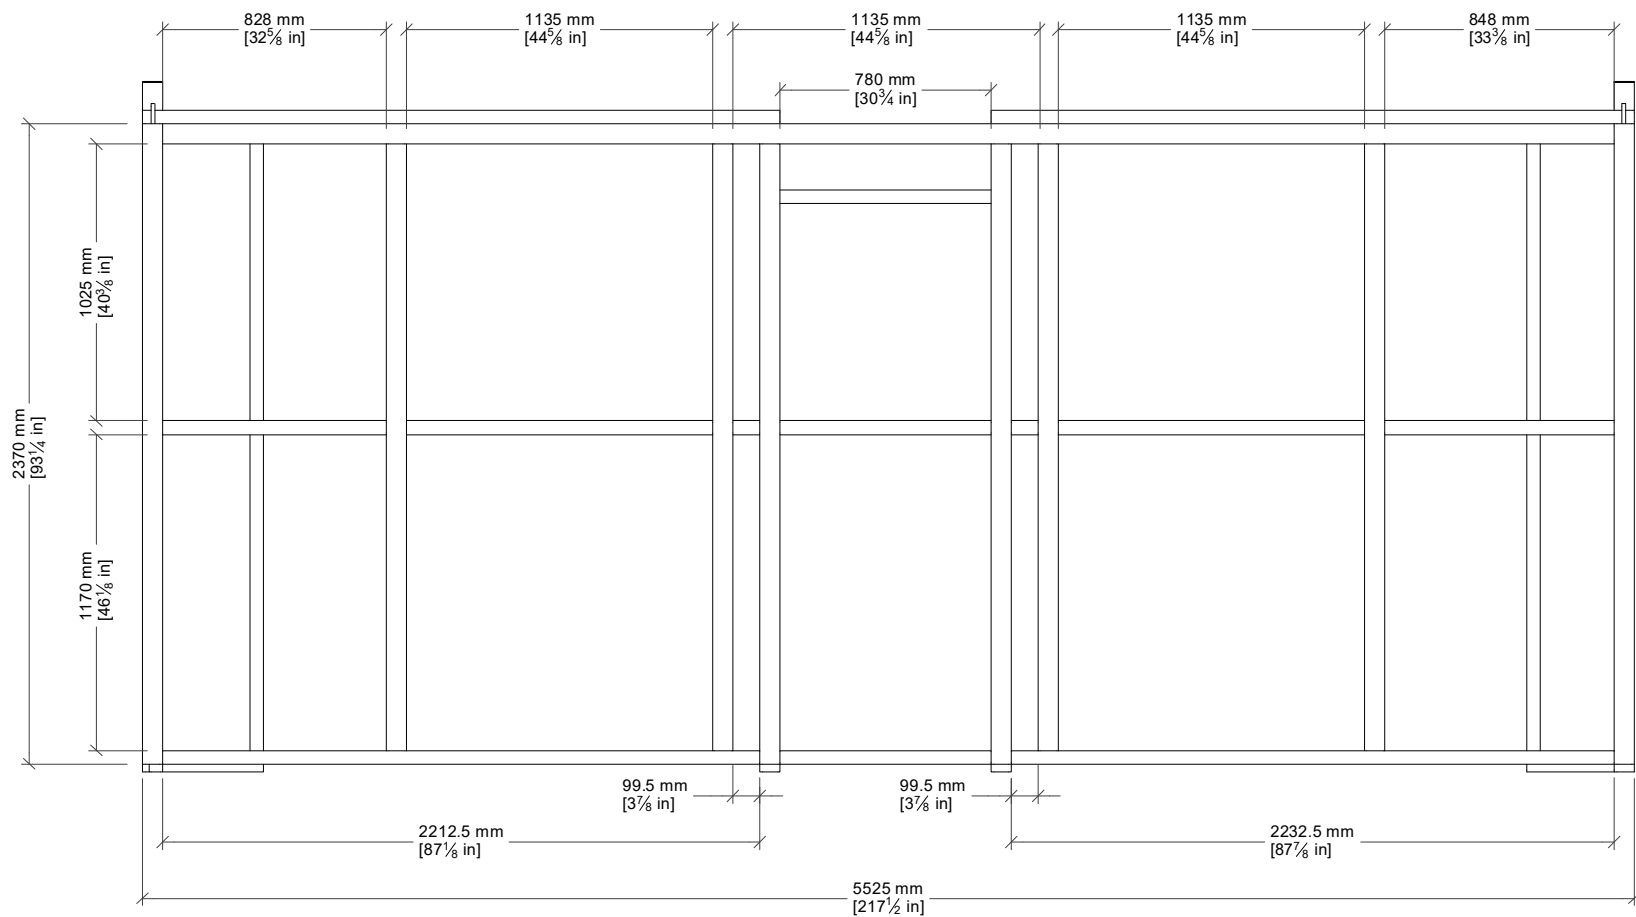


2. LEFT ELEVATION (NO ROOF)

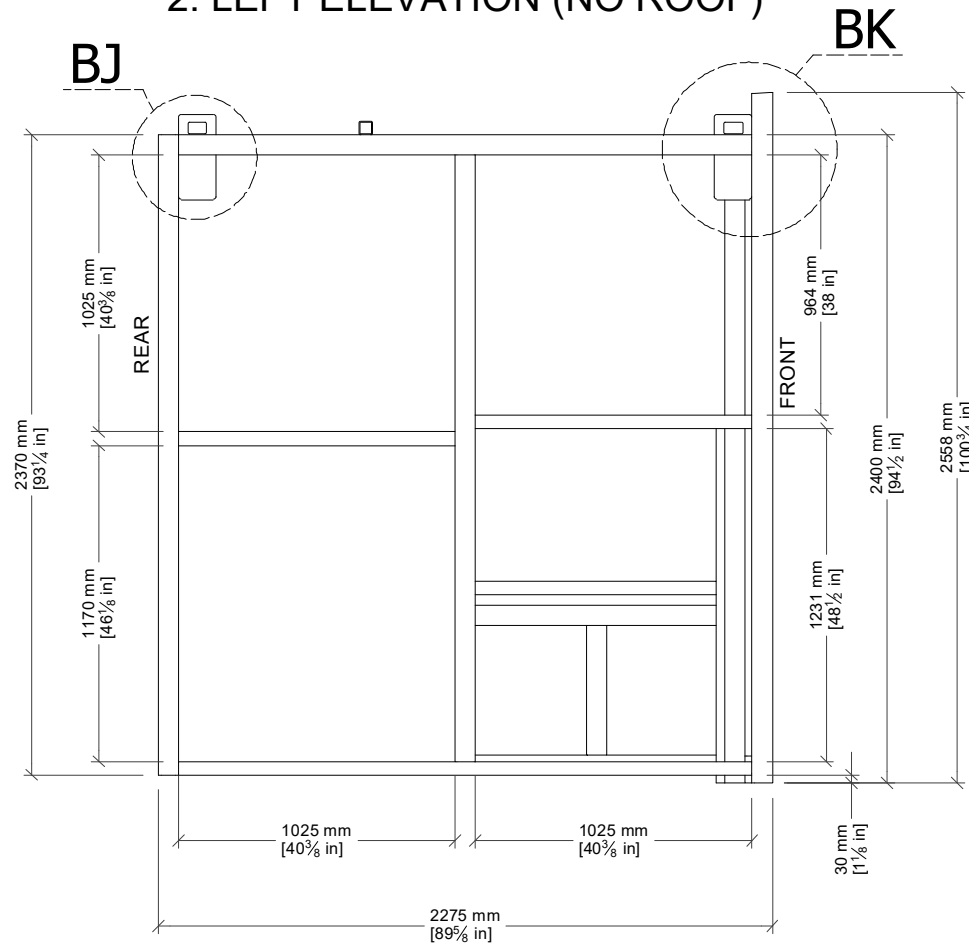

6. FRONT LIFTING PLATE
DETAIL VIEW BJ

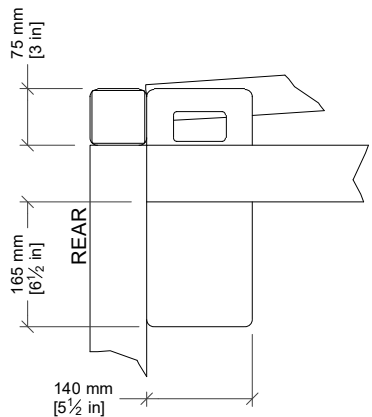

7. FRONT LIFTING PLATE
DETAIL VIEW BK

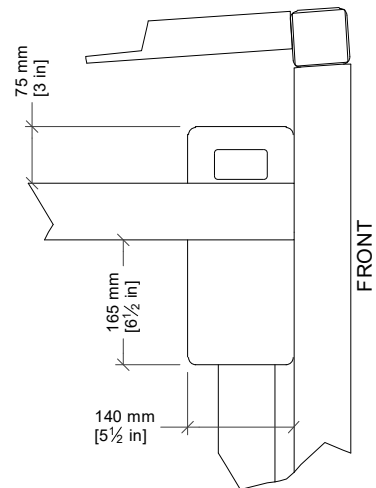


NOTE: MAX SPAN BETWEEN SUPPORTS IS <1200mm (47in) FOR COMPRESSED SHEET PANELS

exelOO®		New Zealand 26 Paramount Dve Henderson 0610 PO Box 33-256 Takapuna, Auckland T: +64-9-838-8912 F: +64-9-838-8913	Australia Unit 18, 62-66 Newton Rd Wetherill Park PO Box 12 Liverpool NSW 1871 T: +61-2-975-3444 F: +61-2-1-800-105-504	USA 954 Toro St San Luis Obispo CA 93401 PO Box 13310 San Luis Obispo CA 93406 T: (800) 676-5290 or 1-800-303-3506	
Description: JUPITER TWIN ACCESSIBLE USA FRAME - SINGLE BABY CHANGE		Proj: 	Units: in	Rev: 1-B	Rev Date: 27/05/2022
Tolerance: +/-0.5		Scale: N.T.S.	Checked by: Approved by:		
Material: REF	Finish: REF	Drawn by: JJG	Creation Date: 11/05/2021	Sheet No: S 24	Drawing No: JUP22DD-US-TF1001


DO NOT SCALE - IF IN DOUBT ASK

SPECIFICATION SUBJECT TO CHANGE WITHOUT NOTICE


PLAN VIEW

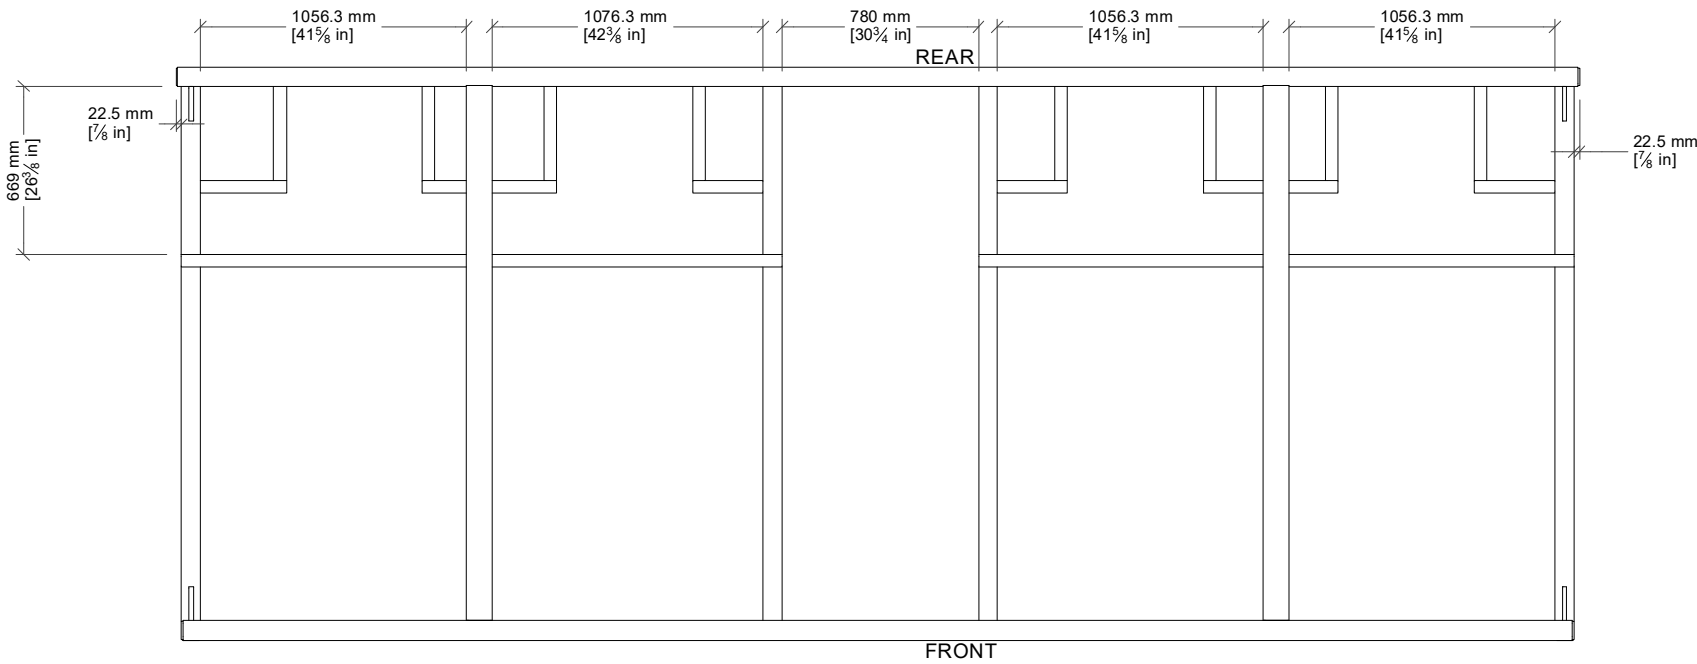

FRONT ELEVATION

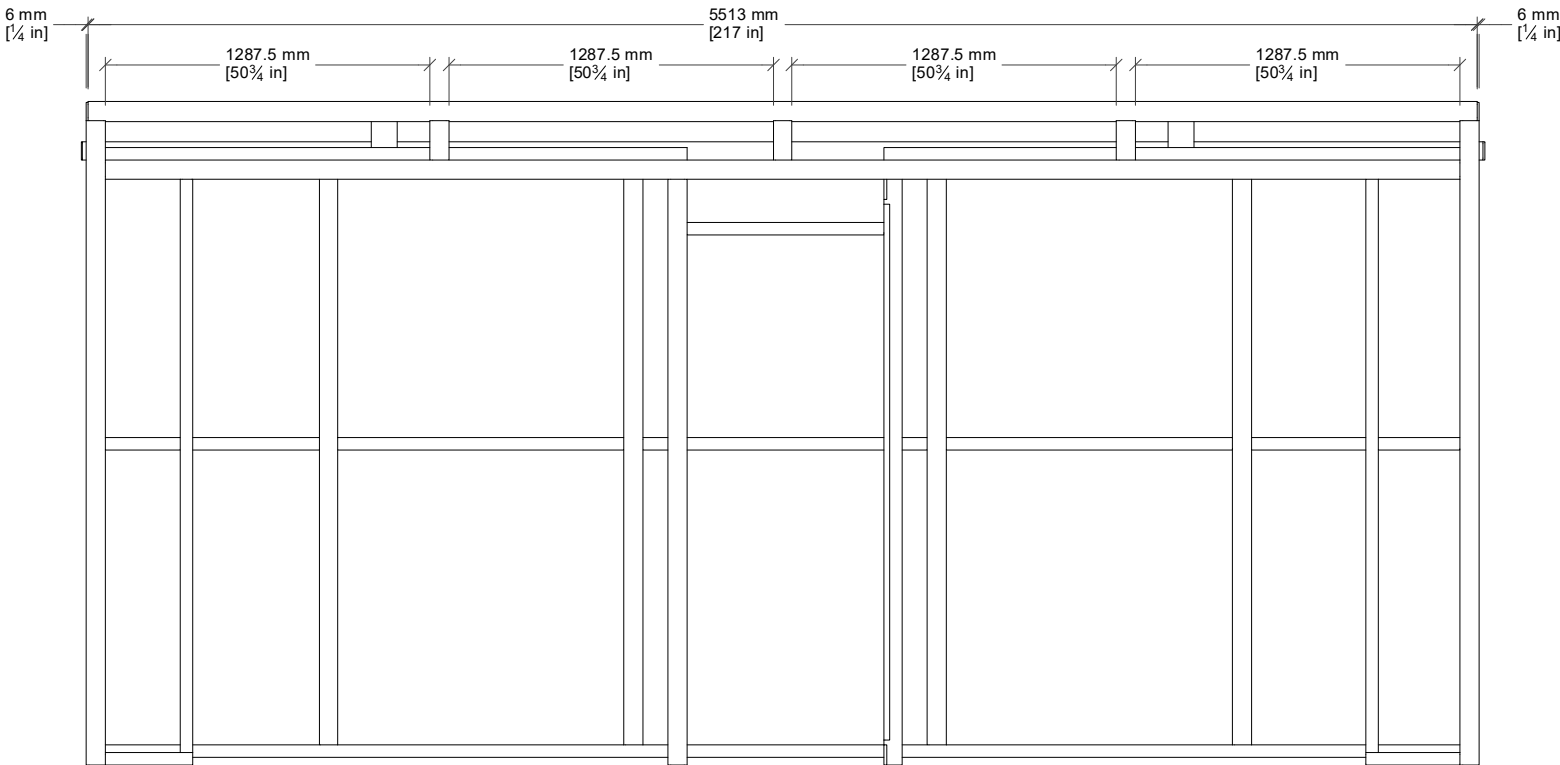

RIGHT ELEVATION

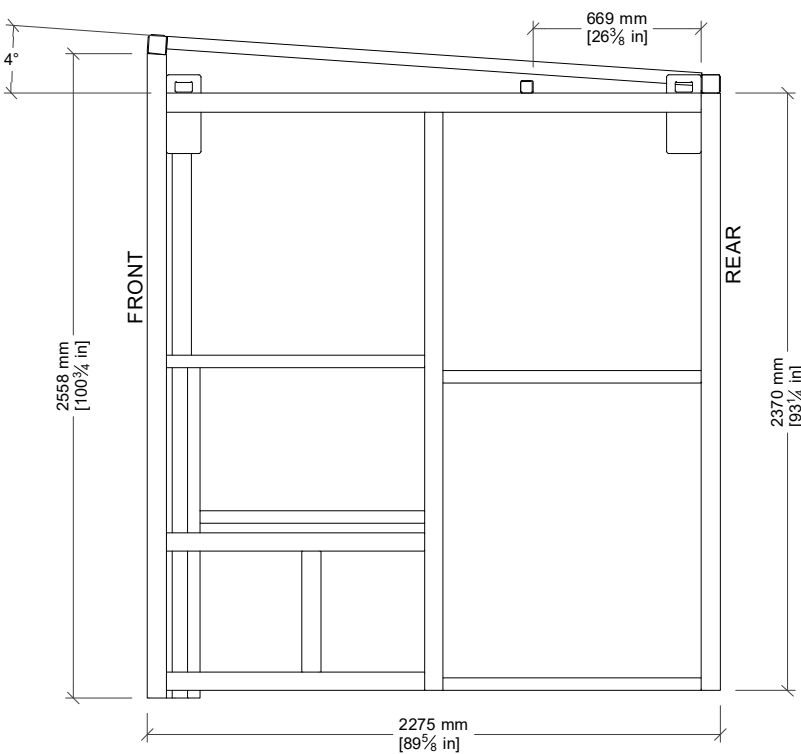

NOTE: MAX SPAN BETWEEN SUPPORTS IS <1200mm (47in) FOR COMPRESSED SHEET PANELS



New Zealand
26 Paramount Dve Henderson 0610
PO Box 33-256 Takapuna, Auckland
T: +64-9-838-8912 F: +64-9-838-8913

Australia
Unit 18, 62-66 Newton Rd Wetherill Park
PO Box 12 Liverpool NSW 1871
T: +61-2-975-3444 F: +61-2-1-800-105-504


USA
954 Toro St San Luis Obispo CA 93401
PO Box 13310 San Luis Obispo CA 93406
T: (800) 676-5290 or 1-800-303-3506

Description: JUPITER TWIN ACCESSIBLE USA FRAME - SINGLE BABY CHANGE		Proj: 	Units: in	Rev. 1-B	Rev Date. 27/05/2022
Tolerance: +/-0.5	Scale: N.T.S.	Drawn by: JJG	Creation Date: 11/05/2021	Sheet No. S 25	Approved by:
Material: REF	Finish: REF	Drawn by: JJG	Creation Date: 11/05/2021	Sheet No. S 25	Drawing No: JUP22DD-US-TF1001


DO NOT SCALE - IF IN DOUBT ASK

SPECIFICATION SUBJECT TO CHANGE WITHOUT NOTICE

FRONT ELEVATION

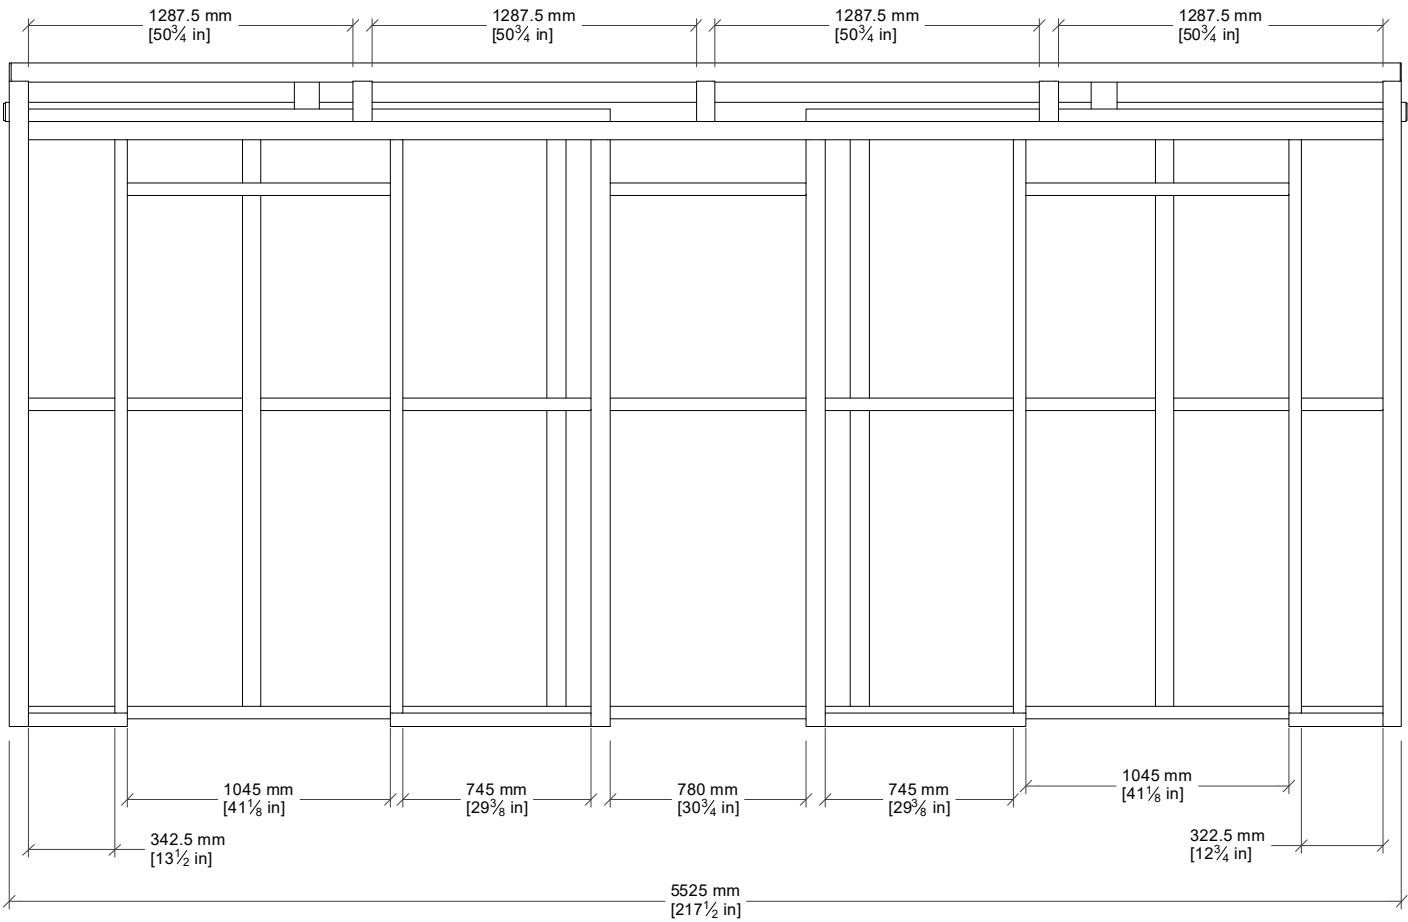

FRONT - ACCESSIBLE SWING DOOR

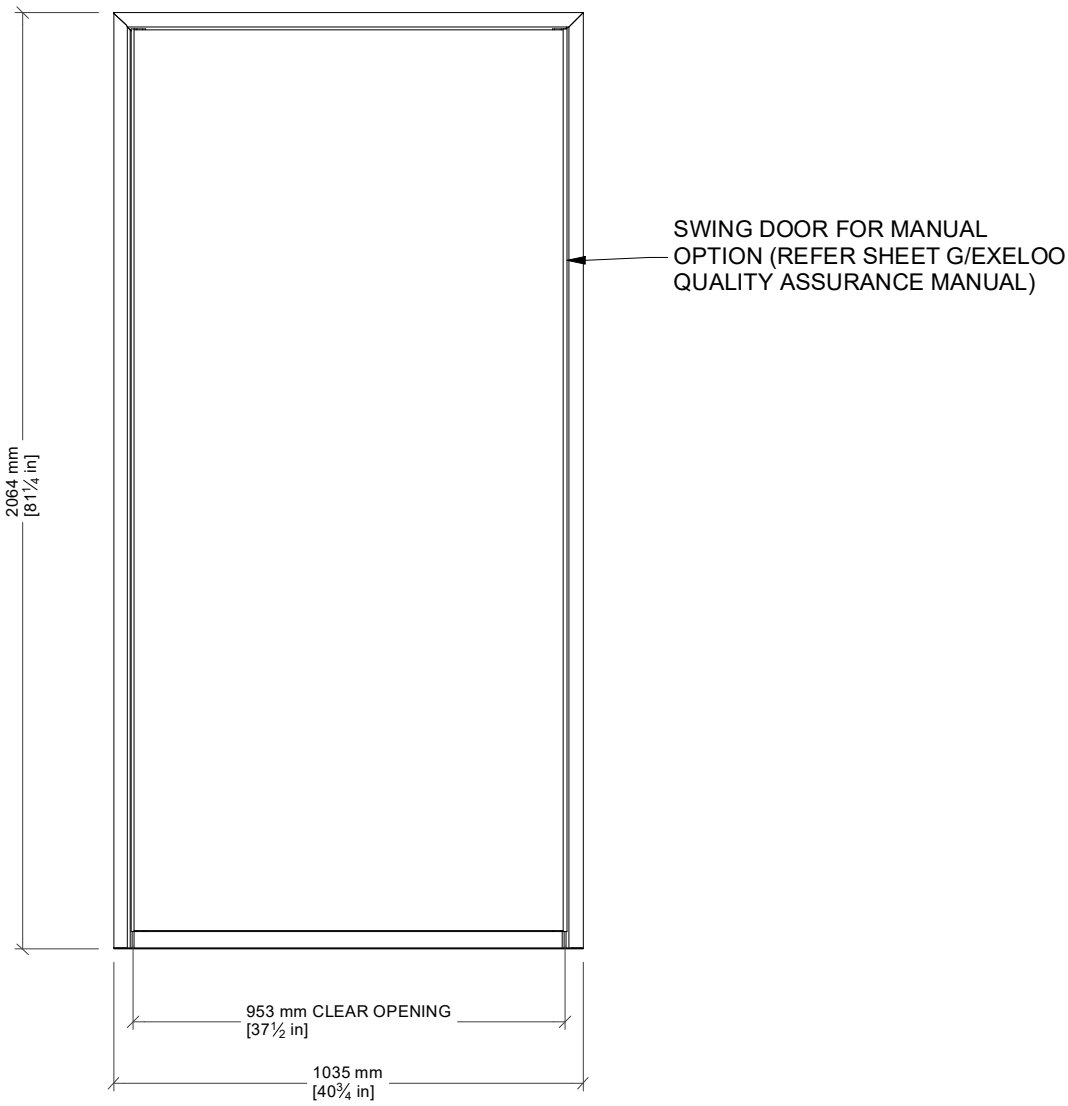

New Zealand
26 Paramount Dve Henderson 0610
PO Box 33-256 Takapuna, Auckland
T: +64-9-838-8912 F: +64-9-838-8913

Australia
Unit 18, 62-66 Newton Rd Wetherill Park
PO Box 12 Liverpool NSW 1871
T: +61-2-975-3444 F: +61-2-1-800-105-504

USA
954 Toro St San Luis Obispo CA 93401
PO Box 13310 San Luis Obispo CA 93406
T: (800) 676-5290 or 1-800-303-3506

Description:
JUPITER TWIN ACCESSIBLE USA FRAME - SINGLE BABY CHANGE



Tolerance:
+/-0.5

Scale:
N.T.S.

Drawn by:
JJG

Creation Date:
11/05/2021

Sheet No.
S 26

Drawing No:
JUP22DD-US-TF1001

Units:

in

Rev.


1-B

Rev Date:


27/05/2022

Checked by:

Approved by:

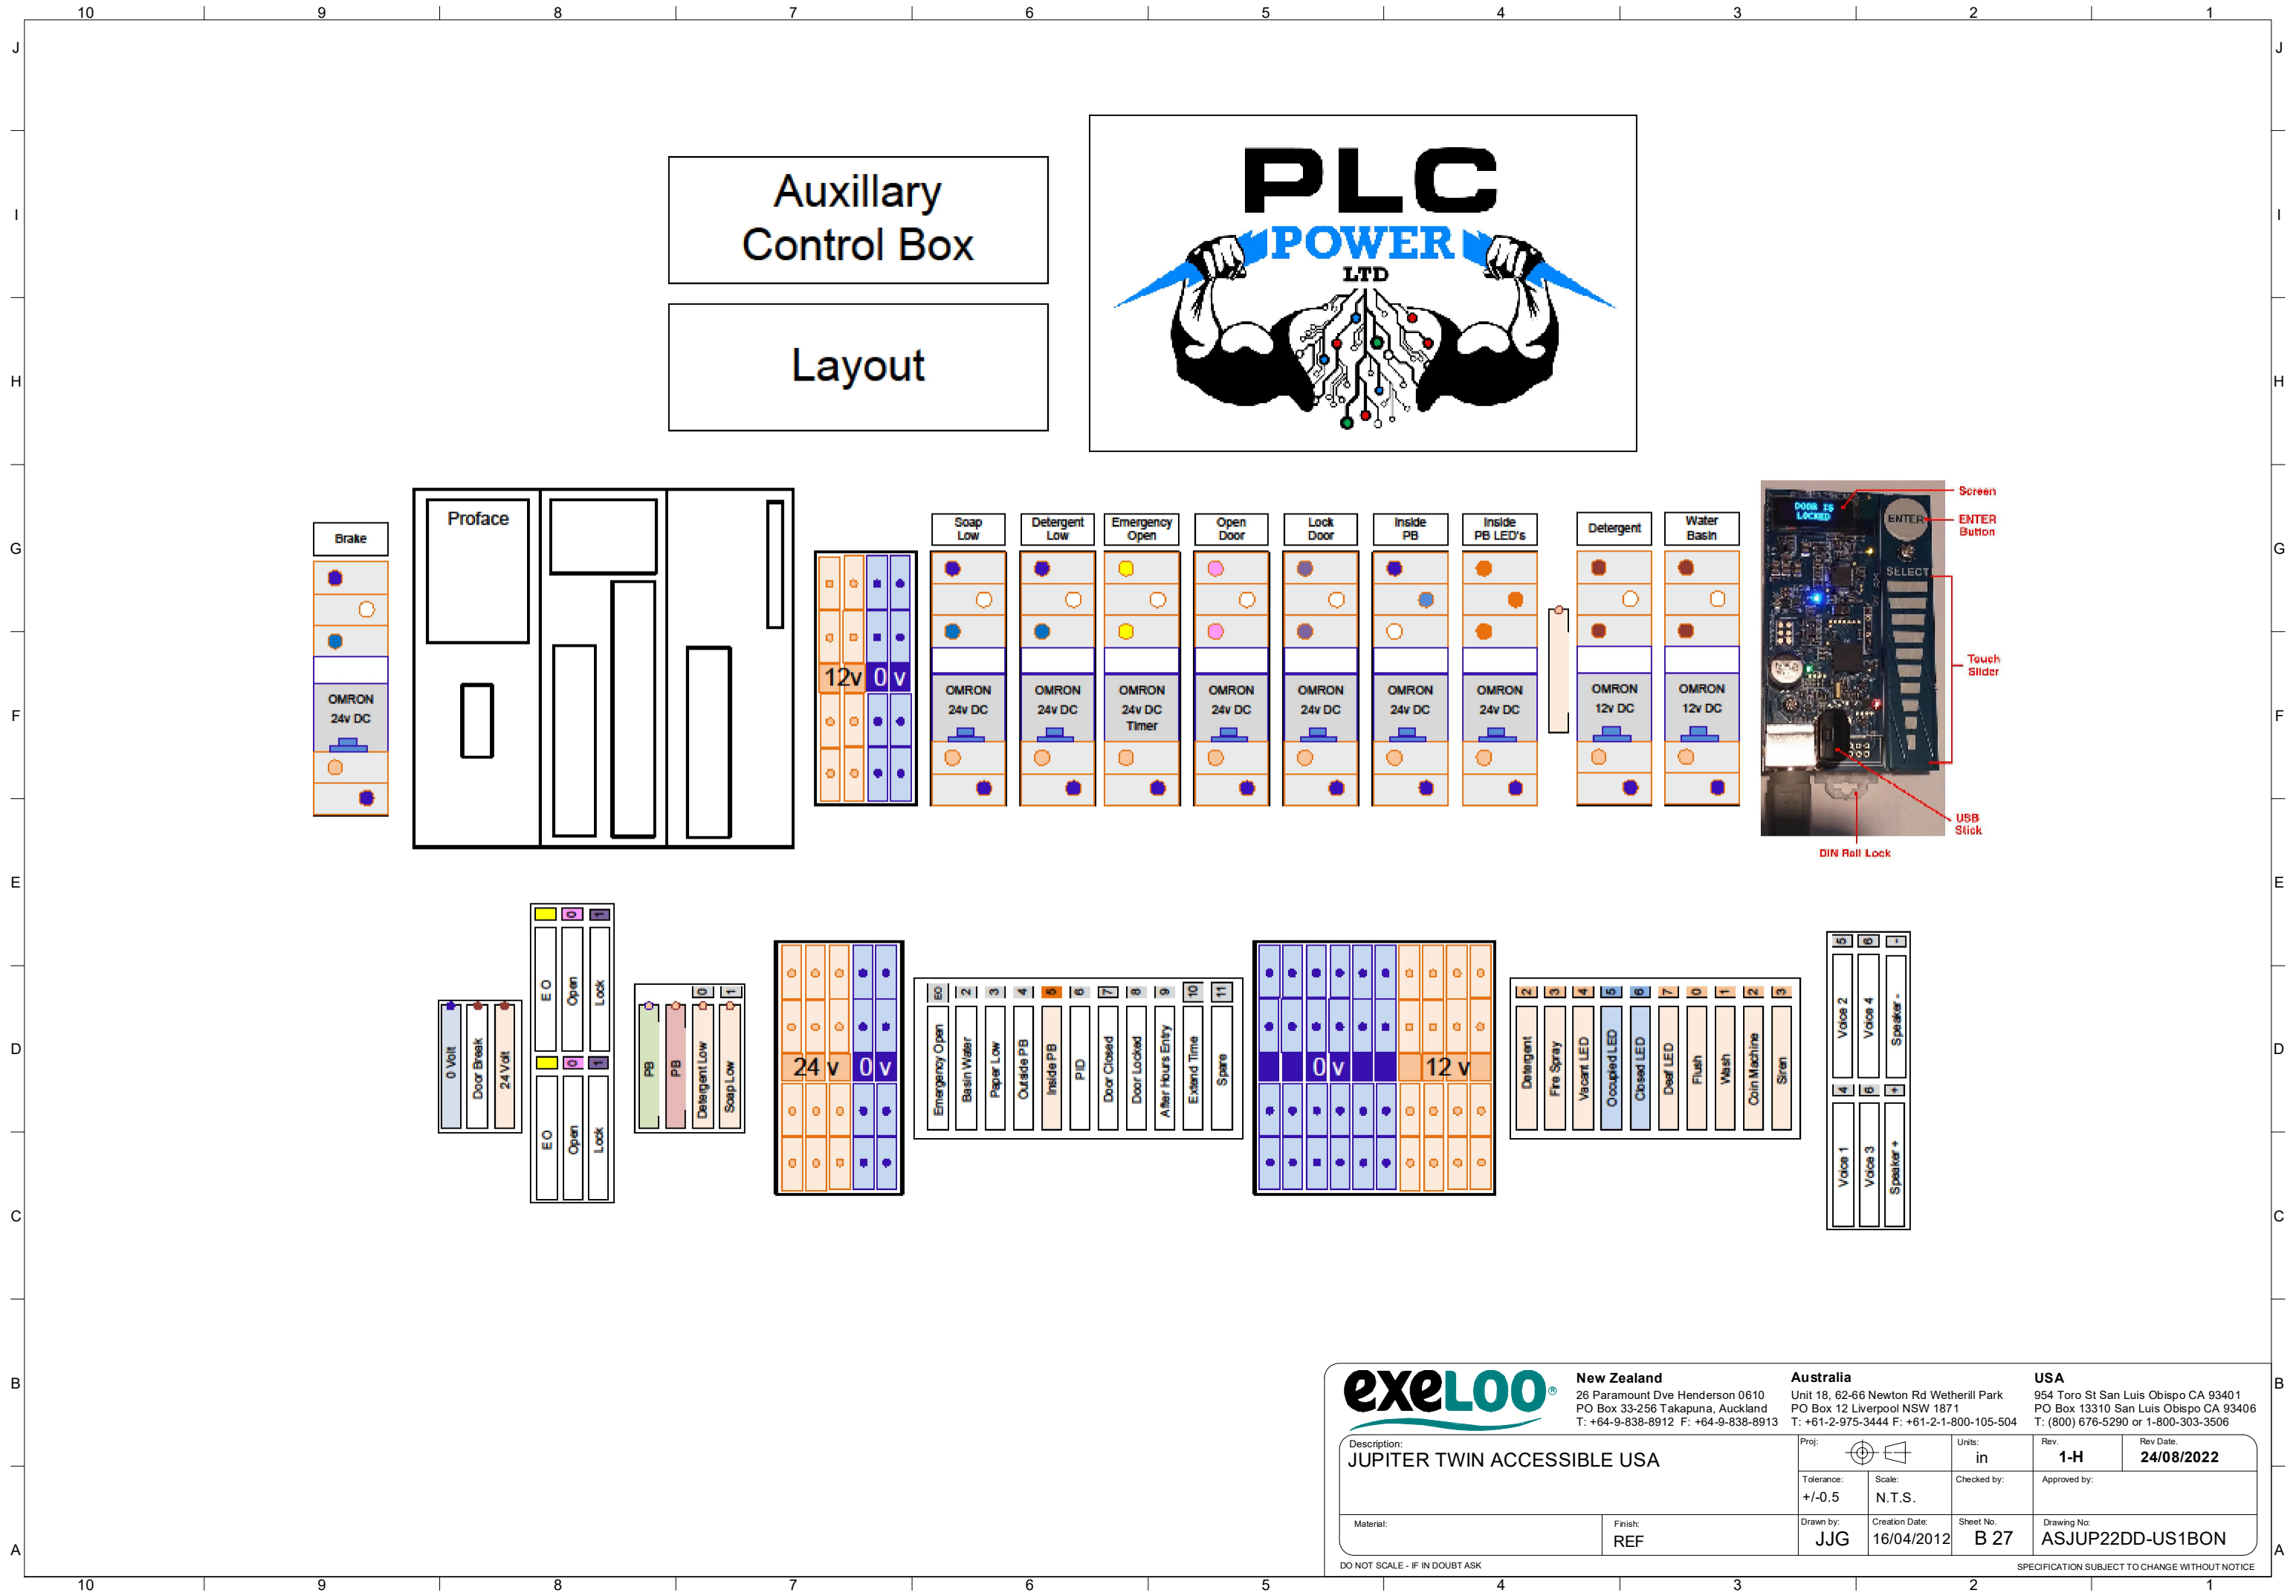

Main Control Box

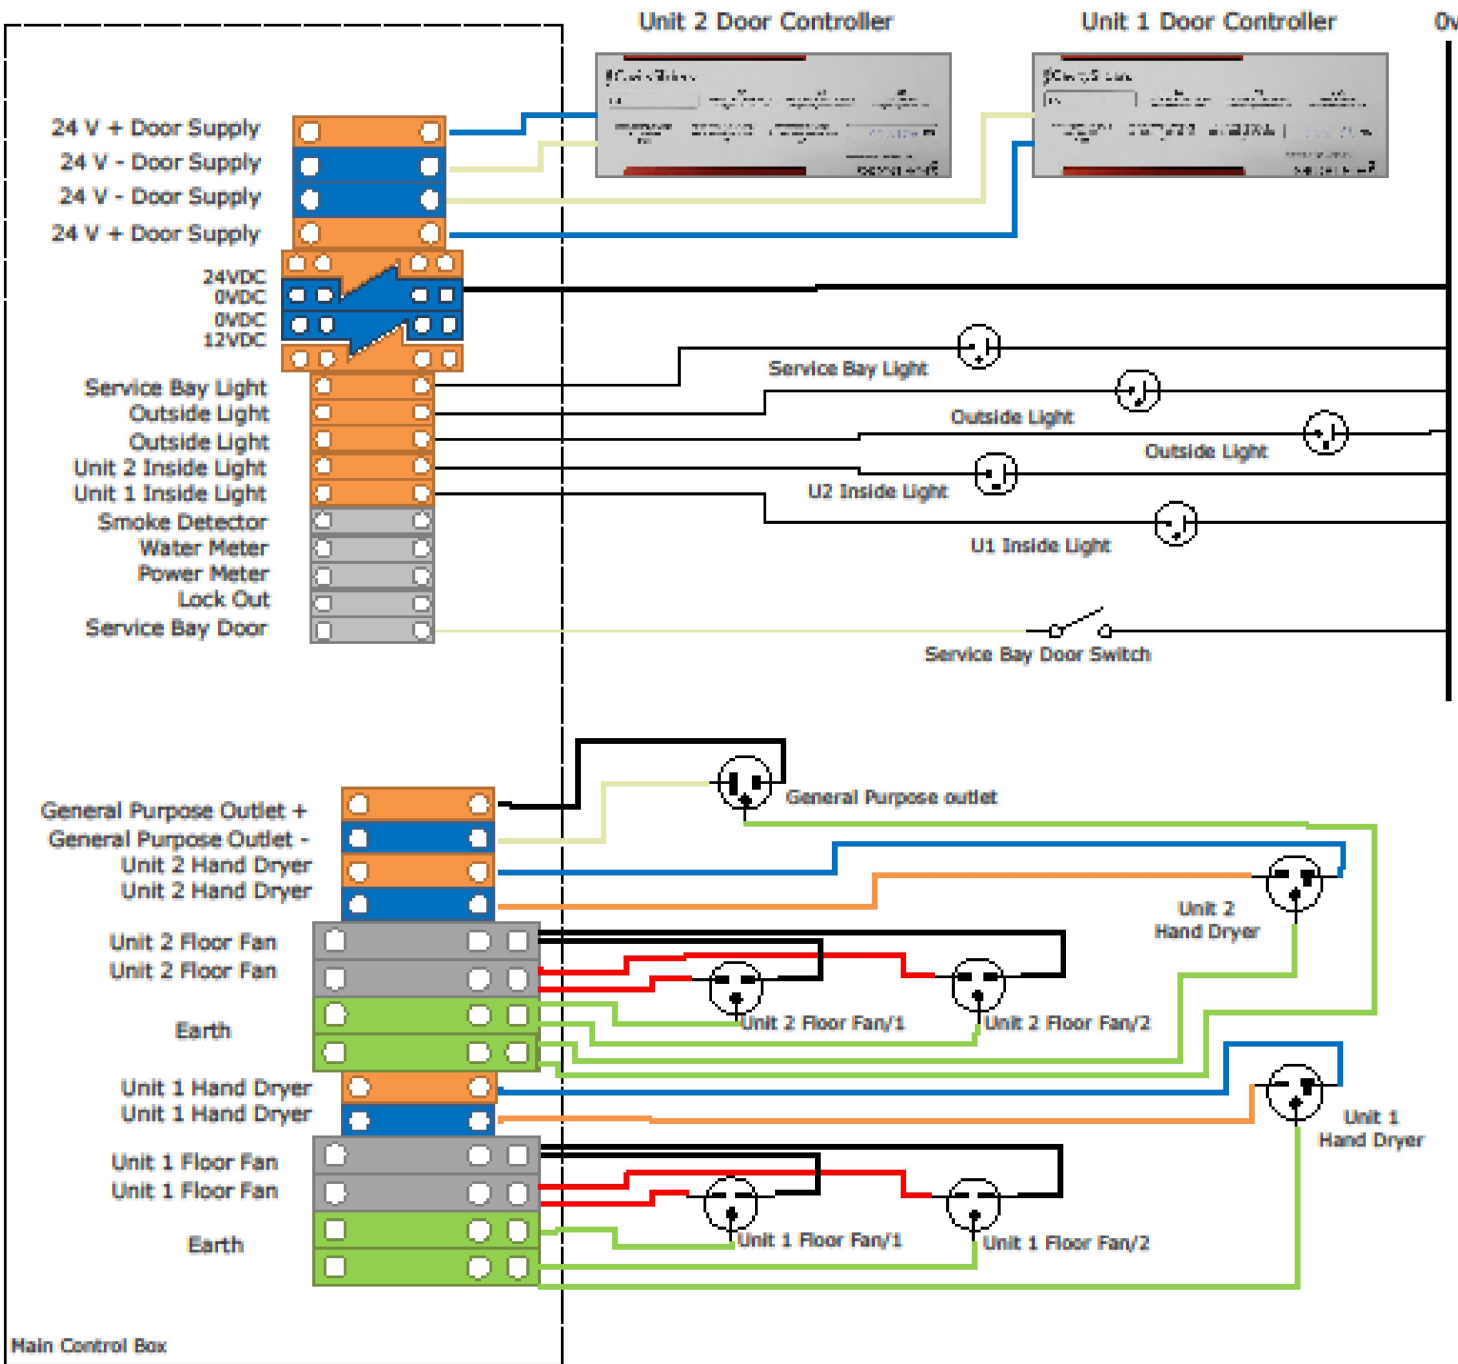

exelOO

New Zealand
26 Paramount Dve Henderson 0610
PO Box 33-256 Takapuna, Auckland
T: +64-9-838-8912 F: +64-9-838-8913

Australia
Unit 18, 62-66 Newton Rd Wetherill Park
PO Box 12 Liverpool NSW 1871
T: +61-2-975-3444 F: +61-2-1-800-105-504

USA
954 Toro St San Luis Obispo CA 93401
PO Box 13310 San Luis Obispo CA 93406
T: (800) 676-5290 or 1-800-303-3506

Description:
JUPITER TWIN ACCESSIBLE USA

Proj:

Units:
in

Rev:
1-H

Rev Date:
24/08/2022

Tolerance:
+/-0.5

Scale:
N.T.S.

Checked by:

Approved by:

Material:

Finish:
REF

Drawn by:
JJG

Creation Date:
16/04/2012

Sheet No:
B 28

Drawing No:
ASJUP22DD-US1BON

DO NOT SCALE - IF IN DOUBT ASK

SPECIFICATION SUBJECT TO CHANGE WITHOUT NOTICE

Max Load = General Load + Heating + Floor Fan + 1 Hand Dryer + Extra's				
General Load	315	480	2.63	4.00
	Watts		Amps	
	Black	Red	Black	Red
Heating	0	0	0.00	0.00
	Watts		Amps	
	Black	Red	Black	Red
One Unit Drying	3,000	3,000	12.50	12.50
	Watts		Amps	
	Black	Red	Black	Red
One Unit Hand Dryer	2,000	2,000	8.33	8.33
	Watts		Amps	
	Black	Red	Black	Red
Extra's	0	0	0.00	0.00
	Watts		Amps	
	Black	Red	Black	Red
	5,315	5,480	23.46	24.83



New Zealand

26 Paramount Dve Henderson 0610
PO Box 33-256 Takapuna, Auckland
T: +64-9-838-8912 F: +64-9-838-8913

Australia

Unit 18, 62-66 Newton Rd Wetherill Park
PO Box 12 Liverpool NSW 1871
T: +61-2-975-3444 F: +61-2-1-800-105-504

USA

954 Toro St San Luis Obispo CA 93401
PO Box 13310 San Luis Obispo CA 93406
T: (800) 676-5290 or 1-800-303-3506

Description:
JUPITER TWIN ACCESSIBLE USA

Proj:


Tolerance:
+/-0.5

Scale:
N.T.S.

Drawn by:
JJG

Creation Date:
16/04/2012

Material:
REF

Units:
in

Rev:
1-H

Checked by:

Approved by:


Sheet No:
B 29

Drawing No:
ASJUP22DD-US1BON

Rev Date:
24/08/2022

DO NOT SCALE - IF IN DOUBT ASK

SPECIFICATION SUBJECT TO CHANGE WITHOUT NOTICE

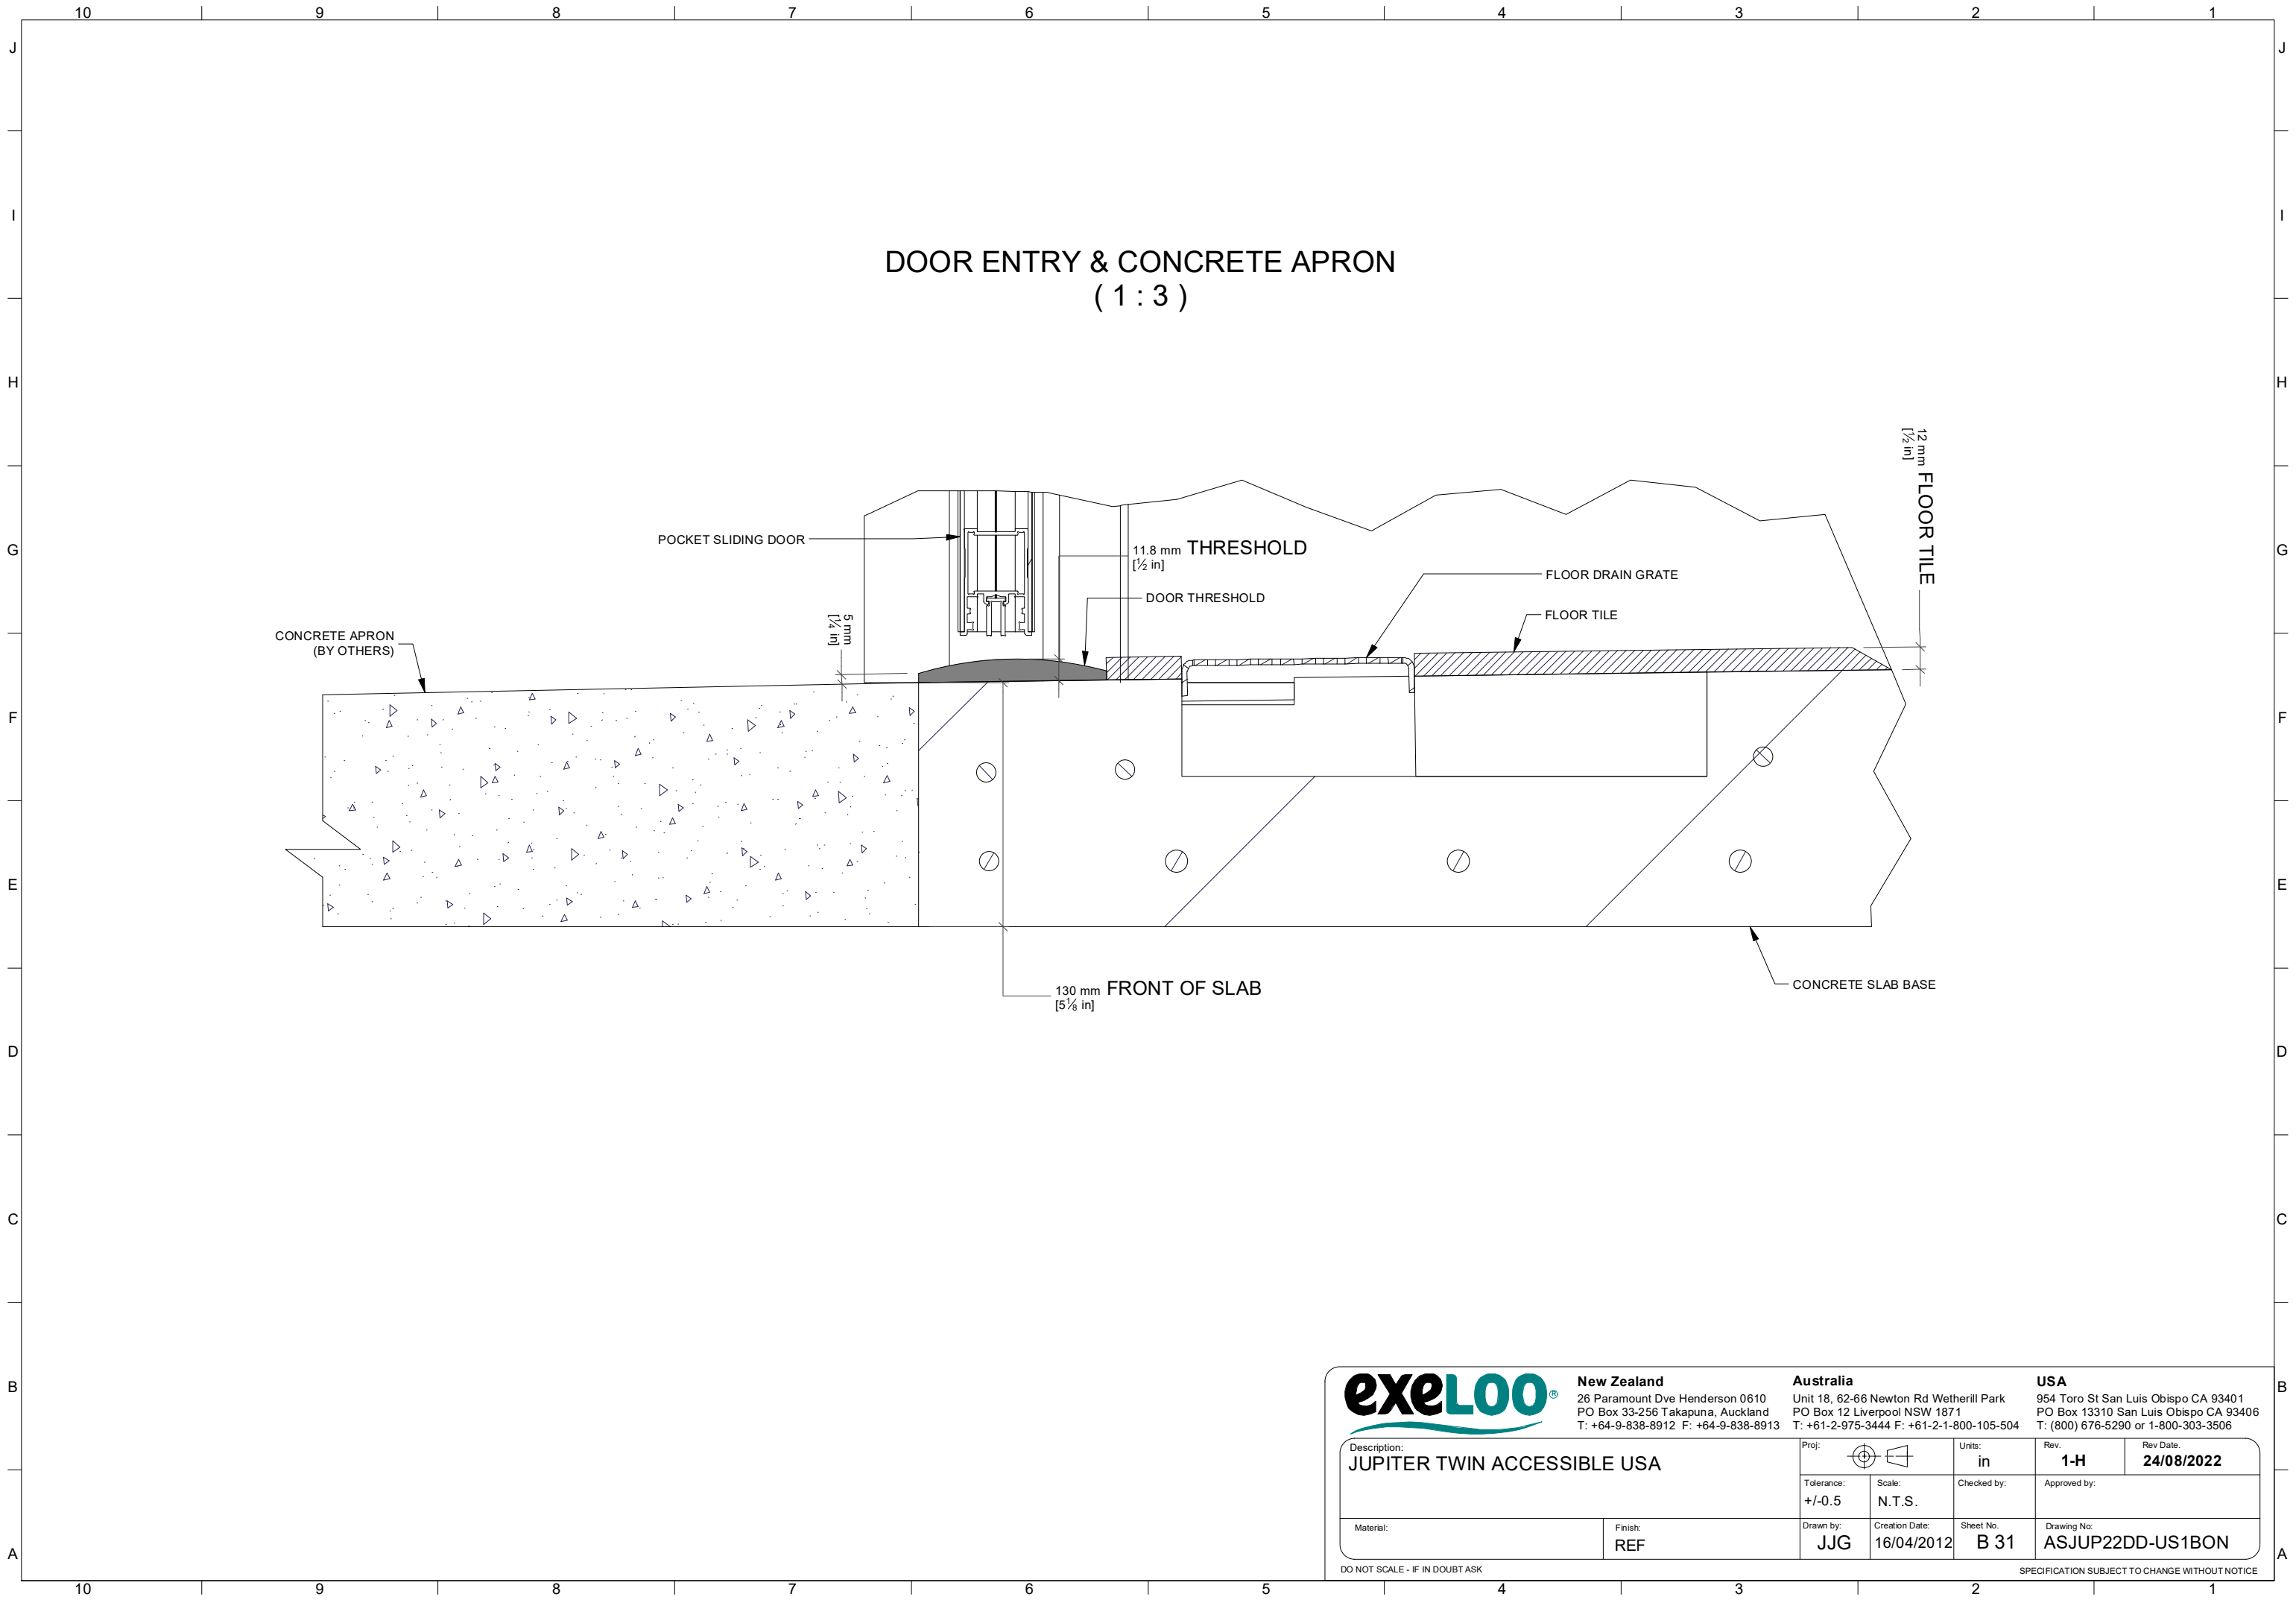

exeLOO®

New Zealand
26 Paramount Dve Henderson 0610
PO Box 33-256 Takapuna, Auckland
T: +64-9-838-8912 F: +64-9-838-8913

Australia
Unit 18, 62-66 Newton Rd Wetherill Park
PO Box 12 Liverpool NSW 1871
T: +61-2-975-3444 F: +61-2-1-800-105-504

USA
954 Toro St San Luis Obispo CA 93401
PO Box 13310 San Luis Obispo CA 93406
T: (800) 676-5290 or 1-800-303-3506

Description: JUPITER TWIN ACCESSIBLE USA		Proj: 		Units: in	Rev: 1-H	Rev Date: 24/08/2022
Tolerance: +/-0.5		Scale: N.T.S.		Checked by:		Approved by:
Material:	Finish: REF	Drawn by: JJG	Creation Date: 16/04/2012	Sheet No: B 31	Drawing No: ASJUP22DD-US1BON	

DO NOT SCALE - IF IN DOUBT ASK

SPECIFICATION SUBJECT TO CHANGE WITHOUT NOTICE